


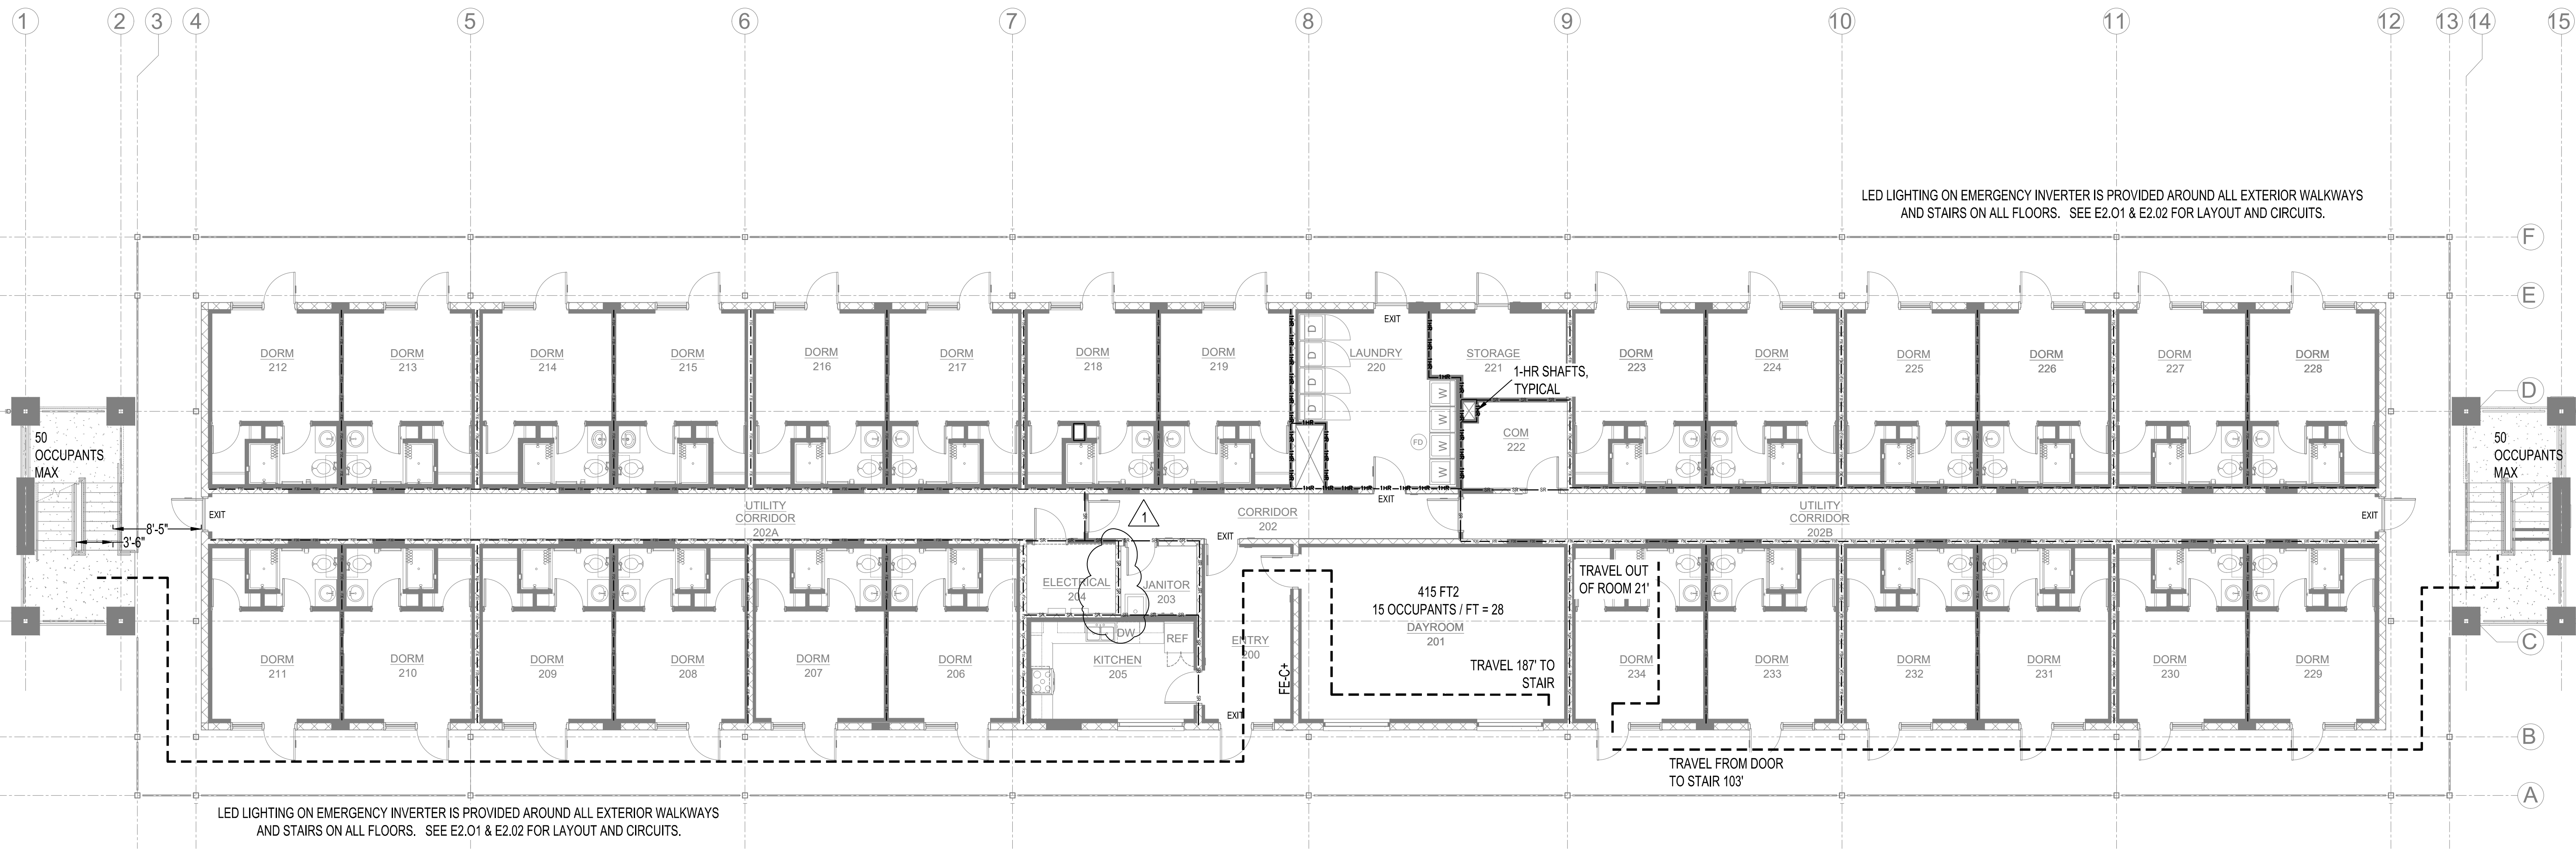

OCCUPANTS THIS FLOOR:
26 - QUEST ROOMS
28 - DAY ROOM
2 - LAUNDRY
2 - KITCHEN
58 CALCULATED AREA WITH DAY ROOM, LAUNDRY,
KITCHEN SERVICING THE SAME GUEST ROOM
OCCUPANTS. AS SUCH, FLOOR OCCUPANT LOAD NOT
ANTICIPATED TO EXCEED 50.

FIRE EXTINGUISHER AND CABINET:
PROVIDE MINIMUM 2A: 20B: C RECHARGEABLE FIRE EXTINGUISHER IN
ACCORDANCE WITH NFPA 10 FOR ORDINARY HAZARD. EXTINGUISHER
TO BE PROVIDED WITH PRESSURE GAUGE INDICATING CHARGE.

PROVIDE A WHITE, STEEL, POWDER-COATED / POLYESTER-COATED
FIRE EXTINGUISHER CABINET WHERE INDICATED.

CABINET TO HAVE A CLEAR WINDOW TO VISUALLY VERIFY
EXTINGUISHER IS PRESENT.

CABINET TO BE SEMI-RECESSED AT WALL FUR-OUT IF DEPTH WILL
ACCOMMODATE. OTHERWISE SURFACE MOUNTED.

TOP OF CABINET TO BE MOUNTED TO ENSURE THAT NEITHER THE
HANDLE TO OPEN OR THE TOP OF THE EXTINGUISHER WILL BE
HIGHER THAN 48" ABOVE FINISHED FLOOR.

PROVIDE NECESSARY FRAMING/BLOCKING TO SECURE CABINET AT
INDICATED LOCATION. COORDINATE WITH ARCHITECTURAL
DRAWINGS AND FIRE ALARM LOCAL OPERATOR CONTROL PANEL TO
BE MOUNTED IN SAME VICINITY.

PROVIDE ACROSS FROM 2ND FLOOR KITCHEN.



LITTLE ROCK A.F.B.
ARKANSAS



CLEMENTS & ASSOCIATES
ARCHITECTURE, INC.
507 MAIN STREET
NORTH LITTLE ROCK, ARKANSAS 72114
PHONE: 501-375-3380
WWW.CLEMENTSARCHITECTS.COM



Lacey
Fire Protection
Engineering
WWW.LACEYFPE.COM

No.	Revision/Issue	Date	BY	APP'D
1	100 REVISED SUBMITAL	04/26/2024		

PROJECT TITLE
REPAIR (SUS) AIRMEN
DORMITORY BLDG 854

SHEET TITLE
LIFE SAFETY -
SECOND FLOOR PLAN

DRAWN BY SL	LEAD DESIGNER SL
TECH REVIEWER SL	PROJECT NUMBER NKAK 21-1034
DESIGNED BY SL	SHEET LS1.02
DATE 29 FEB. 2024	SCALE AS NOTED

03 OF 100