



LITTLE ROCK A.F.B.
ARKANSAS



**CLEMENTS
& ASSOCIATES**
ARCHITECTURE, INC.
507 MAIN STREET
NORTH LITTLE ROCK, ARKANSAS 72114
PHONE: 501-373-3380
WWW.CLEMENTSARCHITECTS.COM



Lacey
Fire Protection
Engineering
WWW.LACEYFPE.COM

No.	Revision/Issue	Date	BY	APP'D
1	100 REVISED SUBMITAL	04/26/2024		


PROJECT TITLE
REPAIR (SUS) AIRMEN
DORMITORY BLDG 854

SHEET TITLE
LIFE SAFETY -
THIRD FLOOR PLAN

DRAWN BY SL	LEAD DESIGNER SL
TECH REVIEWER SL	PROJECT NUMBER NKAK 21-1034
DESIGNED BY SL	SHEET LS1.03
DATE 29 FEB. 2024	SCALE AS NOTED

04 OF 100

OCCUPANTS THIS FLOOR:
26 - QUEST ROOMS
28 - DAY ROOM
2 - LAUNDRY
2 - KITCHEN
58 CALCULATED AREA WITH DAY ROOM, LAUNDRY,
KITCHEN SERVICING THE SAME GUEST ROOM
OCCUPANTS. AS SUCH, FLOOR OCCUPANT LOAD NOT
ANTICIPATED TO EXCEED 50.

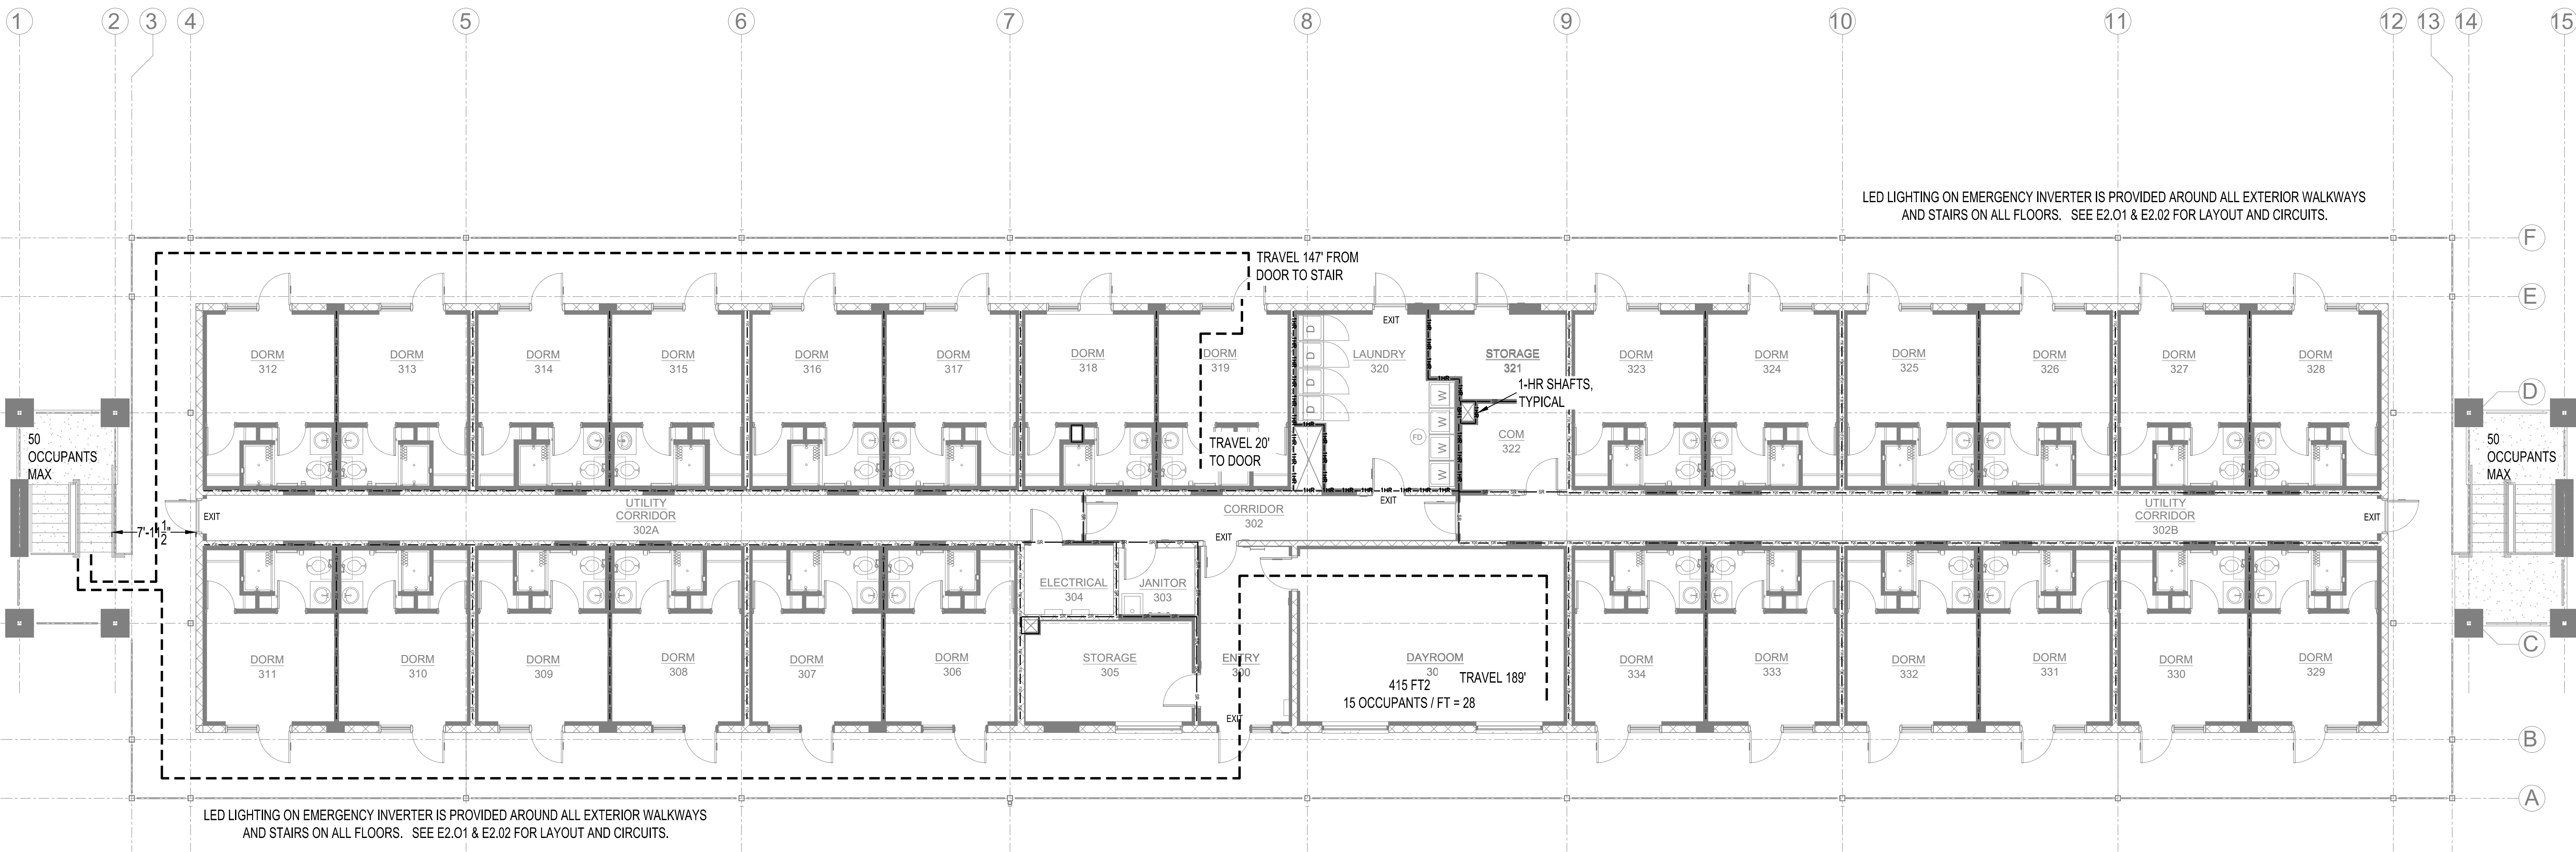

1 LIFE SAFETY - THIRD FLOOR
1/8" = 1'

