
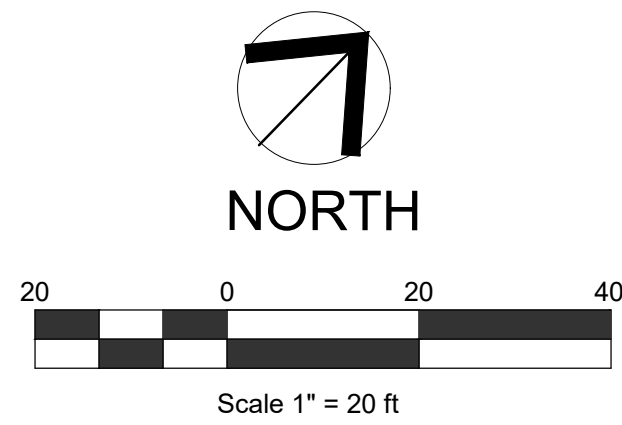


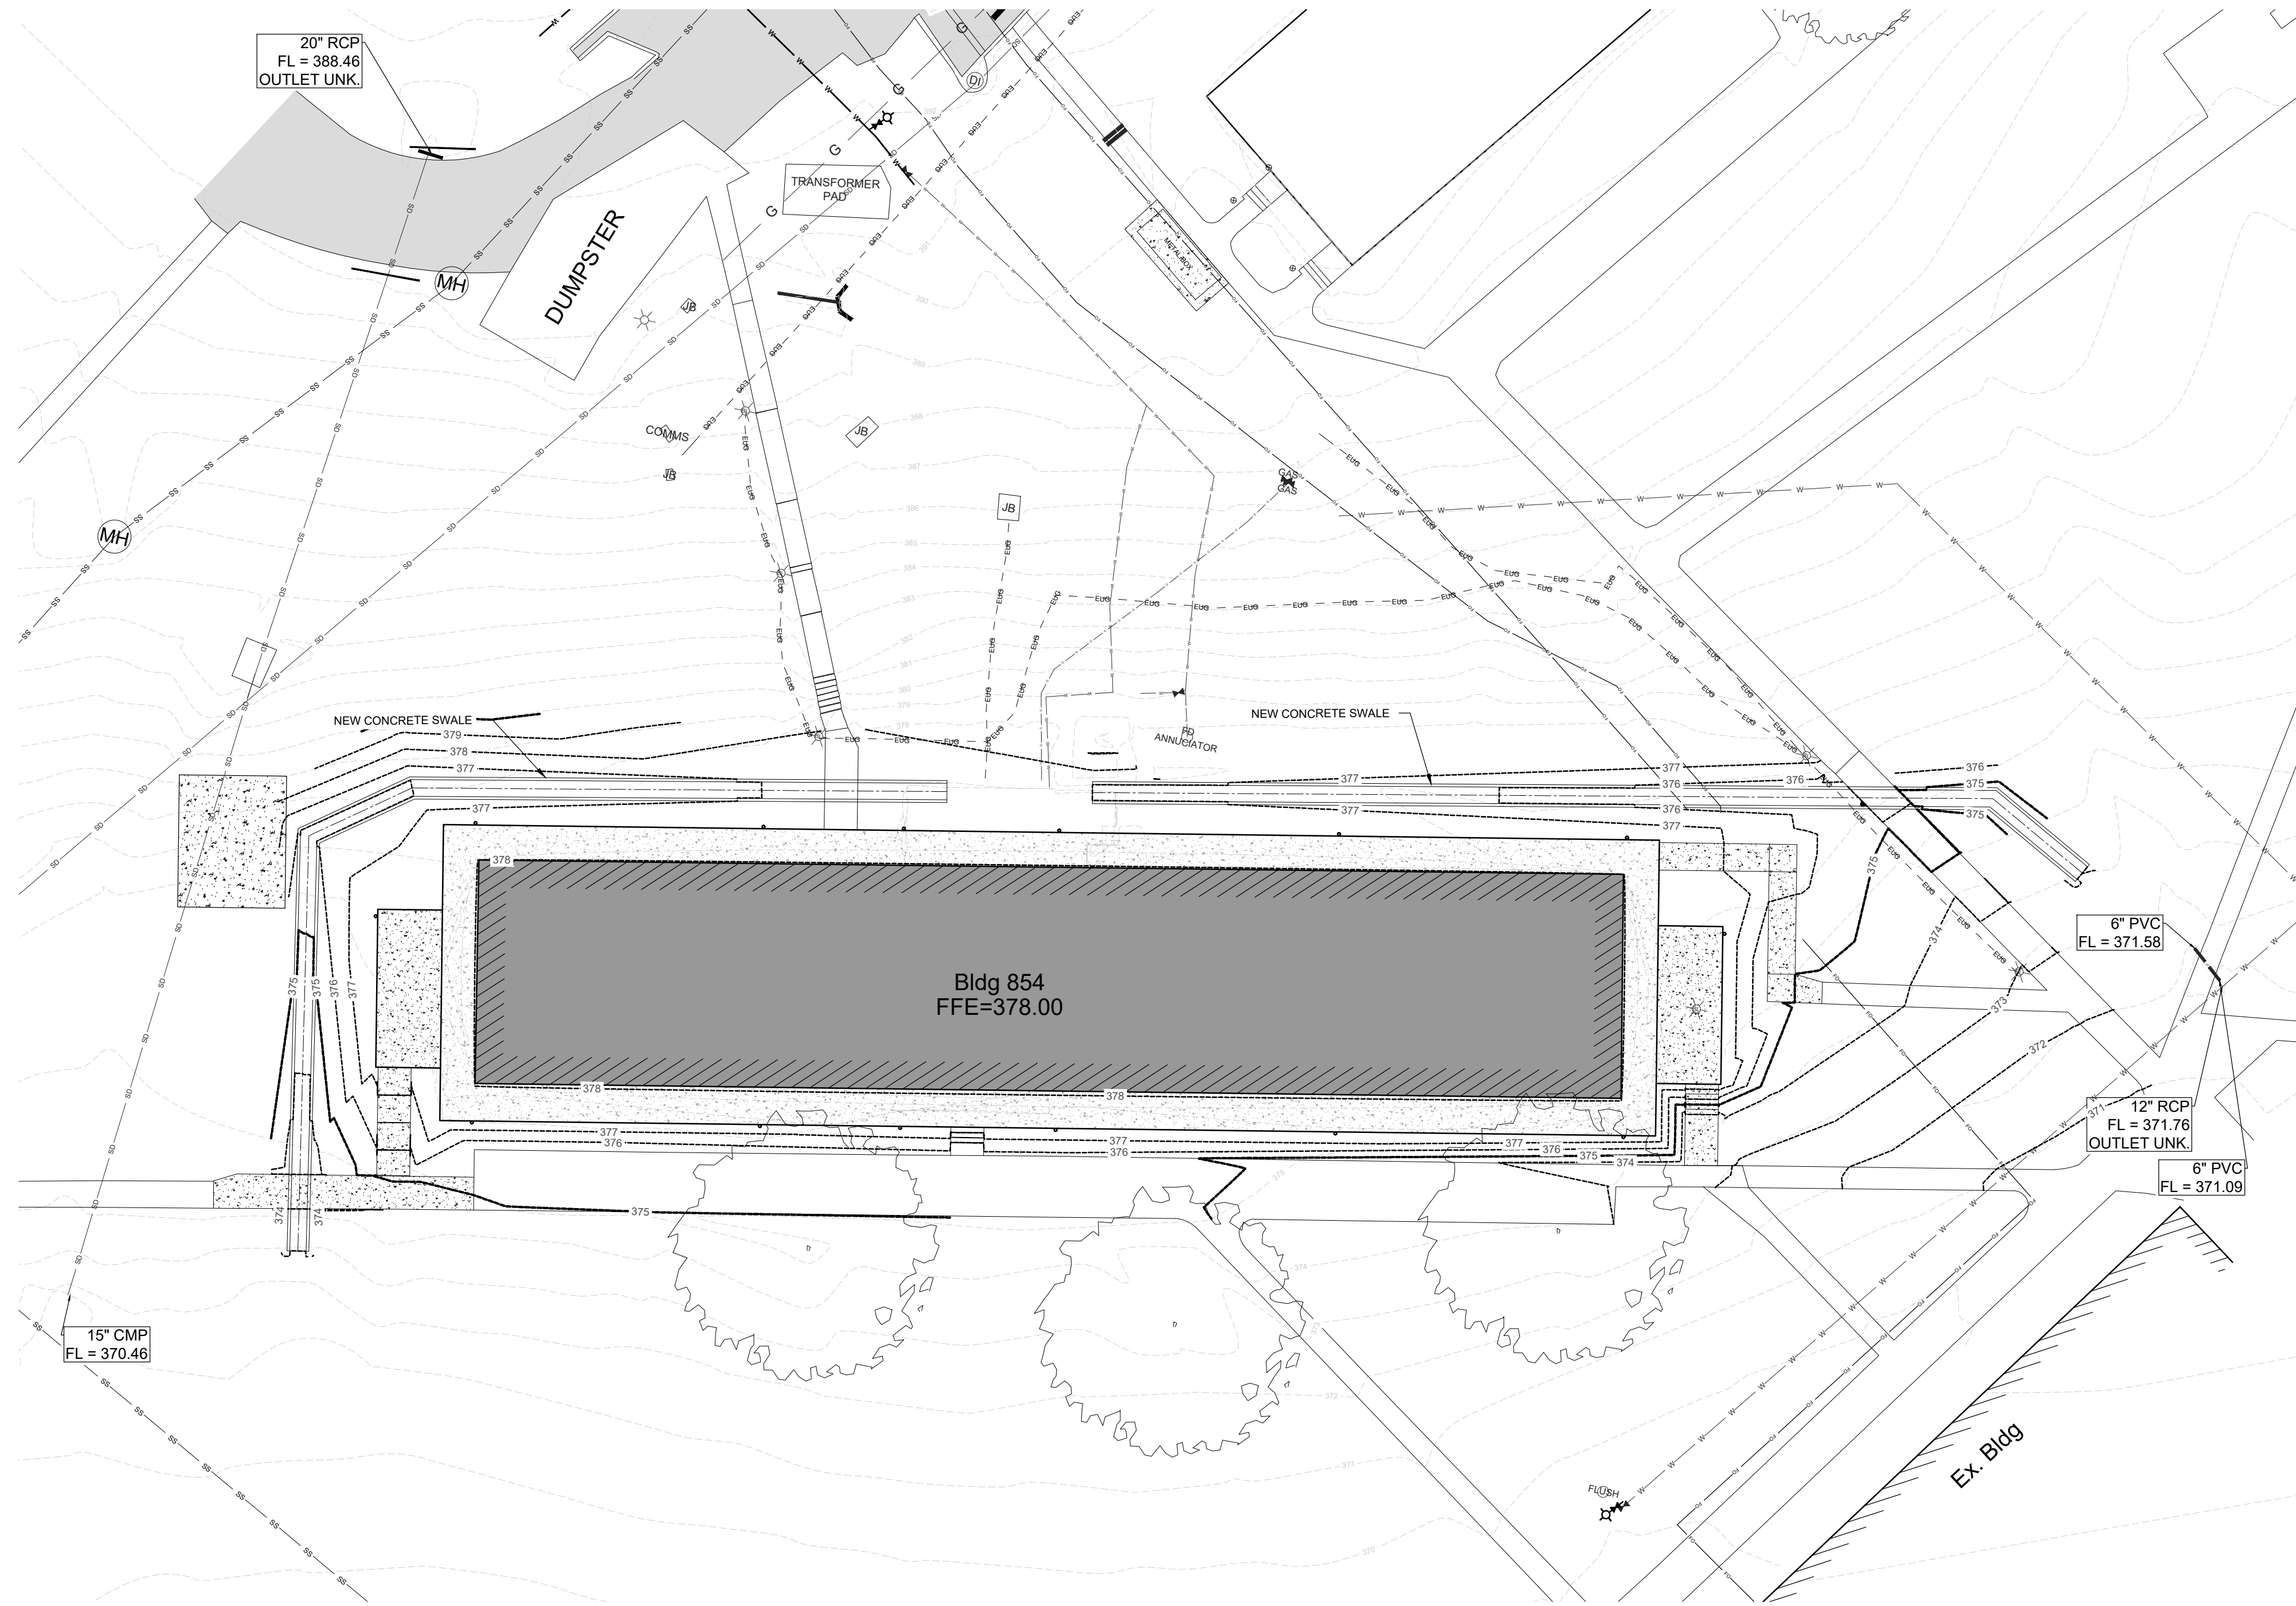

- GENERAL NOTES:
1. SITE CIVIL WORK INCLUDES GRADING ALONG THE NORTHERN FACE ALONG WITH AREAS DRAINS AND STORM DRAINAGE PIPING. STORM DRAINAGE PIPING TO THE WEST TO TIE INTO EXISTING DRAINAGE INFRASTRUCTURE. SIDEWALKS WILL BE MODIFIED TO ADDRESS ACCESSIBLE PATHS.

1 CIVIL SITE PLAN
SCALE: 1" = 20'

LEGEND:	
	EXISTING CONTOUR LINE
	WATER LINE
	STORM DRAIN LINE
	UNDERGROUND ELECTRIC
	SANITARY SEWER
	GAS LINE
	FIBER OPTIC
	WATER VALVE
	FIRE HYDRANT
	STORM INLET
	BOLLARD LIGHT
	JUNCTION BOX
	SIDEWALK/CONCRETE

BOND CONSULTING ENGINEERS, INC.
2601 T. P. White Drive
Jacksonville, Arkansas 72076
Phone: (501) 982-1538 Fax: (501) 982-1530 E-mail: arobinson@bondce.com



LITTLE ROCK A.F.B.
ARKANSAS



CLEMENTS & ASSOCIATES
ARCHITECTURE, INC.
507 MAIN STREET
NORTH LITTLE ROCK, ARKANSAS 72114
PHONE: 501-375-3380
WWW.CLEMENTSARCHITECTS.COM



						APPD
						BY
						Date
						Revision/Issue
						No.

PROJECT TITLE	REPAIR (SUS) ARMEN DORMITORY BLDG 854	
	CIVIL SITE PLAN	
	LEAD DESIGNER	
	AR	
SHEET TITLE	PROJECT NUMBER	
	NKAK 21-1034	
	SHEET	
	C2.00	
DATE		29 FEB. 2024
SCALE		AS NOTED
07		OF 100