



- KEYED DEMOLITION NOTES**
1. REMOVE AND DISPOSE OF EXISTING EXTERIOR WINDOWS AND LOUVERS IN MASONRY WALLS. REMOVE AND SALVAGE PRECAST WINDOW SILLS FOR REINSTALLATION.
 2. REMOVE AND DISPOSE OF EXISTING DOOR, FRAME, AND HARDWARE.
 3. REMOVE AND DISPOSE OF EXISTING INTERIOR WALLS, DOORS, FRAMES, AND HARDWARE. NOTE: WALLS ARE A COMBINATION OF STUD WALL AND CLAY TILE CONSTRUCTION AT PLUMBING CHASES.
 4. REMOVE AND DISPOSE OF INTERIOR FURRING STUDS AND GYPSUM WALL BOARD. (EXISTING STRUCTURE TO REMAIN.)
 5. REMOVE AND DISPOSE OF EXISTING MASONRY PIPE CHASE. SAW CUT FLOOR SLAB TO PROVIDE A CLEAN EDGE FOR CONCRETE INFILL. CONTRACTOR IS RESPONSIBLE FOR PROVIDING SAFETY PRECAUTIONS AT THESE MULTI-STORY CHASES. RE: STRUCTURAL
 6. SAW CUT WALL AND REMOVE PORTION OF MASONRY WALL FOR NEW DOOR AS SCHEDULED. TYPICAL ENTIRE BUILDING. (REFER TO A6.01)
 7. REMOVE AND DISPOSE OF EXISTING FLOORING DOWN TO CONCRETE SLAB. RE: MECHANICAL AND PLUMBING
 8. REMOVE AND DISPOSE OF EXISTING PLUMBING FIXTURES, TOILET ACCESSORIES, ASSOCIATED MILLWORK, AND PIPING. RE: PLUMBING
 9. REMOVE AND DISPOSE OF EXISTING DOOR AND HARDWARE. FRAME TO REMAIN.

- GENERAL DEMOLITION NOTES**
1. THE CONTRACTOR SHALL ABATE ALL HAZARDOUS MATERIALS PRIOR TO DEMOLITION.
 2. REMOVE AND DISPOSE OF ALL EXISTING FURNITURE AND MISCELLANEOUS LOOSE ITEMS THROUGHOUT THE BUILDING.
 3. DEMOLISHED MATERIALS ARE TO BE REMOVED FROM THE BUILDING AND SITE IMMEDIATELY UPON REMOVAL FROM THE AREA OF WORK AND ARE TO BE DISPOSED OF IN A PROPER LANDFILL UNLESS OTHERWISE NOTED.
 4. REMOVE ALL EXISTING FIRE EXTINGUISHERS AND TURN OVER TO LRAFB FIRE DEPARTMENT.
 5. REMOVE AND DISPOSE OF EXISTING FIRE PROTECTION DEVICES AND SPRINKLER SYSTEMS. RE: FIRE PROTECTION
 6. REMOVE AND DISPOSE OF EXISTING PLUMBING FIXTURES, TOILET ACCESSORIES, ASSOCIATED MILLWORK, AND PIPING. RE: PLUMBING
 7. REMOVE AND DISPOSE OF REMAINING MECHANICAL ASSOCIATED ITEMS.
 8. REMOVE AND DISPOSE OF ALL ELECTRICAL FIXTURES. RE: ELECTRICAL
 9. REFER TO CIVIL FOR ADDITIONAL SITE DEMOLITION REQUIREMENTS.
 10. REMOVE AND DISPOSE OF ALL EXISTING SUSPENDED CEILING SYSTEMS AND GYPSUM CEILINGS. WHERE TEXTURED CEILINGS REMOVED BY ABATEMENT, CLEAN AND PREPARE FOR NEW TEXTURE.

- LOAD BEARING WALL NOTES**
1. EXISTING BUILDING SECTIONS ARE SHOWN FOR REFERENCE OF EXISTING DOOR OPENINGS AND LOCATION OF NEW DOOR OPENINGS. REFER TO A6.01 AND A6.02 FOR LOCATION OF NEW DOORS.
 2. REFER TO FIRE PROTECTION, PLUMBING, MECHANICAL, ELECTRICAL FOR ADDITIONAL ELEMENTS THAT MAY PENETRATE EXISTING WALLS.
 3. REFER TO STRUCTURAL STRENGTHENING DRAWINGS FOR REQUIREMENTS OF LOAD BEARING WALL REINFORCEMENT.

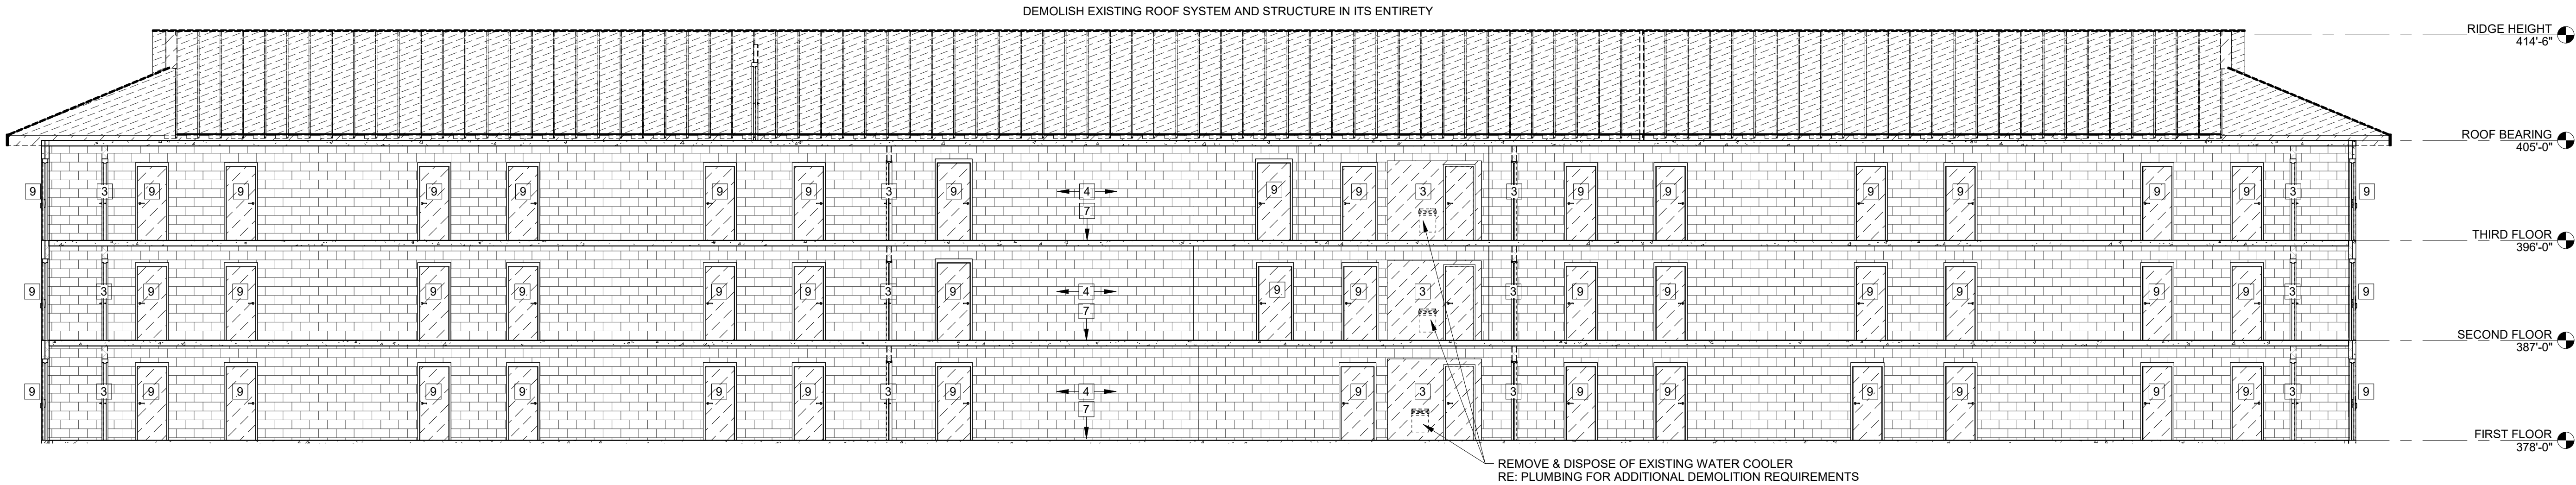

2 EXISTING BUILDING SECTION FACING SOUTH
1/8" = 1'-0"

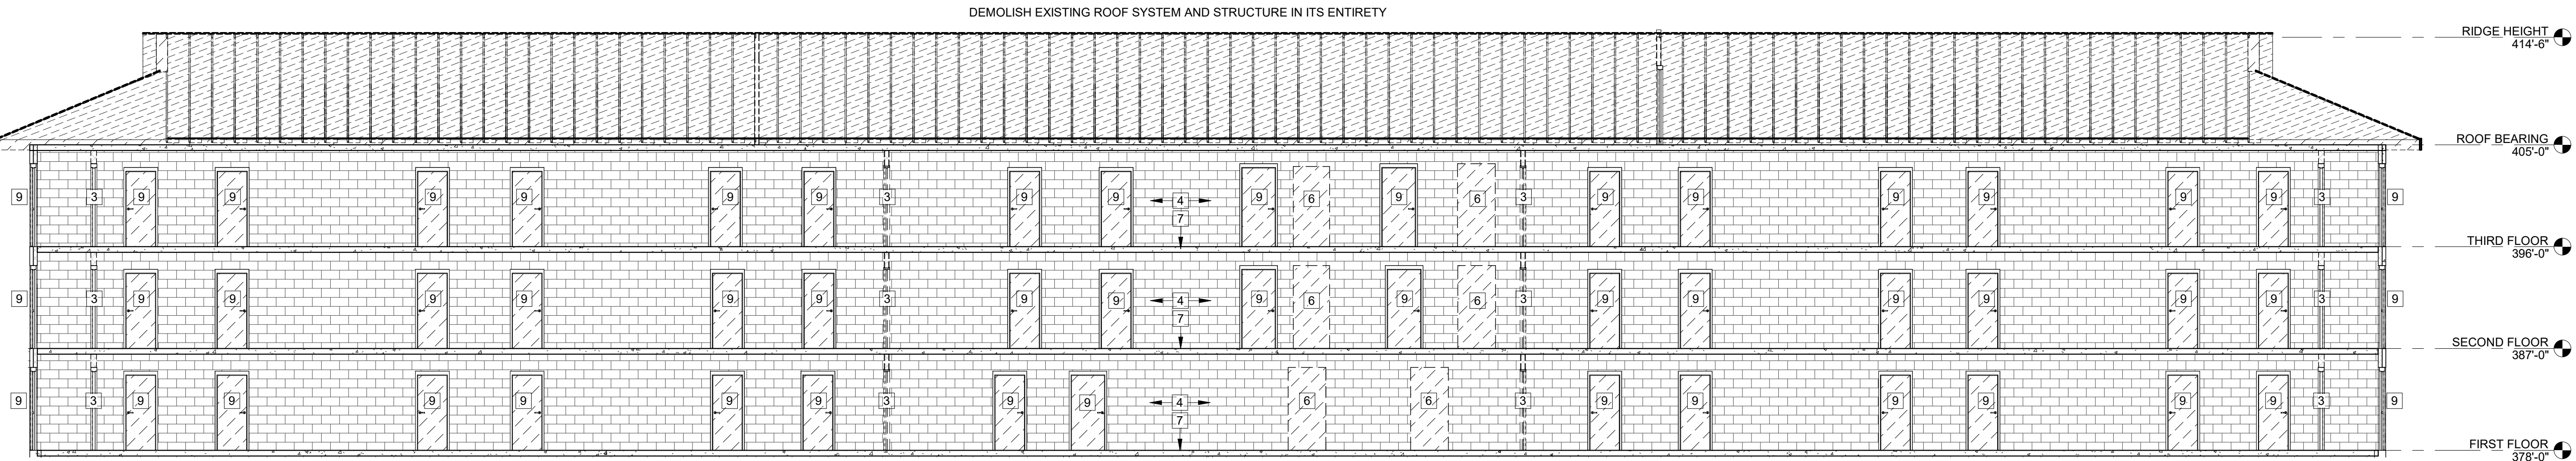

1 EXISTING BUILDING SECTION FACING NORTH
1/8" = 1'-0"



LITTLE ROCK A.F.B.
ARKANSAS

HGL
Construction

CLEMENTS & ASSOCIATES
ARCHITECTURE, INC.
507 MAIN STREET
NORTH LITTLE ROCK, ARKANSAS 72114
PHONE: 501-375-3380
WWW.CLEMENTSARCHITECTS.COM



No.	Revision/Issue	Date	BY	APPD

PROJECT TITLE DRAWN BY HRS, BD, DR TECH REVIEWER HRS DESIGNED BY C&A DATE 29 FEB. 2024 SCALE AS NOTED	SHEET TITLE EXISTING BUILDING SECTIONS	LEAD DESIGNER C&A
		PROJECT NUMBER NKA 21-1034
		SHEET AD2.01
		32
		OF 100