



HGL
Construction

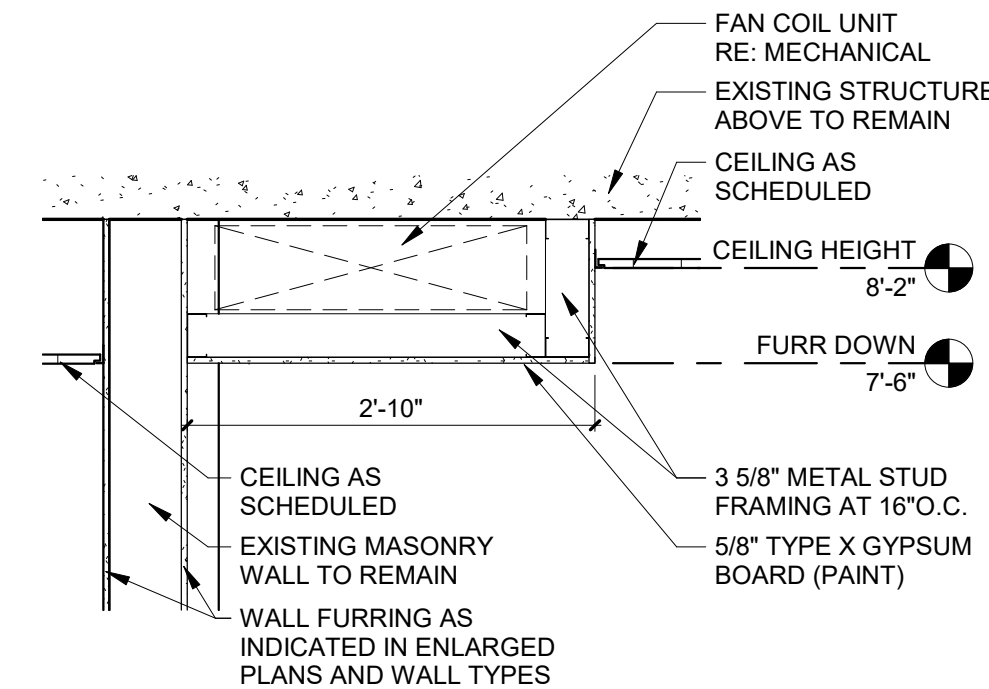
CLEMENTS & ASSOCIATES
ARCHITECTURE, INC.

507 MAIN STREET
NORTH LITTLE ROCK, ARKANSAS 72114
PHONE: 501-375-3380
WWW.CLEMENTSARCHITECTS.COM

[illegible]REPAIR (SUS) ARMEN
DORMITORY BLDG 854










FIRST FLOOR REFLECTED CEILING PLAN, DETAIL AND SYMBOLS LEGEND


DRAWN BY CHRS, BD, DR	LEAD DESIGNER C&A
TECH REVIEWER CHRS	PROJECT NUMBER NKAK 21-1034
DESIGNED BY C&A	SHEET A1.04
DATE 29 FEB. 2024	
SCALE	36 OF 100
AS NOTED	



2 FURR DOWN @ DAY ROOM 103
3/4" = 1'-0"

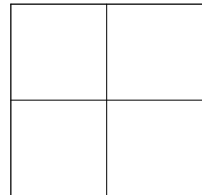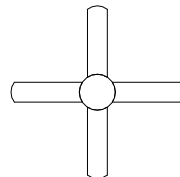       RCP SYMBOLS LEGEND

	<u>ROOM NAME</u> ROOM NUMBER		<u>CEILING FAN</u> RE: ELECTRICAL
	<u>ACOUSTICAL SUSPENDED CEILING SYSTEM</u> RE: PROJECT MANUAL		<u>RECESSED LIGHT FIXTURE</u> RE: ELECTRICAL
	<u>TEXTURED CEILING (PAINT)</u>		<u>WALL-MOUNTED LIGHT FIXTURE</u> RE: ELECTRICAL
	<u>GYPSUM CEILING (PAINT)</u>		<u>SURFACE MOUNTED LIGHT FIXTURE</u> RE: ELECTRICAL
	<u>LINEAR LIGHT FIXTURE</u> RE: ELECTRICAL		<u>SUPPLY GRILLE</u> RE: MECHANICAL
	<u>2X2 LIGHT FIXTURE</u> RE: ELECTRICAL		<u>RETURN GRILLE</u> RE: MECHANICAL
	<u>SPECIALTY 2X2 LIGHT FIXTURE</u> RE: ELECTRICAL		<u>CEILING HEIGHT</u>
	<u>SUSPENDED UNIT HEATER</u> RE: MECHANICAL		<u>EMERGENCY SIGNAGE</u> RE: LIFE SAFETY AND ELECTRICAL
	<u>CARBON MONOXIDE DETECTOR</u> RE: FIRE PROTECTION		<u>CEILING MOUNTED STROBE</u> RE: FIRE PROTECTION

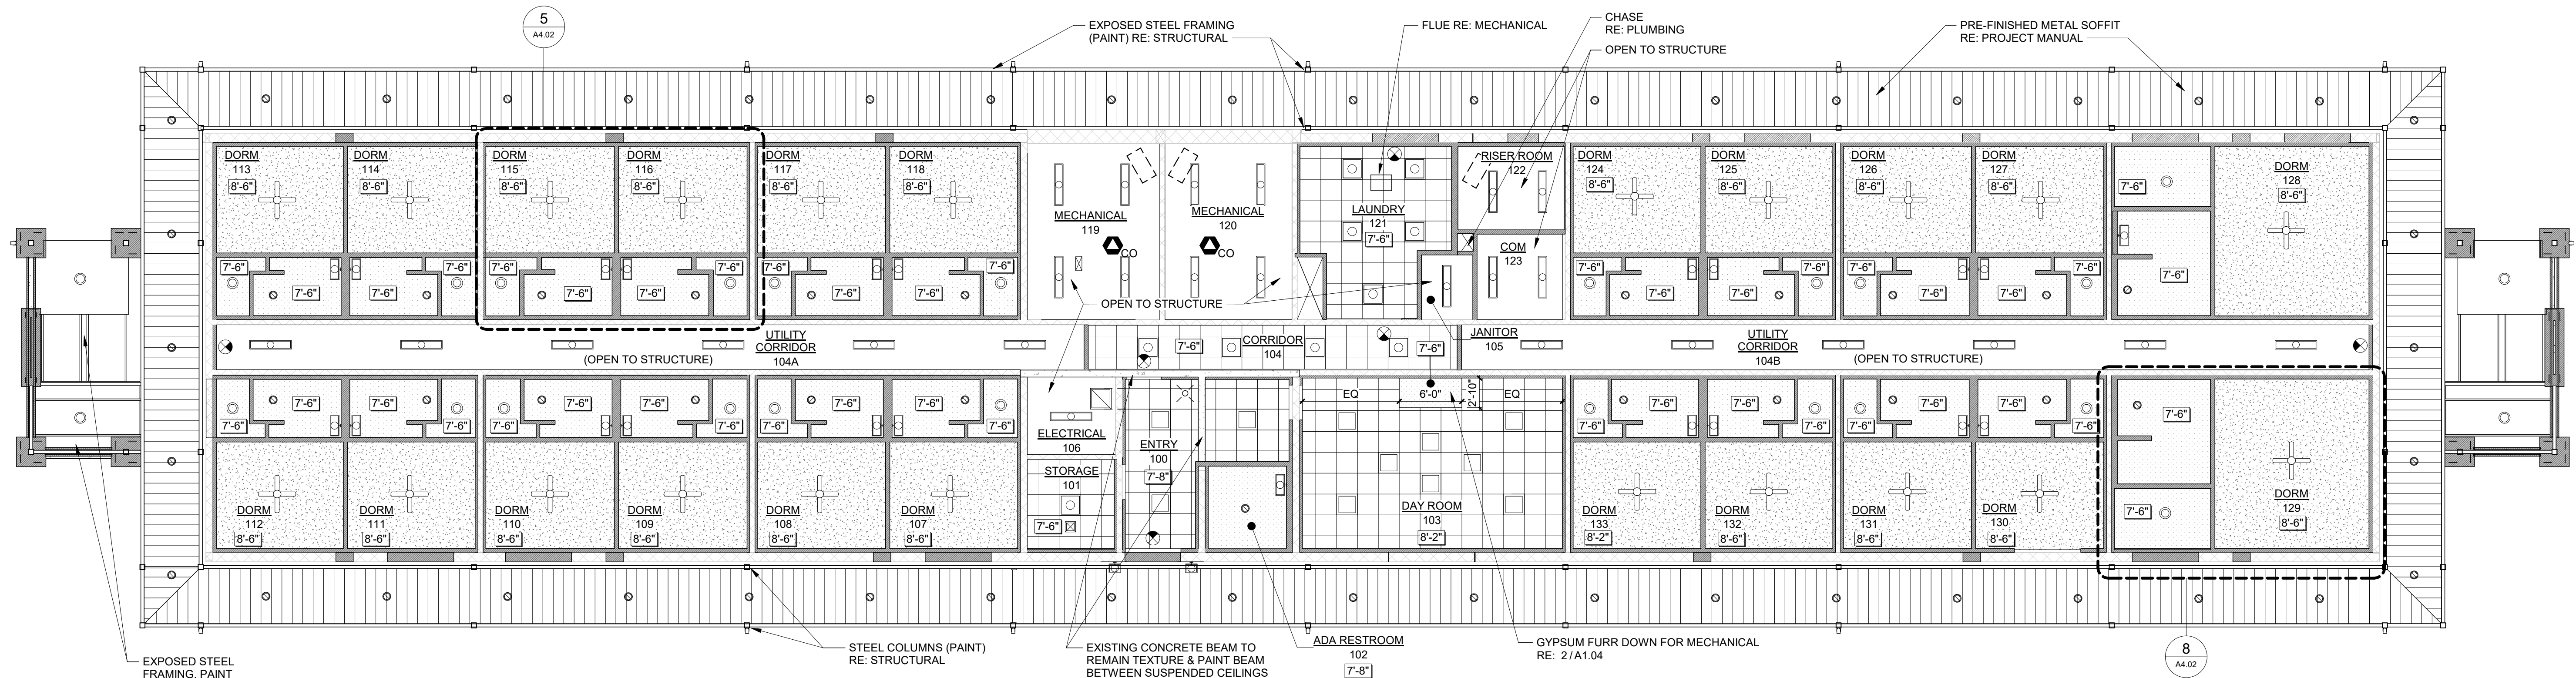

1 FIRST FLOOR - REFLECTED CEILING PLAN

