




LITTLE ROCK A.F.B.
ARKANSAS



CLEMENTS & ASSOCIATES
ARCHITECTURE, INC.
507 MAIN STREET
NORTH LITTLE ROCK, ARKANSAS 72114
PHONE: 501-373-3380
WWW.CLEMENTSARCHITECTS.COM

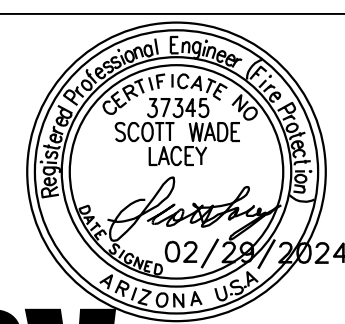


Lacey
Fire Protection
Engineering
WWW.LACEYFPE.COM

NO.	REVISION/ISSUE	DATE	BY	APP'D
1	100 REVISED SUBMITTAL	04/26/2024		

PROJECT TITLE
REPAIR (SUS) AIRMEN
DORMITORY BLDG 854

SHEET TITLE
FIRE ALARM & MNS -
FIRST FLOOR PLAN

DRAWN BY SL	LEAD DESIGNER SL
TECH REVIEWER SL	PROJECT NUMBER NKAK 21-1034
DESIGNED BY SL	SHEET FA1.01
DATE 29 FEB. 2024	
SCALE AS NOTED	59 OF 100

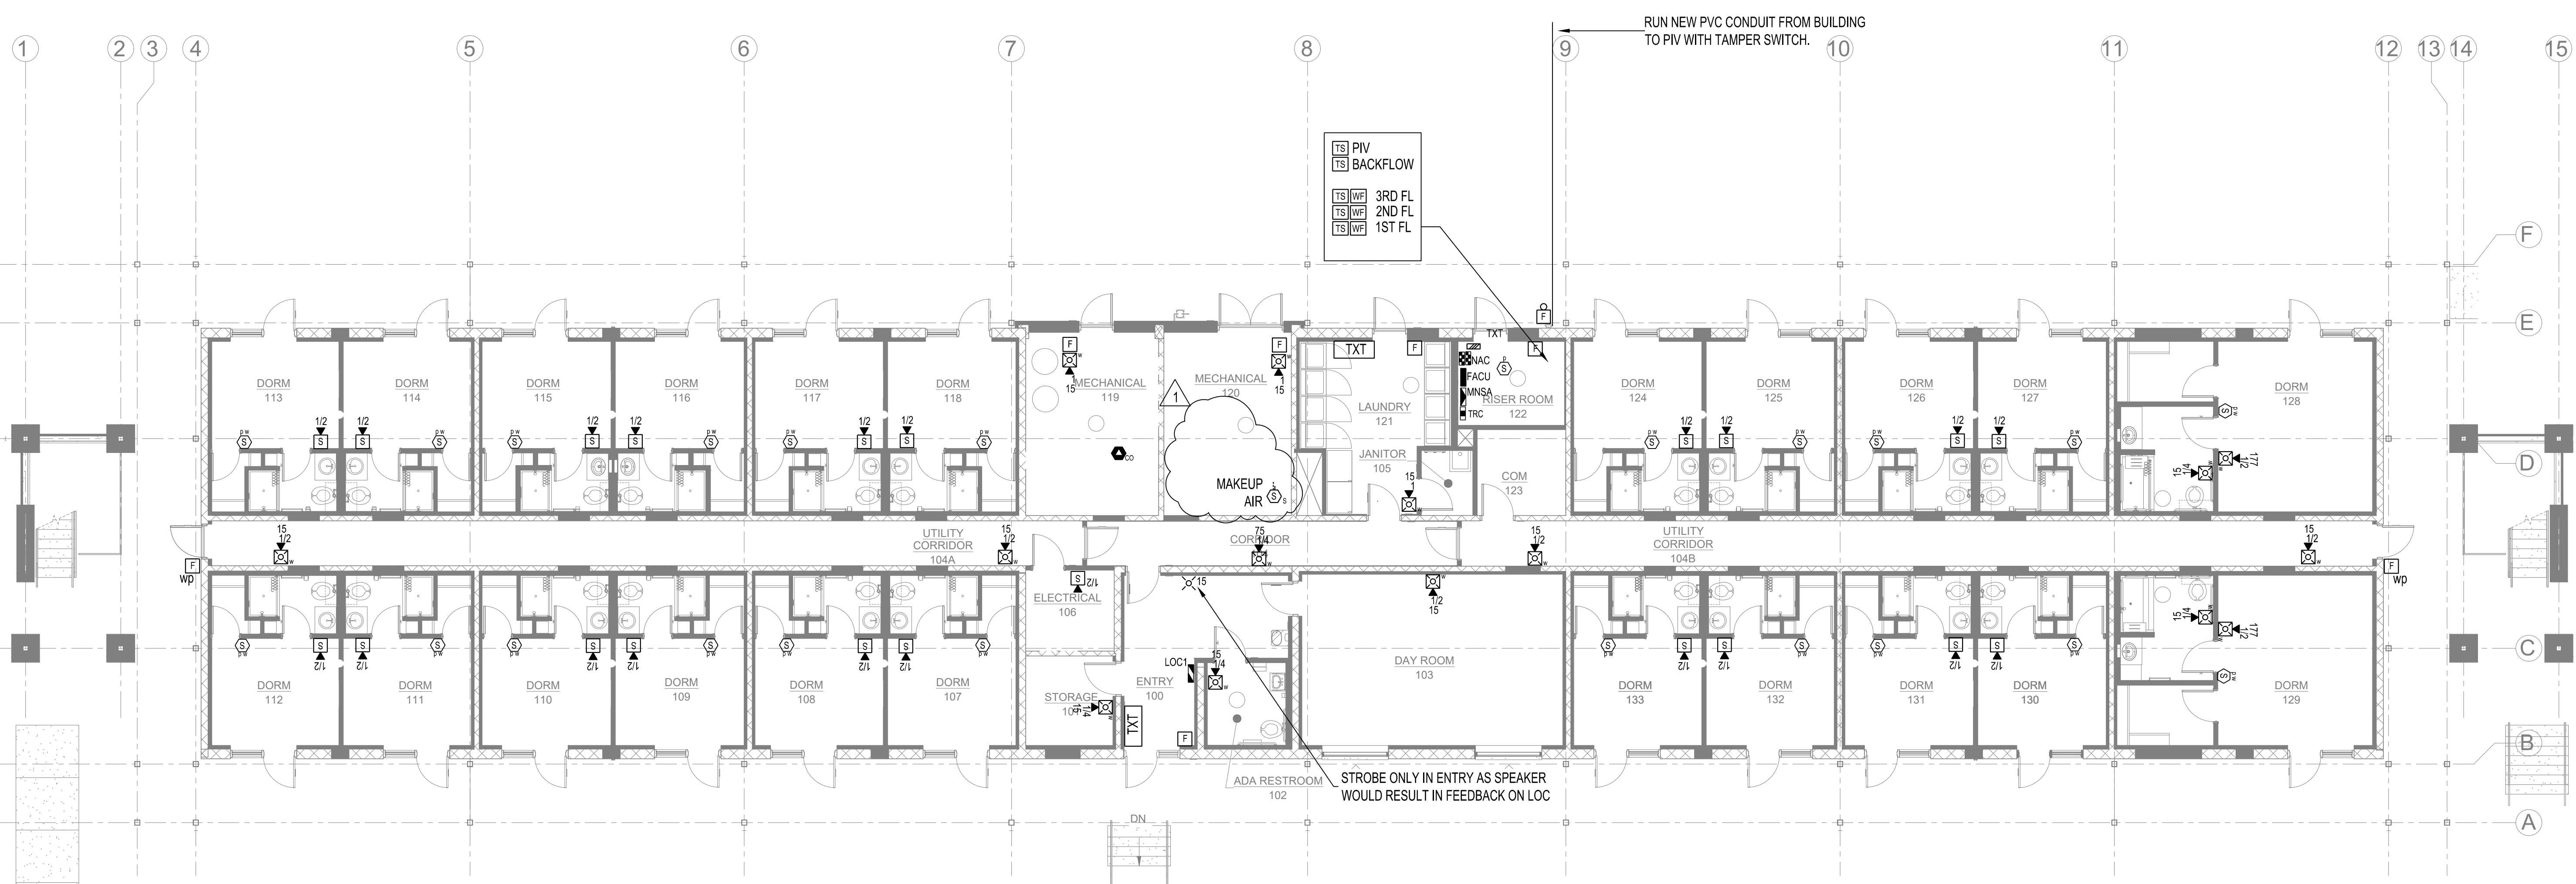

1 FIRE ALARM AND MASS NOTIFICATION - FIRST FLOOR
1/8" = 1'
NORTH