





LITTLE ROCK A.F.B.
ARKANSAS



CLEMENTS & ASSOCIATES
ARCHITECTURE, INC.
507 MAIN STREET
NORTH LITTLE ROCK, ARKANSAS 72114
PHONE: 501-375-3380
WWW.CLEMENTSARCHITECTS.COM

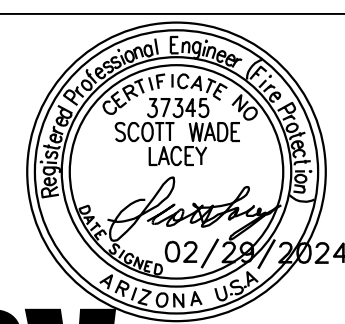

Lacey
Fire Protection
Engineering
WWW.LACEYFPE.COM

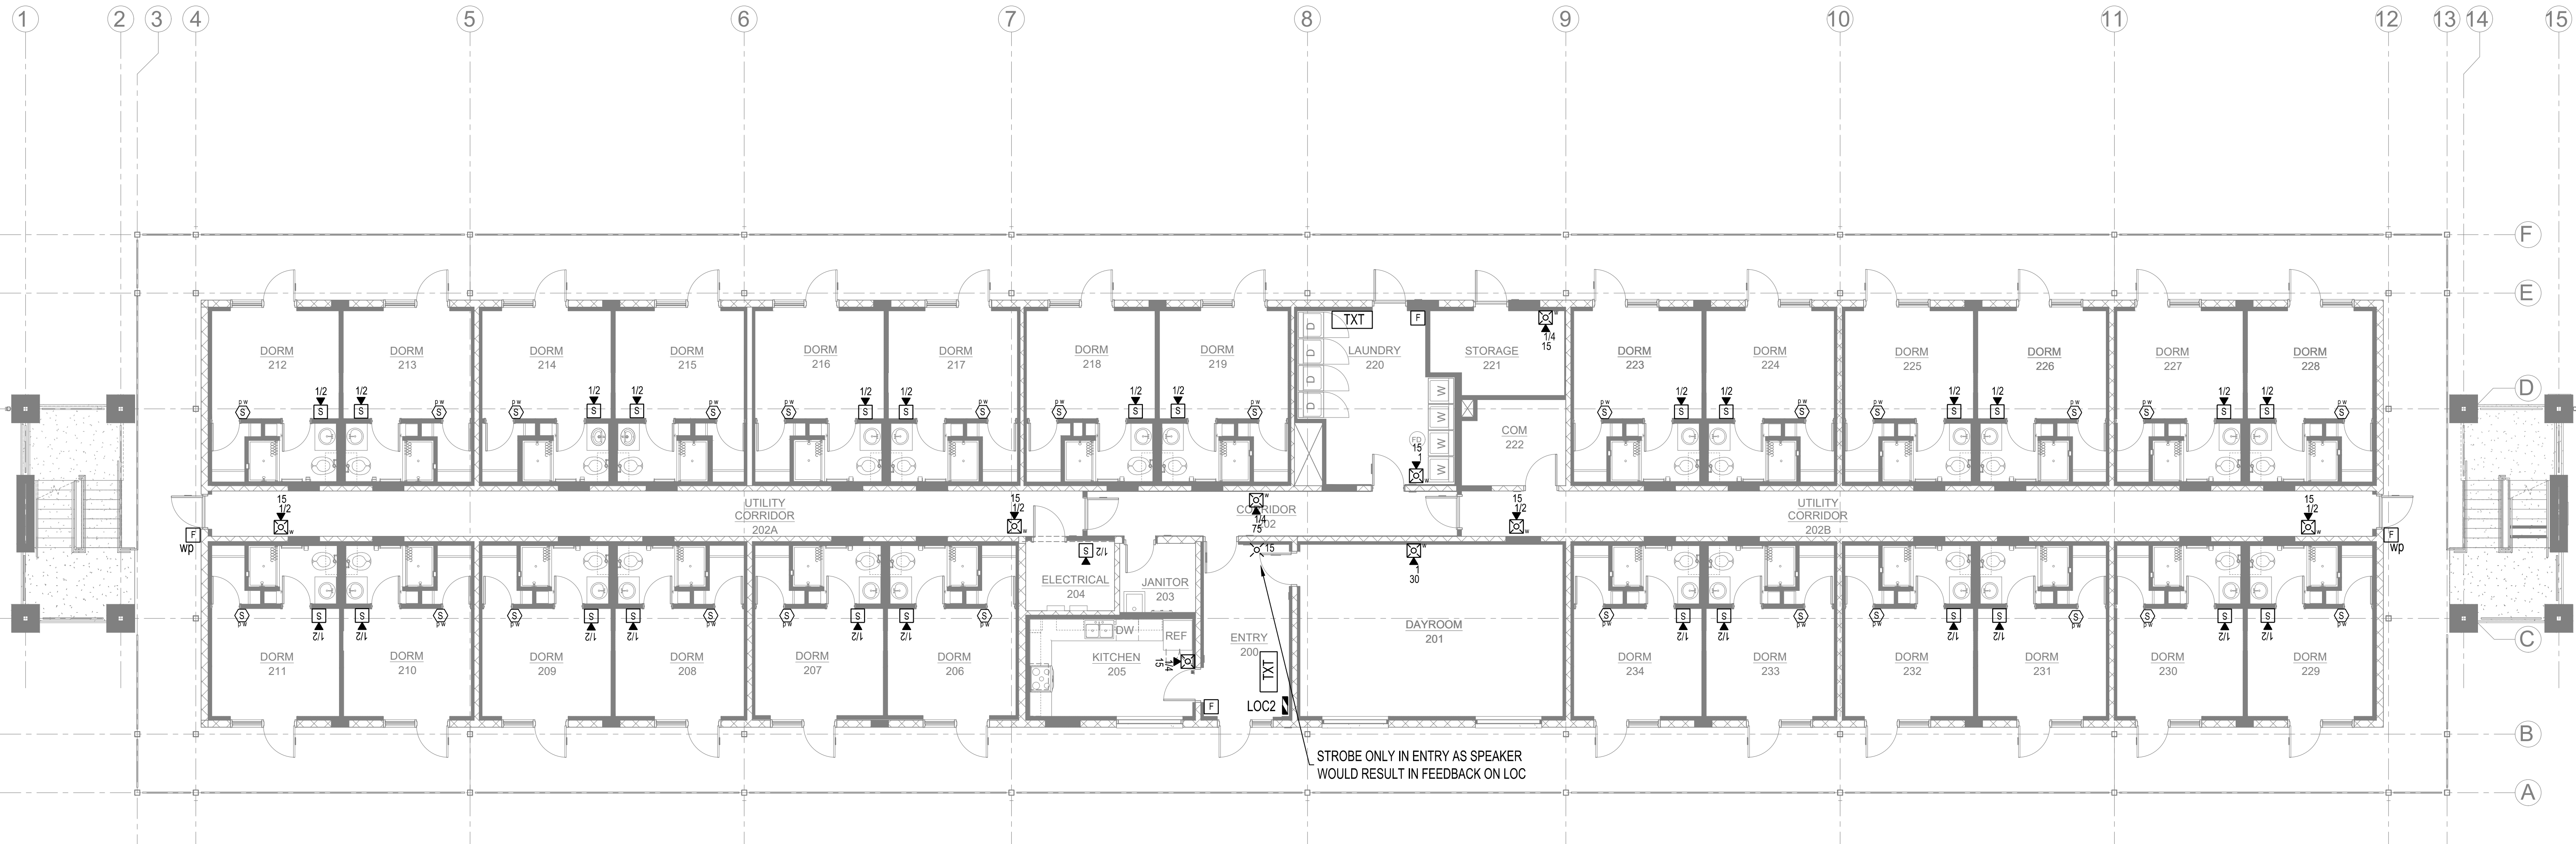

1 FIRE ALARM AND MASS NOTIFICATION - SECOND FLOOR
1/8" = 1'

NORTH

No.	Revision/Issue	Date	BY	APP'D
1	100 REVISED SUBMITAL	04/26/2024		

PROJECT TITLE REPAIR (SUS) AIRMEN DORMITORY BLDG 854		SHEET TITLE FIRE ALARM & MNS - SECOND FLOOR PLAN	
DRAWN BY SL	LEAD DESIGNER SL	PROJECT NUMBER NKAK 21-1034	
TECH REVIEWER SL	DESIGNED BY SL	SHEET	
DATE 29 FEB. 2024		FA1.02	
SCALE AS NOTED		60 OF 100	