



LITTLE ROCK A.F.B.  
ARKANSAS



**CLEMENTS  
& ASSOCIATES**  
ARCHITECTURE, INC.  
507 MAIN STREET  
NORTH LITTLE ROCK, ARKANSAS 72114  
PHONE: 501-373-3380  
WWW.CLEMENTSARCHITECTS.COM



**Lacey**  
Fire Protection  
Engineering  
WWW.LACEYFPE.COM

| No. | Revision/Issue       | Date       | BY | APP'D |
|-----|----------------------|------------|----|-------|
| 1   | 100 REVISED SUBMITAL | 04/26/2024 |    |       |

PROJECT TITLE  
REPAIR (SUS) AIRMEN  
DORMITORY BLDG 854

 
SHEET TITLE  
FIRE SPRINKLER -  
FIRST FLOOR PLAN

|                      |                                |
|----------------------|--------------------------------|
| DRAWN BY<br>SL       | LEAD DESIGNER<br>SL            |
| TECH REVIEWER<br>SL  | PROJECT NUMBER<br>NKAK 21-1034 |
| DESIGNED BY<br>SL    | SHEET<br>FS1.01                |
| DATE<br>29 FEB. 2024 |                                |
| SCALE<br>AS NOTED    | 63 OF 100                      |

**SPRINKLER DENSITY:**



LIGHT HAZARD - 1.0 / 1,500 FT2 WITH 250 GPM HOSE.  
QUICK RESPONSE HEADS.




RESIDENTIAL NFPA 13, 4-HEAD, BATHROOMS <55 FT2  
NOT SPRINKLERED, RESIDENTIAL HEADS, SIDEWALL  
AND PENDANT.



ORDINARY HAZARD - 2.0 / 2,500 OR ROOM / AREA  
RATED MINIMUM 1-HR. QUICK RESPONSE.

COMBUSTIBLE MATERIALS / CONSTRUCTION ARE TO  
BE REMOVED FROM ATTIC SO THAT NO ATTIC  
SPRINKLERS ARE BEING PROVIDED.

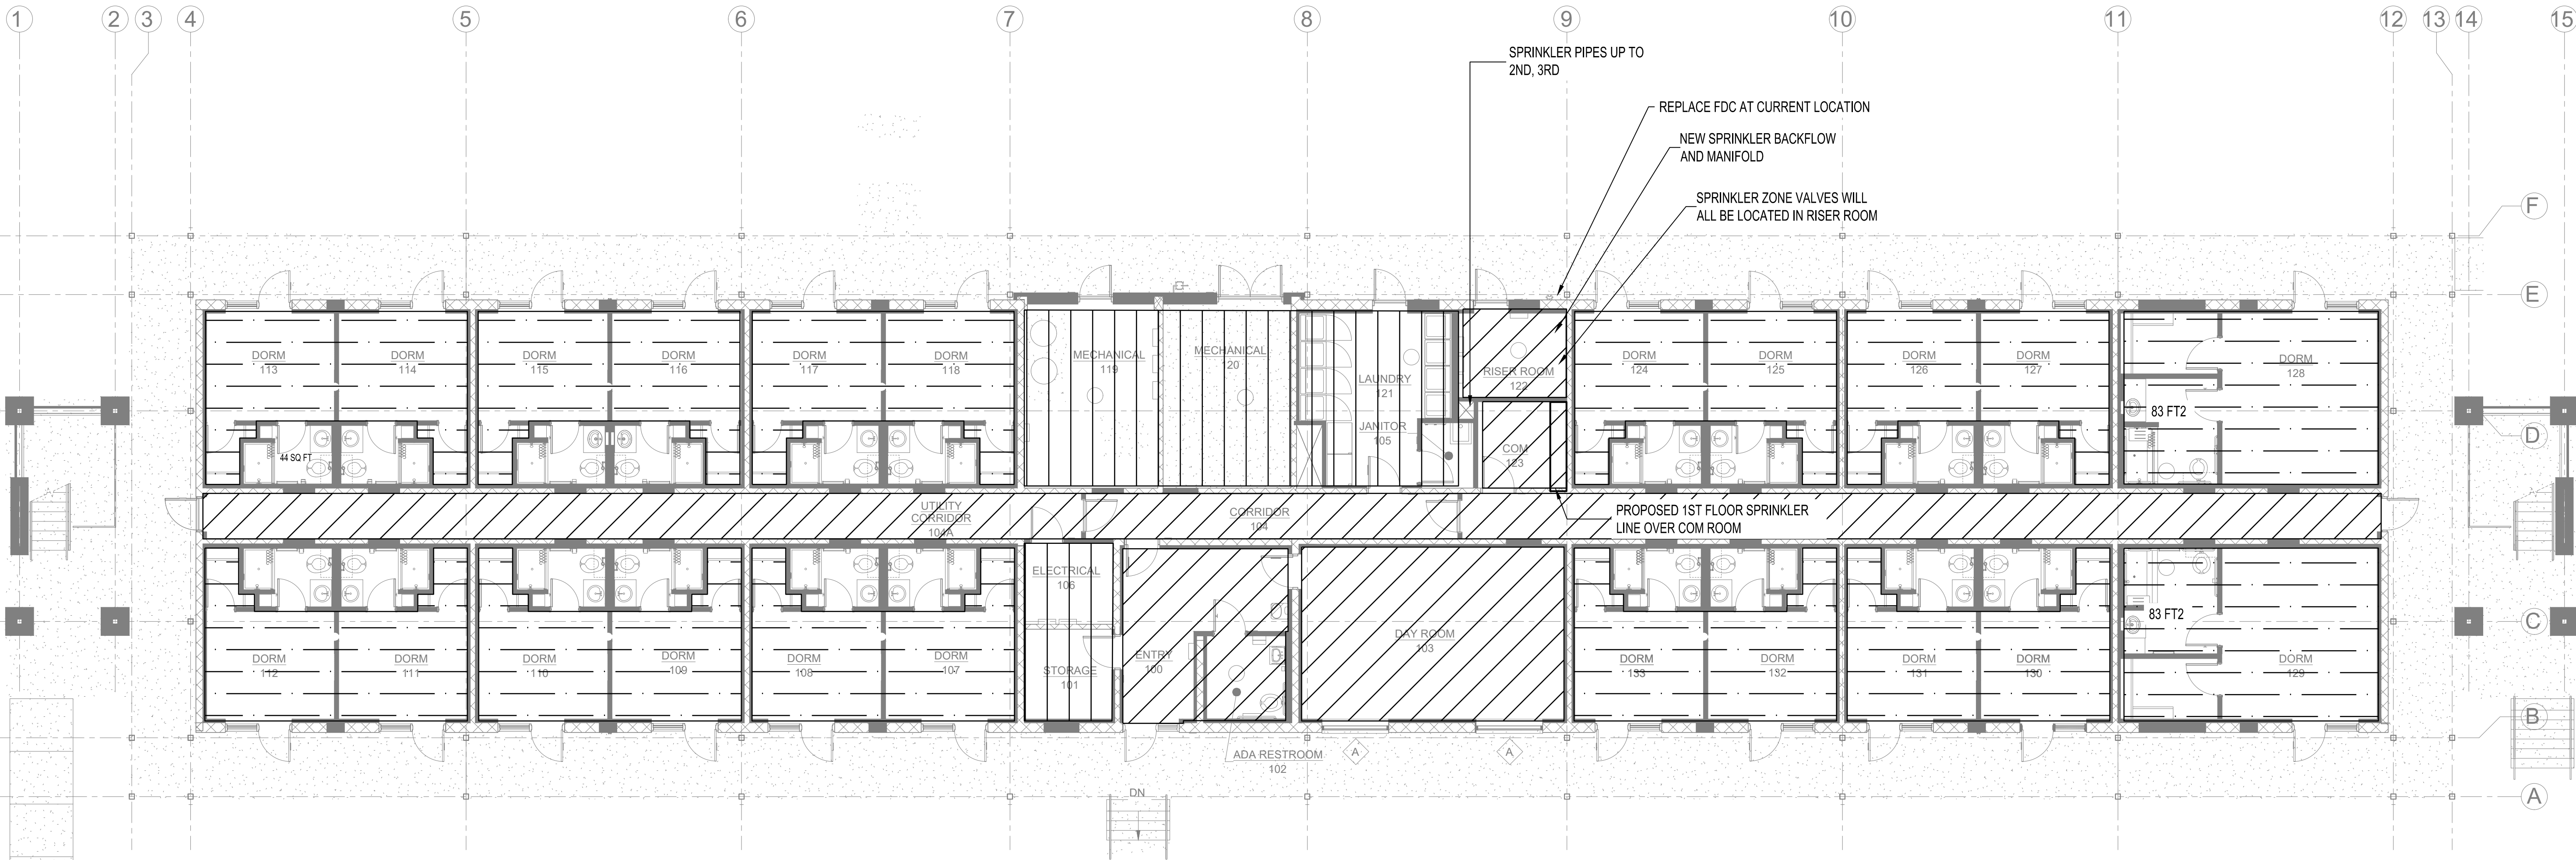

1 FIRE SPRINKLER - FIRST FLOOR  
1/8" = 1'

