



LITTLE ROCK A.F.B.  
ARKANSAS



**CLEMENTS & ASSOCIATES**  
ARCHITECTURE, INC.  
507 MAIN STREET  
NORTH LITTLE ROCK, ARKANSAS 72114  
PHONE: 501-373-3380  
WWW.CLEMENTSARCHITECTS.COM




**Lacey**  
Fire Protection  
Engineering  
WWW.LACEYFPE.COM

| No. | Revision/Issue       | Date       | BY | APP'D |
|-----|----------------------|------------|----|-------|
| 1   | 100 REVISED SUBMITAL | 04/26/2024 |    |       |

PROJECT TITLE  
REPAIR (SUS) AIRMEN  
DORMITORY BLDG 854

SHEET TITLE  
FIRE SPRINKLER -  
SECOND FLOOR PLAN

|                      |                                |
|----------------------|--------------------------------|
| DRAWN BY<br>SL       | LEAD DESIGNER<br>SL            |
| TECH REVIEWER<br>SL  | PROJECT NUMBER<br>NKAK 21-1034 |
| DESIGNED BY<br>SL    | SHEET<br>FS1.02                |
| DATE<br>29 FEB. 2024 |                                |
| SCALE<br>AS NOTED    | 64 OF 100                      |

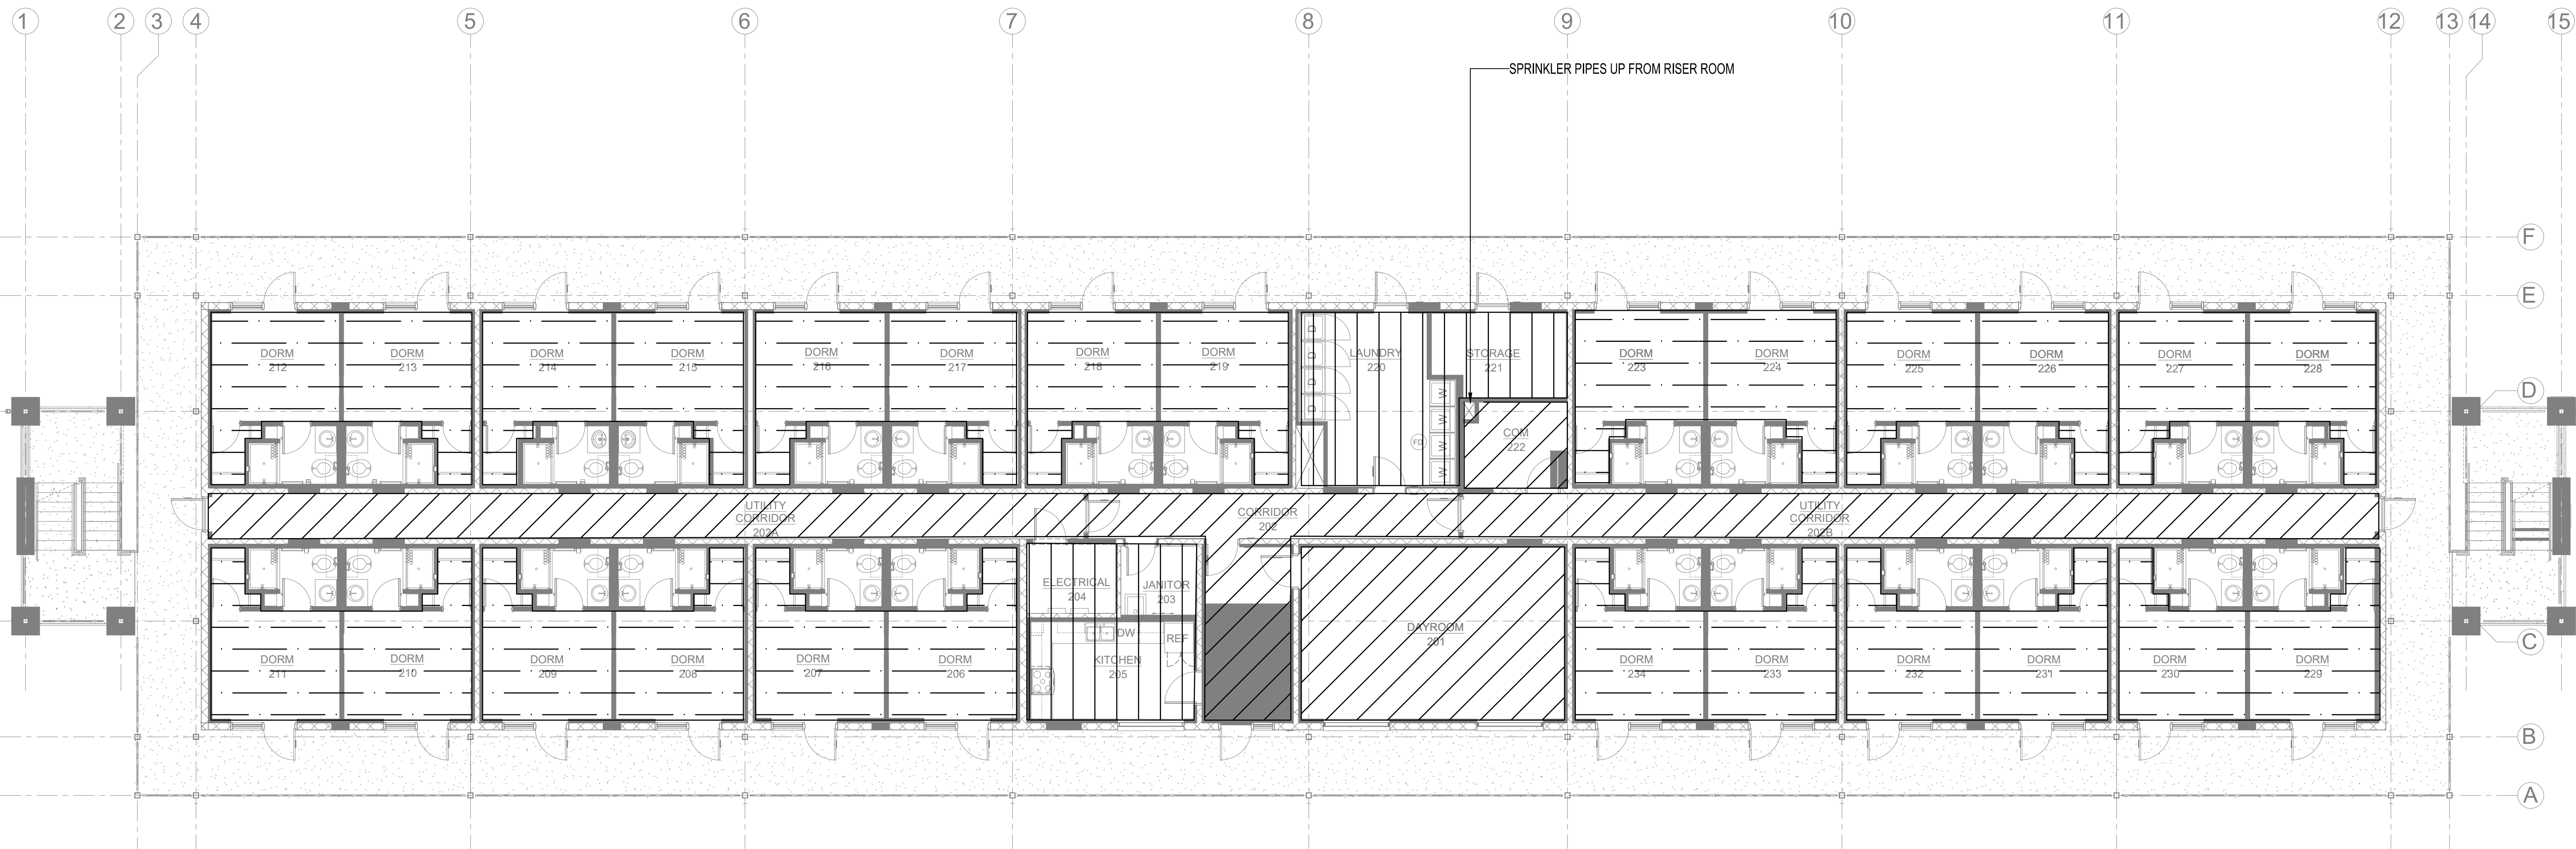

1 FIRE SPRINKLER - SECOND FLOOR  
1/8" = 1'

