





LITTLE ROCK A.F.B.
ARKANSAS



**CLEMENTS
& ASSOCIATES**
ARCHITECTURE, INC.
507 MAIN STREET
NORTH LITTLE ROCK, ARKANSAS 72114
PHONE: 501-373-3380
WWW.CLEMENTSARCHITECTS.COM

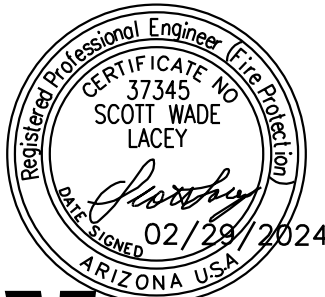

Lacey
Fire Protection
Engineering
WWW.LACEYFPE.COM

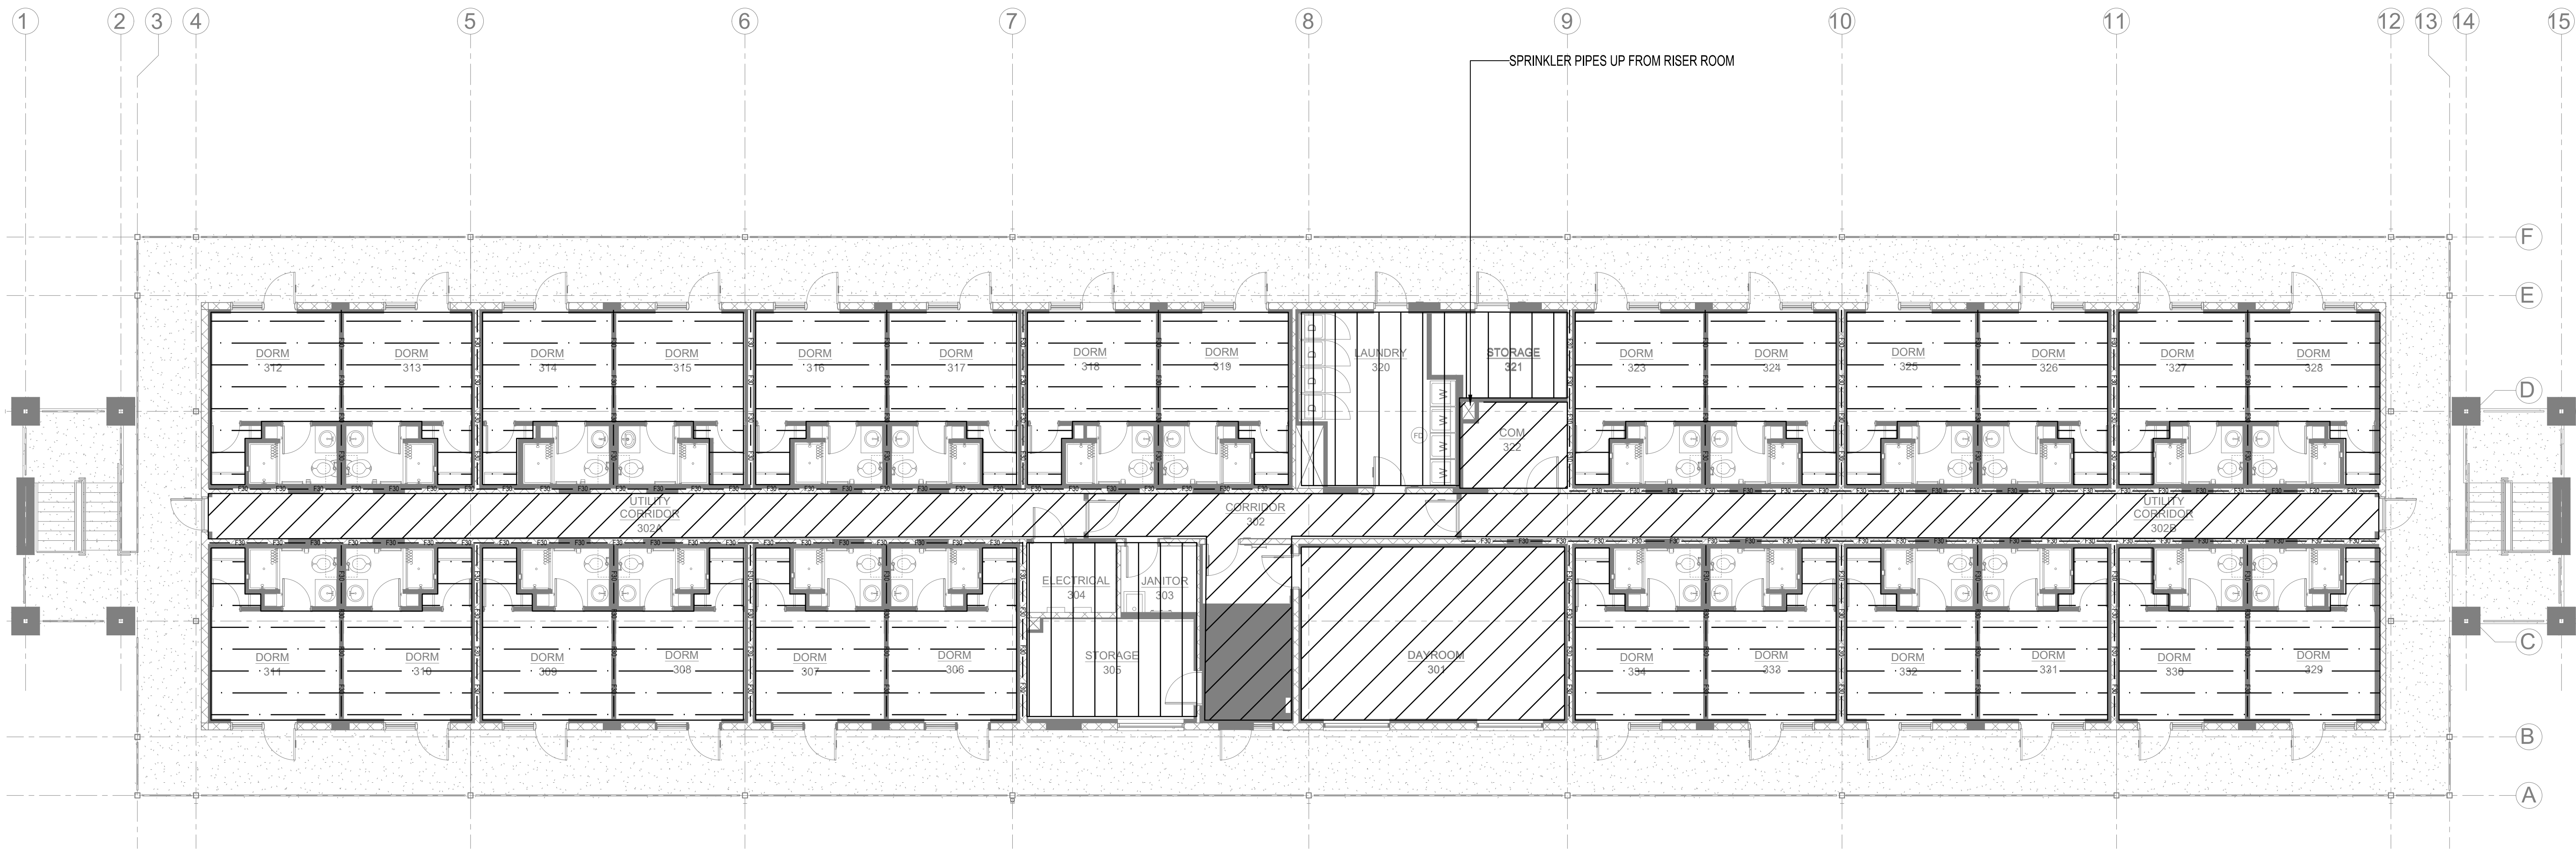

1 FIRE SPRINKLER - THIRD FLOOR
1/8" = 1'



PROJECT TITLE REPAIR (SUS) AIRMEN DORMITORY BLDG 854		SHEET TITLE FIRE SPRINKLER - THIRD FLOOR PLAN	
DRAWN BY SL	LEAD DESIGNER SL	PROJECT NUMBER NKAK 21-1034	
TECH REVIEWER SL	DESIGNED BY SL	SHEET FS1.03	
DATE 29 FEB. 2024	SCALE AS NOTED		
			65 OF 100