
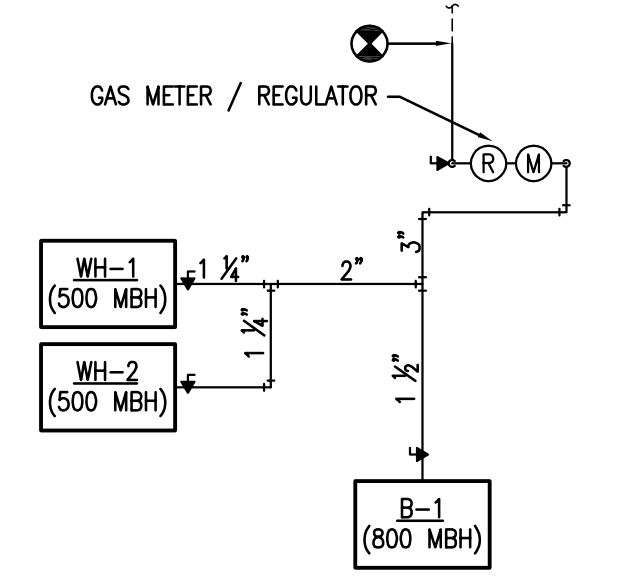


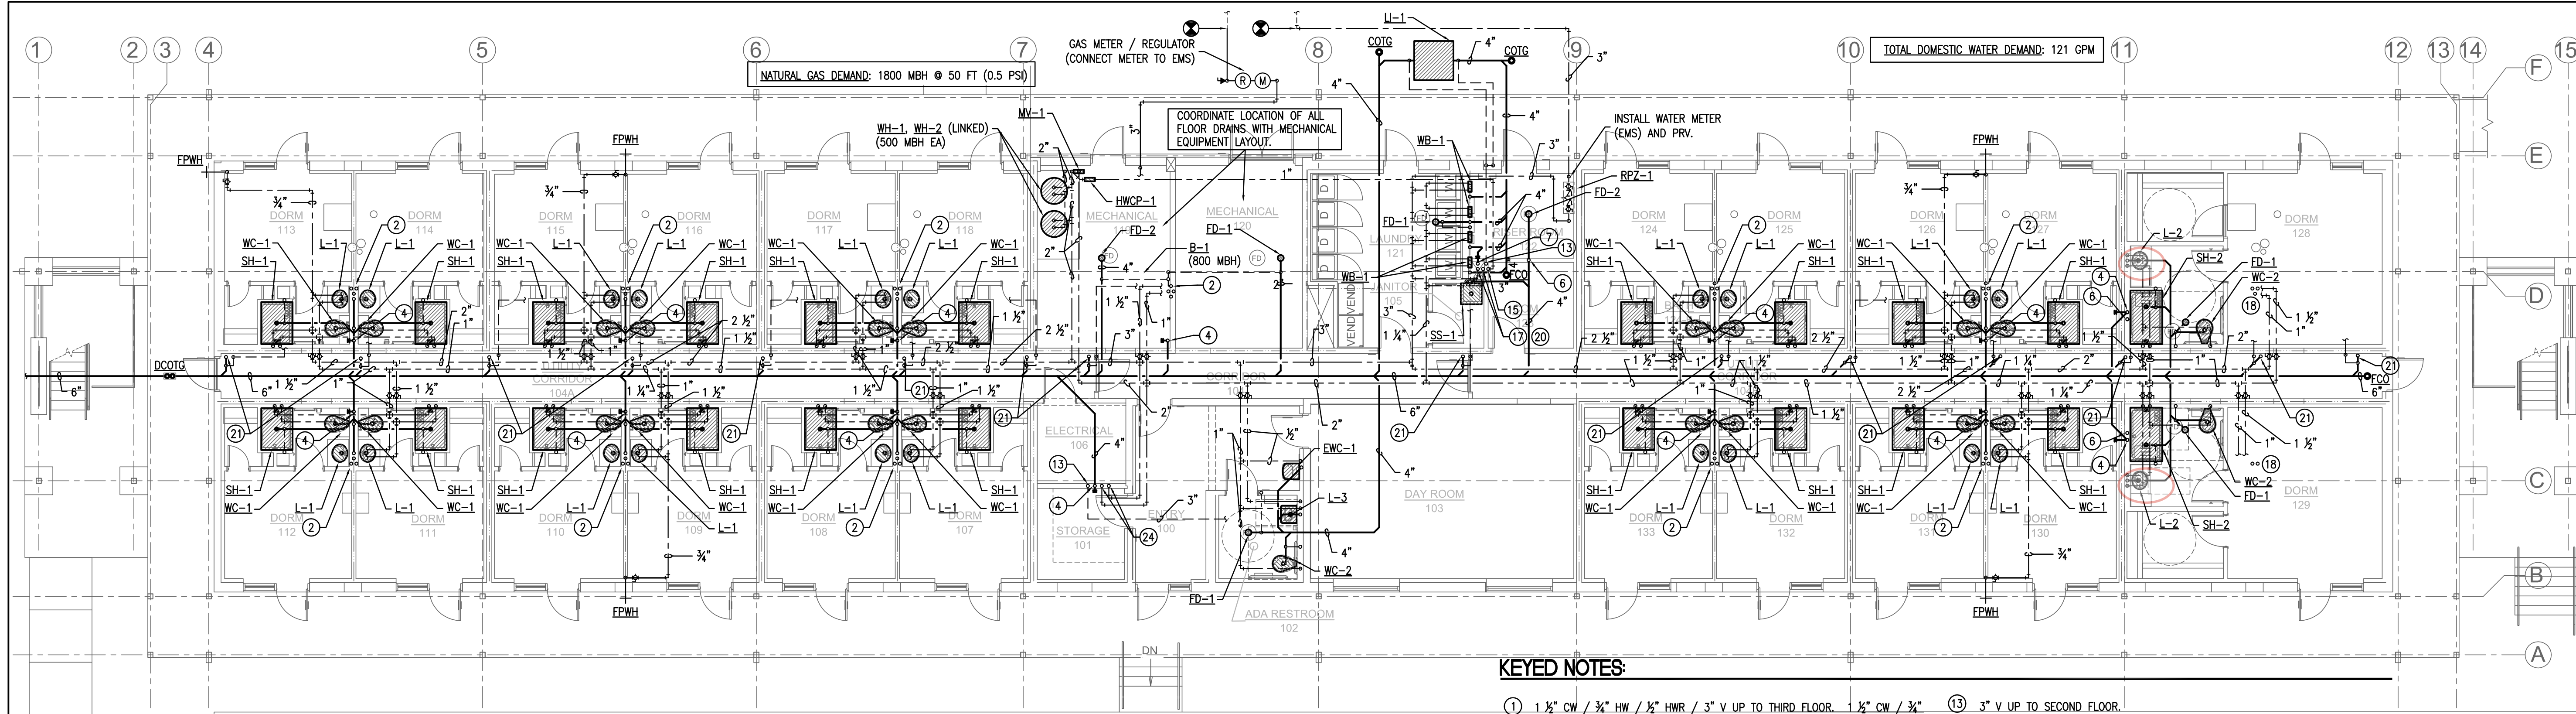


REFER TO PLUMBING RISERS AND SCHEDULE FOR ADDITIONAL INFORMATION FOR ROUTING AND PIPE SIZING

GENERAL NOTES
THE FOLLOWING MATERIALS SHALL BE USED.
A. BELOW-GRADE SUPPLY: COPPER OR PVC
B. ABOVE-GRADE SUPPLY: COPPER
C. ABOVE-GRADE DWV: NO-HUB CAST IRON
D. BELOW-GRADE DWV: CAST IRON OR PVC

1 PLUMBING PLAN - FIRST FLOOR
SCALE: 1/8" = 1'-0"



KEYED NOTES:

- 1 1 1/2" CW / 3/4" HW / 1/2" HWR / 3" V UP TO THIRD FLOOR. 1 1/2" CW / 3/4" HW / 1/2" HWR / 3" V DOWN TO FIRST FLOOR.
- 2 1 1/2" CW / 1" HW / 3" V UP TO SECOND FLOOR.
- 3 4" SS FROM THIRD FLOOR. 4" SS DOWN TO FIRST FLOOR.
- 4 4" SS FROM SECOND FLOOR. PROVIDE WCO 18" AFF AT BOTTOM OF STACK.
- 5 2" V FROM THIRD FLOOR. 2" V DOWN TO FIRST FLOOR.
- 6 2" V FROM SECOND FLOOR.
- 7 4" SS FROM THIRD FLOOR. PROVIDE WCO 18" AFF AT BOTTOM OF STACK.
- 8 4" SS TO FIRST FLOOR. 2" V DOWN TO FIRST FLOOR. 2" V FROM THIRD FLOOR.
- 9 3" SS FROM THIRD FLOOR. PROVIDE WCO 18" AFF AT BOTTOM OF STACK.
- 10 4" SS TO FIRST FLOOR. 2" V UP TO THIRD FLOOR.
- 11 3/4" CW / 3/4" HW / 1/2" HWR UP TO THIRD FLOOR. 3/4" CW / 3/4" HW / 1/2" HWR DOWN TO FIRST FLOOR.
- 12 3" V FROM THIRD FLOOR. 3" V DOWN TO FIRST FLOOR.
- 13 3" V UP TO SECOND FLOOR.
- 14 1" HWR FROM THIRD FLOOR. 1" HWR DOWN TO FIRST FLOOR.
- 15 1" HWR FROM SECOND FLOOR.
- 16 1" CW / 1" HW FROM THIRD FLOOR. ROUTE 1/2" CW/HW TO EACH WASHER BOX.
- 17 1 1/4" CW / 1 1/4" HW FROM SECOND FLOOR.
- 18 3/4" CW / 3/4" HW FROM SECOND FLOOR.
- 19 2" V FROM THIRD FLOOR TO FIRST FLOOR.
- 20 COORDINATE ROUTING AND INSTALLATION OF PIPING IN CHASE WITH DUCTWORK AND MECHANICAL EQUIPMENT SHARING THE CHASE.
- 21 HD-1, INSTALLED IN SLAB FOR MECHANICAL EQUIPMENT DRAINAGE. COORDINATE LOCATION WITH MECHANICAL EQUIPMENT NEARBY.
- 22 3" SS FROM THIRD FLOOR. 4" SS TO FIRST FLOOR.
- 23 3/4" CW/HW FROM THIRD FLOOR. 1" CW/HW DOWN TO FIRST FLOOR.
- 24 1" CW/HW FROM SECOND FLOOR.

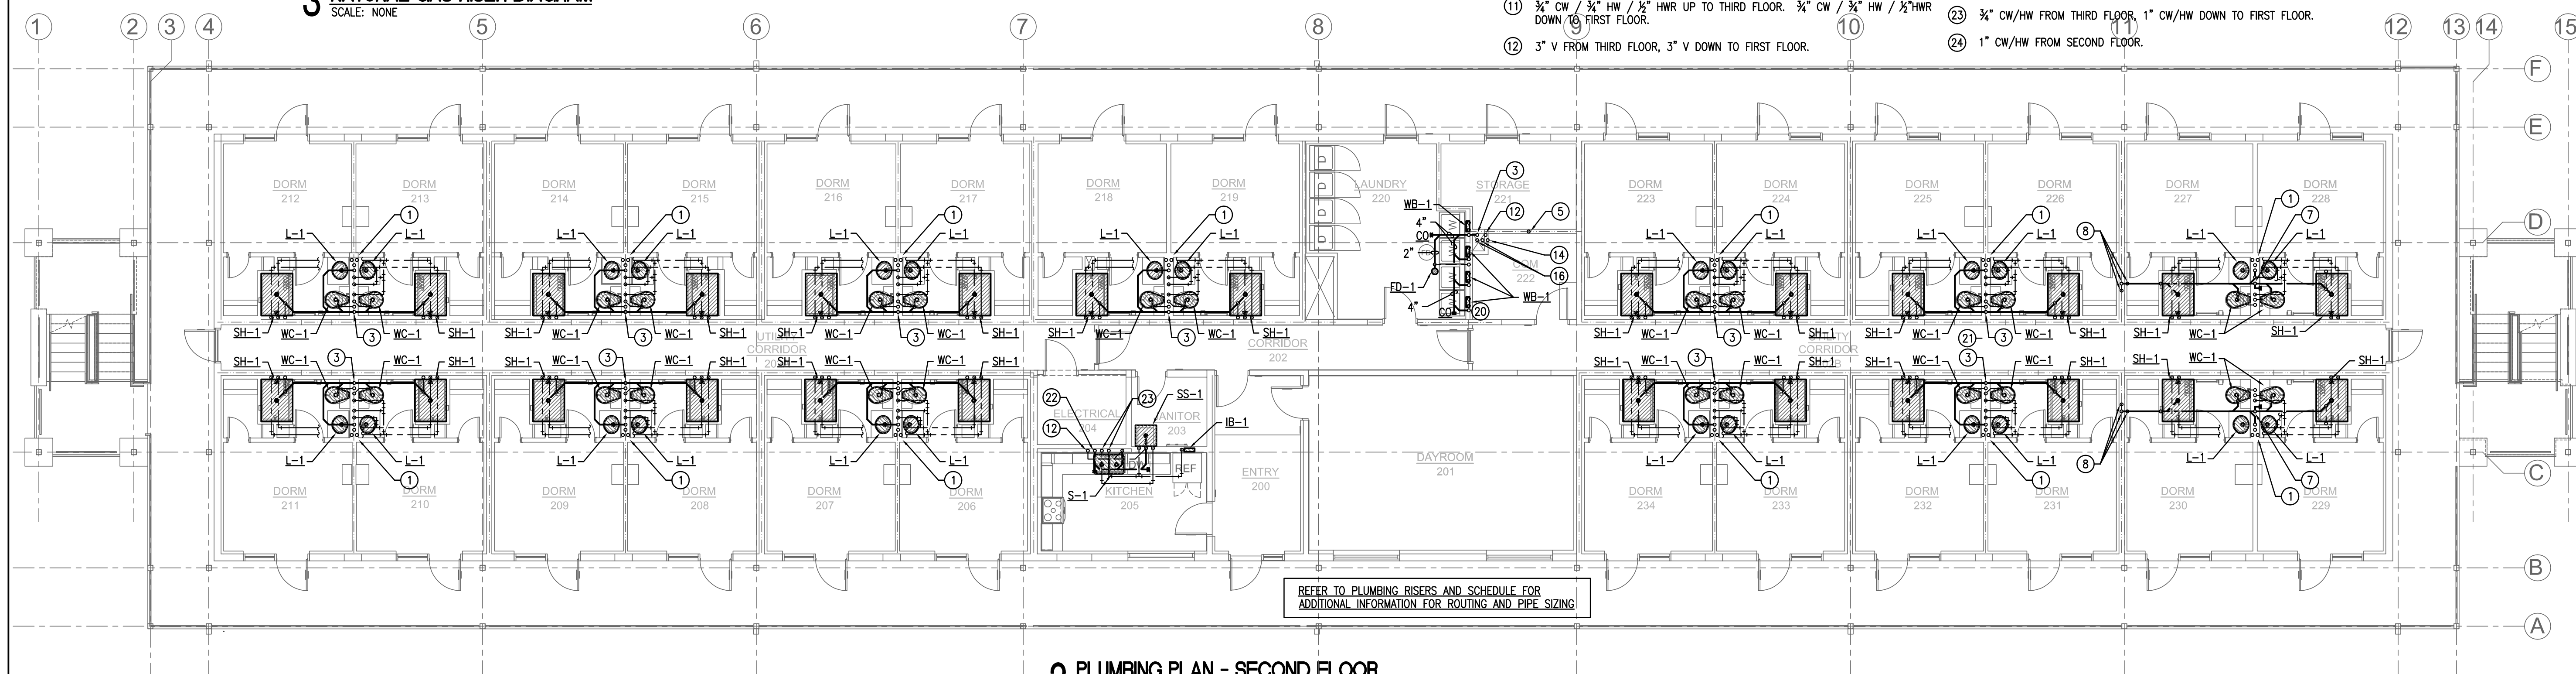

REFER TO PLUMBING RISERS AND SCHEDULE FOR ADDITIONAL INFORMATION FOR ROUTING AND PIPE SIZING

2 PLUMBING PLAN - SECOND FLOOR
SCALE: 1/8" = 1'-0"

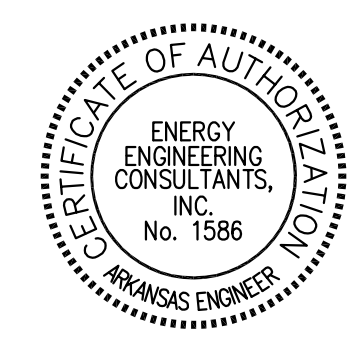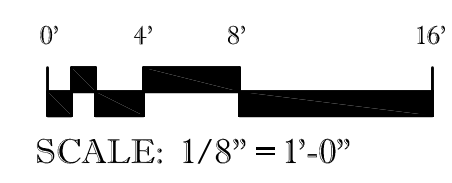

EECI
ENERGY ENGINEERING
CONSULTANTS, INC.
10 CORPORATE HILL DR., STE. 100 PH: (501) 244-0511
LITTLE ROCK, AR 72205 FX: (501) 244-0241



LITTLE ROCK A.F.B.
ARKANSAS



CLEMENTS & ASSOCIATES
ARCHITECTURE, INC.
507 MAIN STREET
NORTH LITTLE ROCK, ARKANSAS 72114
PHONE: 501-975-3380
WWW.CLEMENTSARCHITECTS.COM



No.	Revision/Issue	Date	By	App'd

REPAIR (SUS) AIRMEN
DORMITORY BLDG 854

PLUMBING PLAN

DESIGNED BY	GC
CHECKED BY	GC
DATE	29 FEB. 2024
PROJECT	AS NOTED
SHEET	P2.01
OF	68 OF 100