


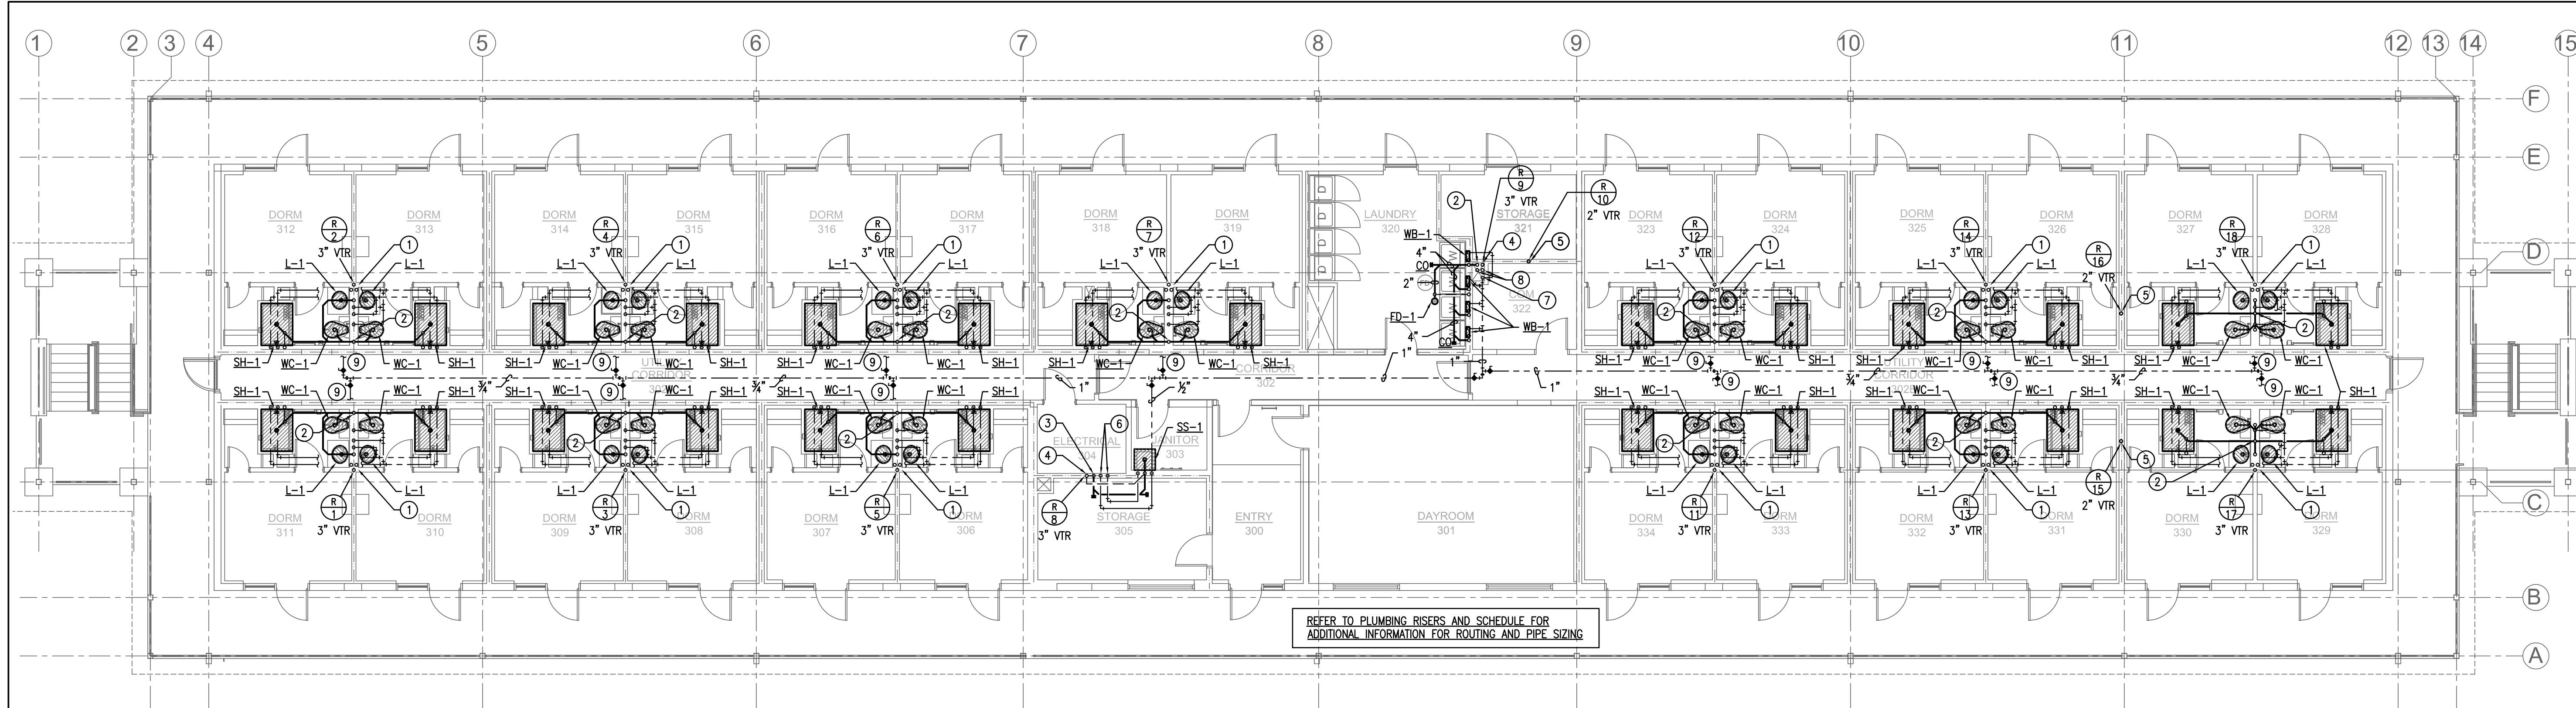

1 PLUMBING PLAN - THIRD FLOOR
SCALE: 1/8" = 1'-0"

REFER TO PLUMBING RISERS AND SCHEDULE FOR
ADDITIONAL INFORMATION FOR ROUTING AND PIPE SIZING



KEYED NOTES:

- 1 1/2" CW / 3/4" HW / 1/2" HWR / 3" V DOWN TO SECOND FLOOR.
- 2 4" SS DOWN TO SECOND FLOOR.
- 3 3" SS DOWN TO SECOND FLOOR.
- 4 3" V DOWN TO SECOND FLOOR.
- 5 2" V DOWN TO SECOND FLOOR.
- 6 3/4" CW / 3/4" HW DOWN TO SECOND FLOOR.
- 7 1" HWR DOWN TO SECOND FLOOR.
- 8 1" CW / 1" HW DOWN TO SECOND FLOOR. ROUTE 1/2" CW/HW TO EACH WASHER BOX.
- 9 1/2" HWR ROUTED TO THE TOP OF THE THIRD FLOOR HW PIPING. CONNECT FOR RECIRCULATION OF STACK.

GENERAL NOTES

THE FOLLOWING MATERIALS SHALL BE USED.

- A. BELOW-GRADE SUPPLY: COPPER OR PVC
- B. ABOVE-GRADE SUPPLY: COPPER
- C. ABOVE-GRADE DWV: NO-HUB CAST IRON
- D. BELOW-GRADE DWV: CAST IRON OR PVC

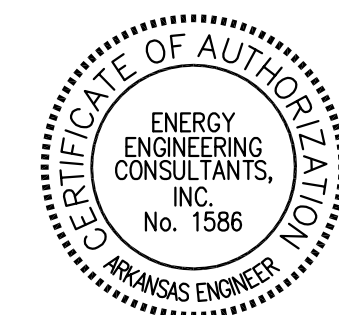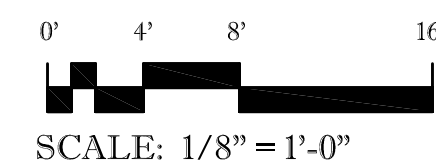

LITTLE ROCK A.F.B.
ARKANSAS

HGL
Construction

CLEMENTS & ASSOCIATES
ARCHITECTURE, INC.
507 MAIN STREET
NORTH LITTLE ROCK, ARKANSAS 72114
PHONE: 501-975-3380
WWW.CLEMENTSARCHITECTS.COM



									APPD
									BY
									Date
									Revision/Issue
									No.

REPAIR (SUS) AIRMEN
DORMITORY BLDG 854

PLUMBING PLAN

DESIGNED BY HS, BD	PLAN DEVELOPER GC
DATE 29 FEB. 2024	PROJECT NUMBER NKAK 21-1034
AS NOTED	SHEET P2.02
	69 OF 100