



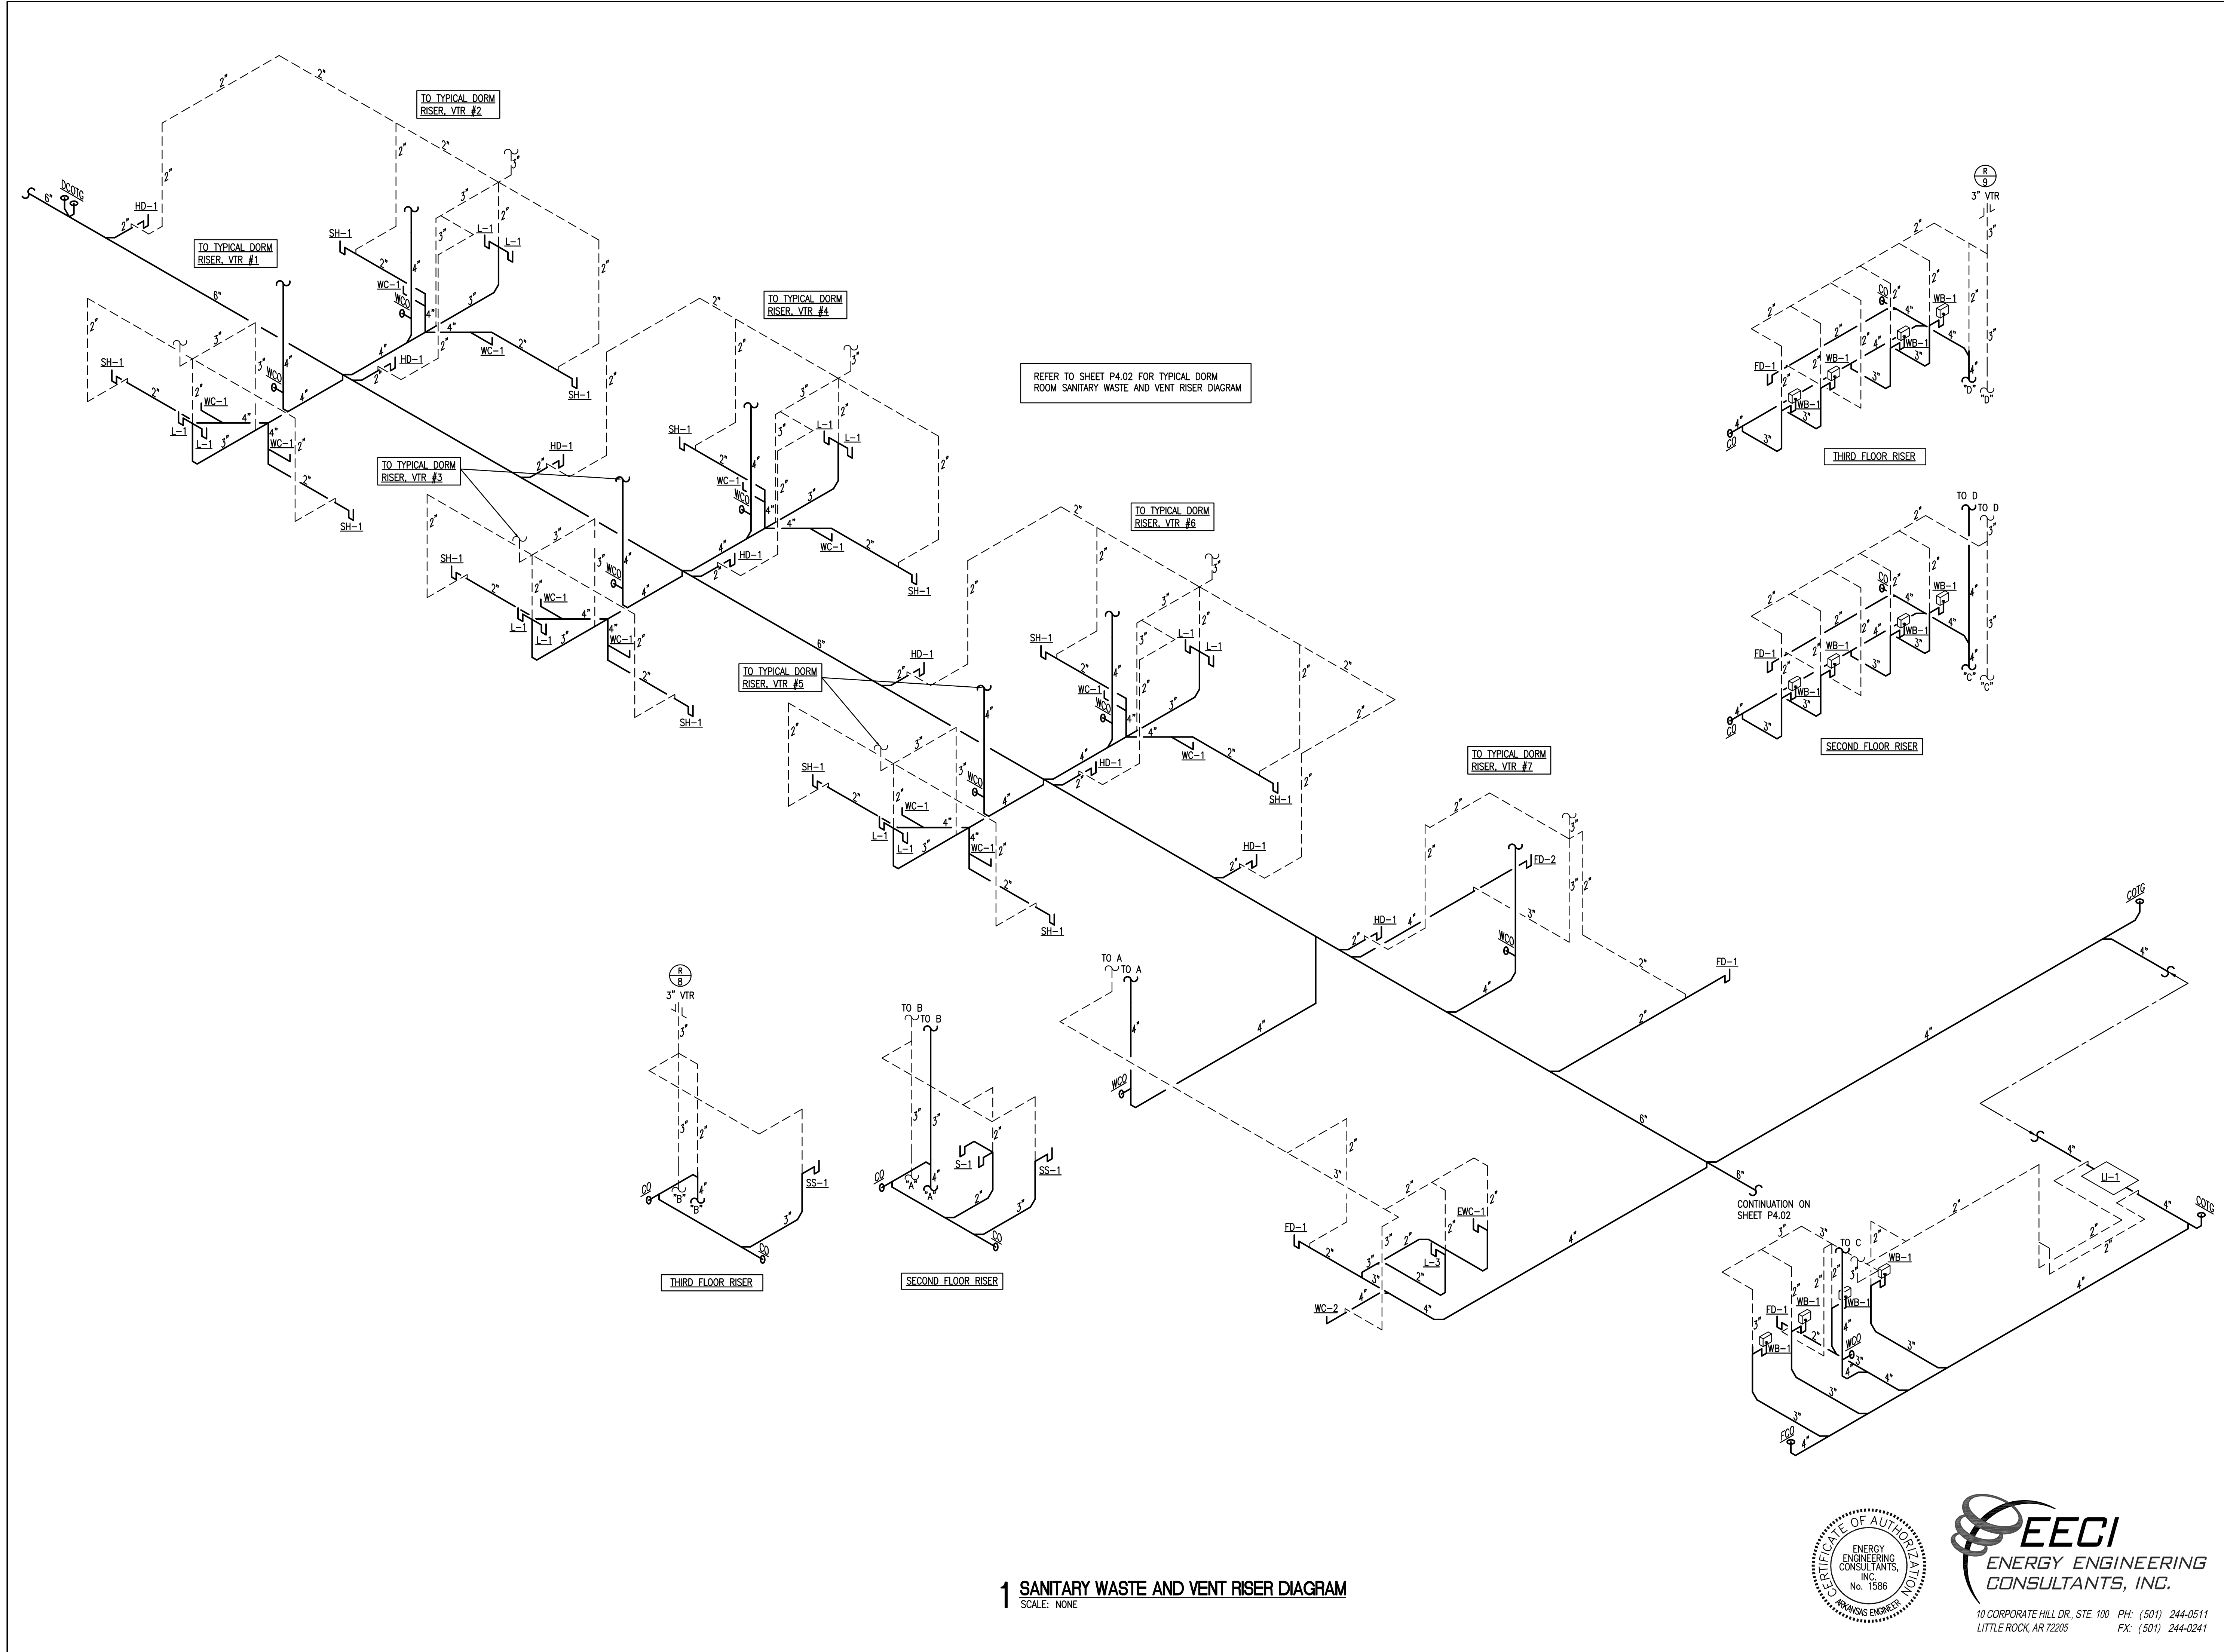

1 SANITARY WASTE AND VENT RISER DIAGRAM
SCALE: NONE

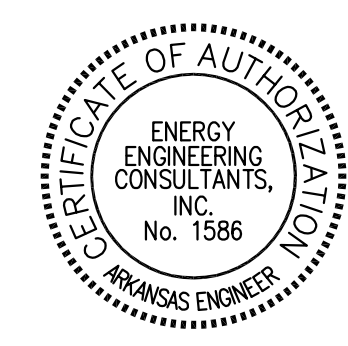

EECI
ENERGY ENGINEERING
CONSULTANTS, INC.

10 CORPORATE HILL DR., STE. 100 PH: (501) 244-0511
LITTLE ROCK, AR 72205 FX: (501) 244-0241

LITTLE ROCK A.F.B.
ARKANSAS

HGL
Construction

CLEMENTS & ASSOCIATES
ARCHITECTURE, INC.
507 MAIN STREET
NORTH LITTLE ROCK, ARKANSAS 72114
PHONE: 501-975-3380
WWW.CLEMENTSARCHITECTS.COM

STATE OF ARKANSAS
REGISTERED PROFESSIONAL ARCHITECT
NOAH D. KINDER
No. 13307
2-29-24

No.	Revision/Issue	Date	By	APP'D

PROJECT TITLE: REPAIR (SUS) ARMEN DORMITORY BLDG 854

PLUMBING RISERS

DESIGNED BY: HS, BD	PLUMBING RISERS
DRAWN BY: HS	GC
CHECKED BY: GC	NCAK 21-1034
DATE: 29 FEB. 2024	SHEET: P4.01
AS NOTED	71 OF 100