


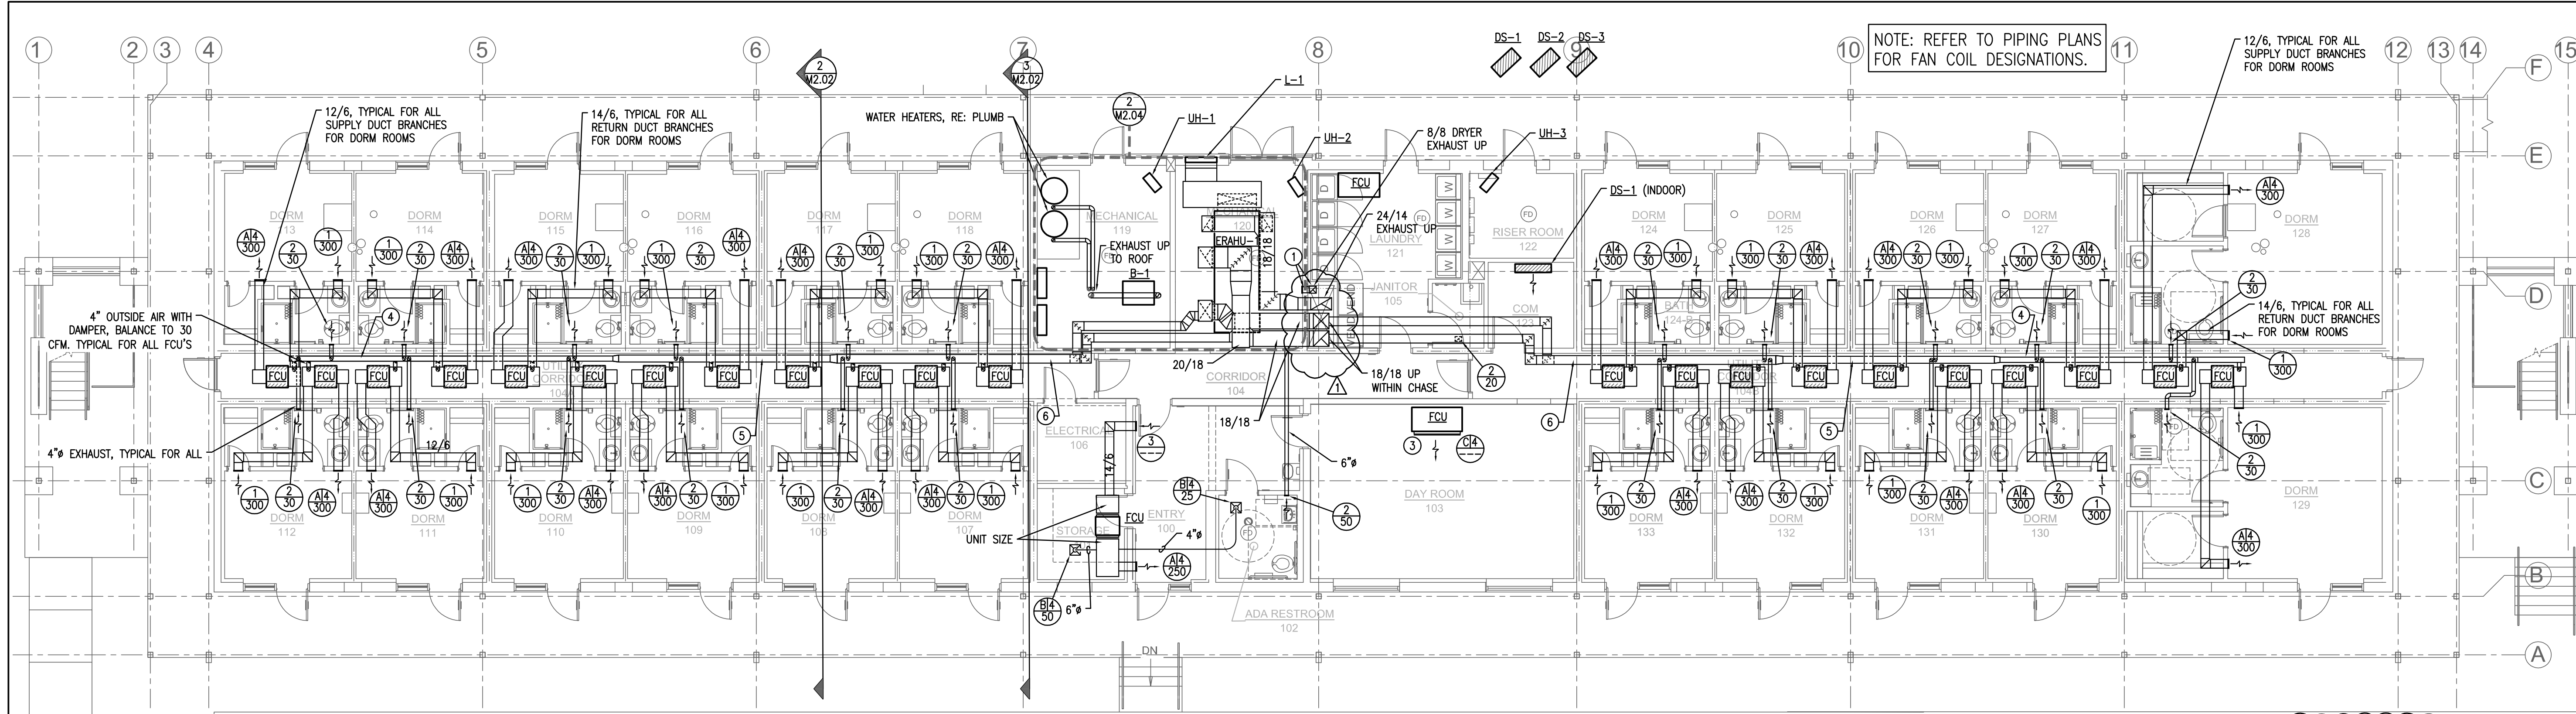


1 MECHANICAL PLAN - FIRST FLOOR
SCALE: 1/8" = 1'-0"

KEYED NOTES:


- 1 EXHAUST DUCT TO EXTEND TO 12" AFF. ROUTE FOUR 4" EXHAUST DUCTS TO DRYERS WITH LOWEST CONNECTION OF 24". PROVIDE 8/8 TO MECHANICAL ROOM WITH ACCESS DOOR FOR LINT REMOVAL.
- 2 ROUTE FOUR 4" EXHAUST DUCTS TO DRYERS.
- 3 EXTEND DISCHARGE DUCT TO NEW GRILLE, SIZE TO EQUAL DIMENSIONS OF FAN COIL UNIT.
- 4 6/6 OUTSIDE AIR DUCT (BOTTOM) AND EXHAUST DUCT (TOP) STACKED. REFER TO SECTION FOR ADDITIONAL INFORMATION.
- 5 8/8 OUTSIDE AIR DUCT (BOTTOM) AND EXHAUST DUCT (TOP) STACKED. REFER TO SECTION FOR ADDITIONAL INFORMATION.
- 6 10/10 OUTSIDE AIR DUCT (BOTTOM) AND EXHAUST DUCT (TOP) STACKED. REFER TO SECTION FOR ADDITIONAL INFORMATION.

NOTE: LABELS HAVE BEEN MOVED
AN MODIFIED FOR CLARITY. ONLY
CLOUDED AREAS HAVE CHANGED.

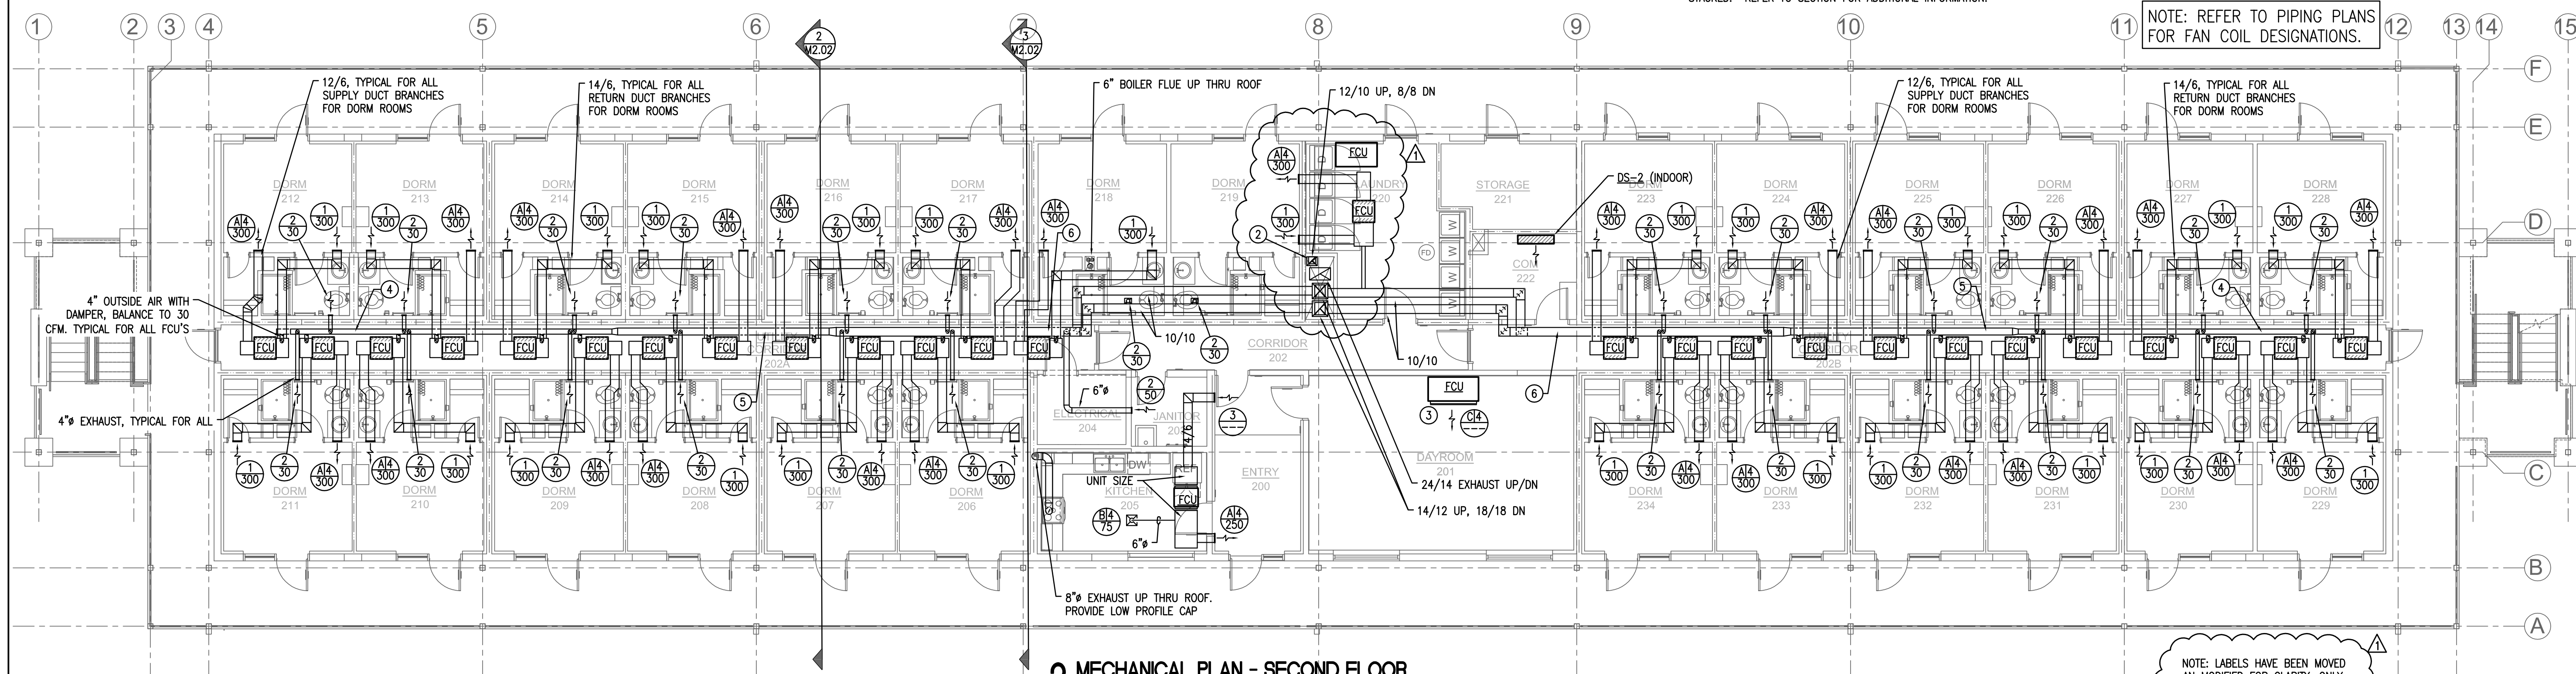

2 MECHANICAL PLAN - SECOND FLOOR
SCALE: 1/8" = 1'-0"

NOTE: LABELS HAVE BEEN MOVED
AN MODIFIED FOR CLARITY. ONLY
CLOUDED AREAS HAVE CHANGED.

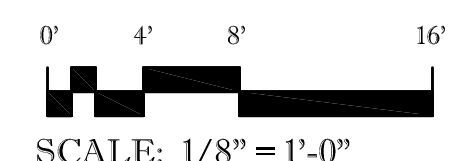

SCALE: 1/8" = 1'-0"



LITTLE ROCK A.F.B.
ARKANSAS



CLEMENTS & ASSOCIATES
ARCHITECTURE, INC.
507 MAIN STREET
NORTH LITTLE ROCK, ARKANSAS 72114
PHONE: 501-975-3380
WWW.CLEMENTSARCHITECTS.COM




DATE	BY	APP'D
4/26/24		
100 REVISED SUBMITTAL		

NO.	REVISION/ISSUE

**REPAIR (SUS) ARMEN
DORMITORY BLDG 854**

MECHANICAL PLAN

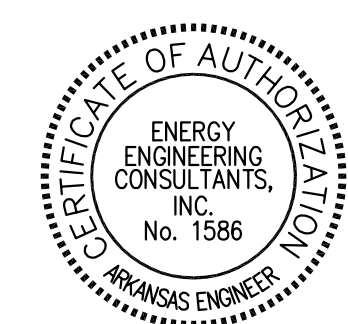

EECI
ENERGY ENGINEERING
CONSULTANTS, INC.

10 CORPORATE HILL DR., STE. 100 PH: (501) 244-0511
LITTLE ROCK, AR 72205 FX: (501) 244-0241

HS, BD	GC
HS	NKAK 21-1034
GC	
DATE	29 FEB. 2024
PROJECT	M2.01
AS NOTED	76 OF 100