



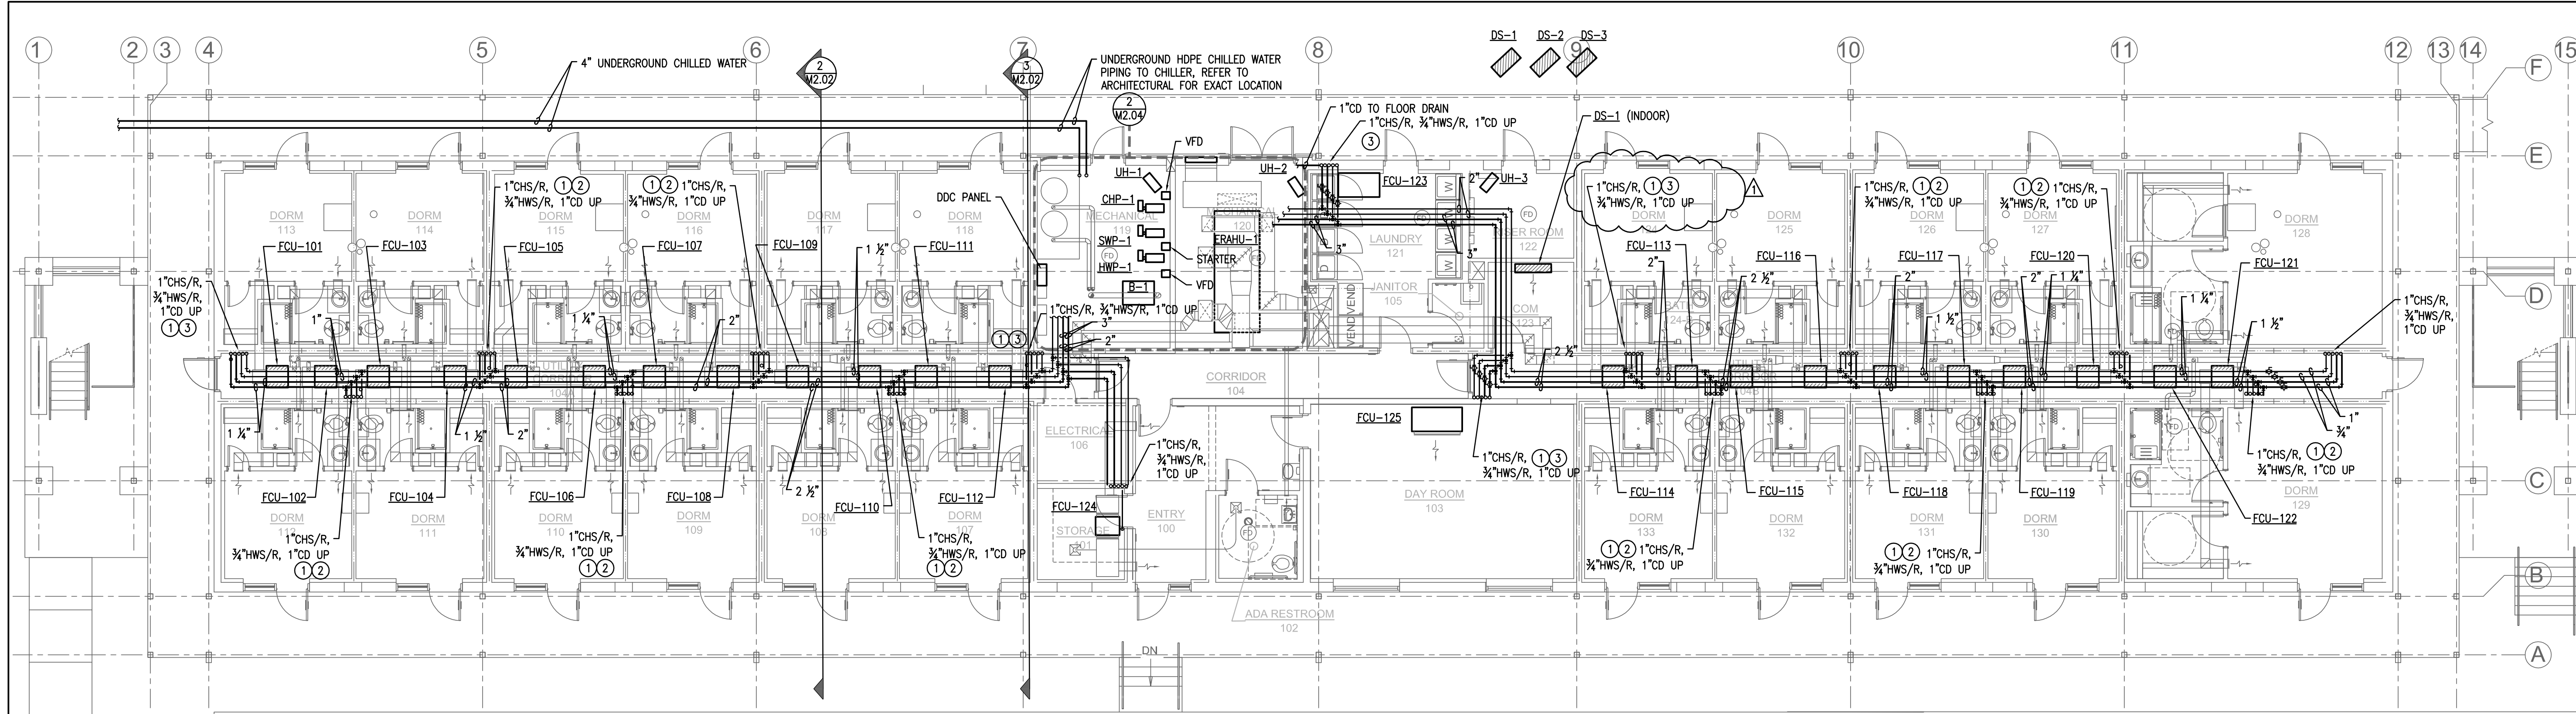

1 MECHANICAL PIPING PLAN - FIRST FLOOR
SCALE: 1/8" = 1'-0"



KEYED NOTES:

- HUB DRAIN, RE: PLUMBING. COMBINE ALL CONDENSATE FROM FLOORS ABOVE AND DISCHARGE TO HUB DRAIN.
- 1" CHS/R BRANCH WITH BALL VALVES, 1" HWS/R BRANCH WITH BALL VALVES. CONNECT 1ST FLOOR FAN COIL UNITS AND ROUTE PIPING TO UPPER FLOORS.
- 1" CHS/R BRANCH WITH BALL VALVES, 3/4" HWS/R BRANCH WITH BALL VALVES. CONNECT 1ST FLOOR FAN COIL UNITS AND ROUTE PIPING TO UPPER FLOORS.

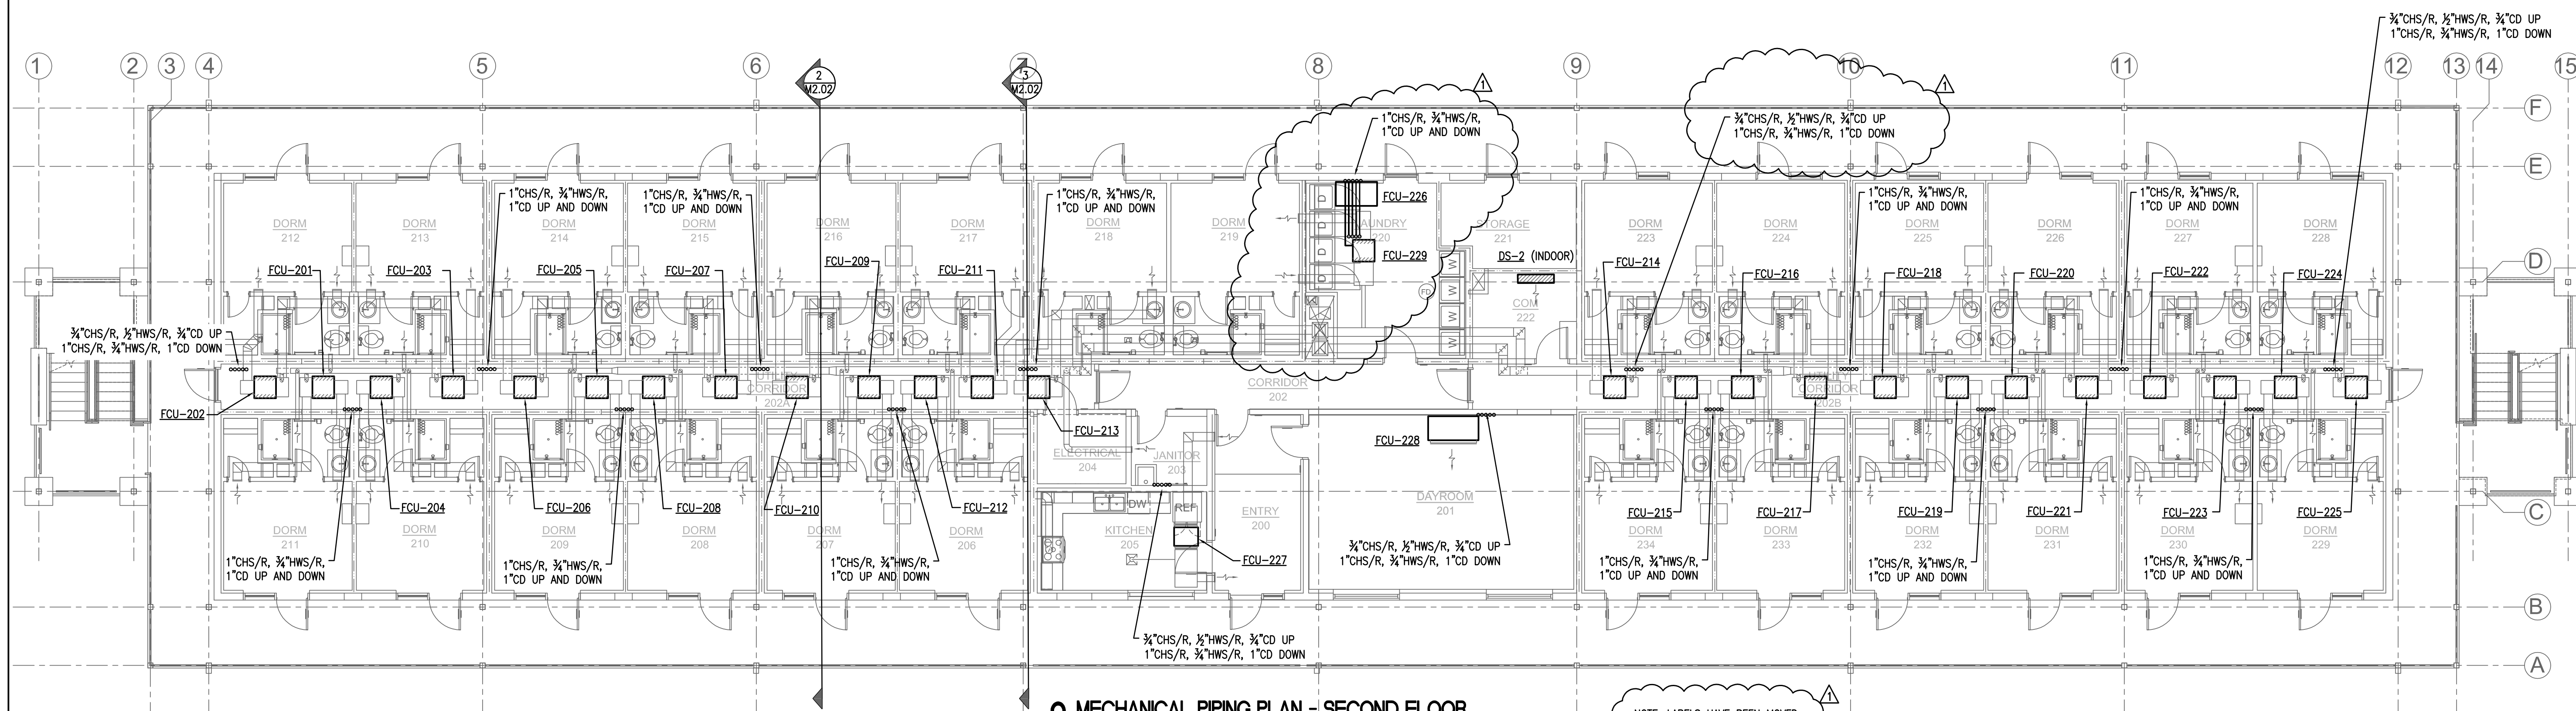

2 MECHANICAL PIPING PLAN - SECOND FLOOR
SCALE: 1/8" = 1'-0"

NOTE: LABELS HAVE BEEN MOVED
AN MODIFIED FOR CLARITY. ONLY
CLOUDED AREAS HAVE CHANGED.

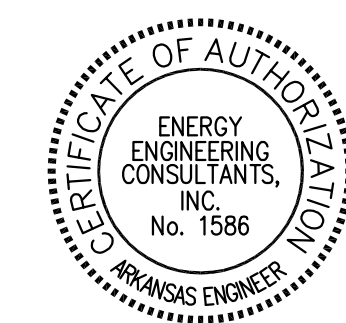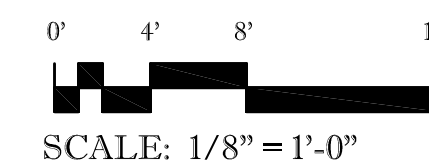

EECI
ENERGY ENGINEERING
CONSULTANTS, INC.
10 CORPORATE HILL DR., STE. 100 PH: (501) 244-0511
LITTLE ROCK, AR 72205 FX: (501) 244-0241



LITTLE ROCK A.F.B.
ARKANSAS

HGL
Construction

CLEMENTS & ASSOCIATES
ARCHITECTURE, INC.
507 MAIN STREET
NORTH LITTLE ROCK, ARKANSAS 72114
PHONE: 501-975-3380
WWW.CLEMENTSARCHITECTS.COM



NO.	REVISION/ISSUE	DATE	BY	APP'D
100	REVISED SUBMITTAL	4/26/24		

REPAIR (SUS) AIRMEN
DORMITORY BLDG 854

MECHANICAL
PIPING PLAN

HS, BD	GC
HS	NKAK 21-1034
GC	
DATE	29 FEB. 2024
AS NOTED	

M2.03
78 of 100