



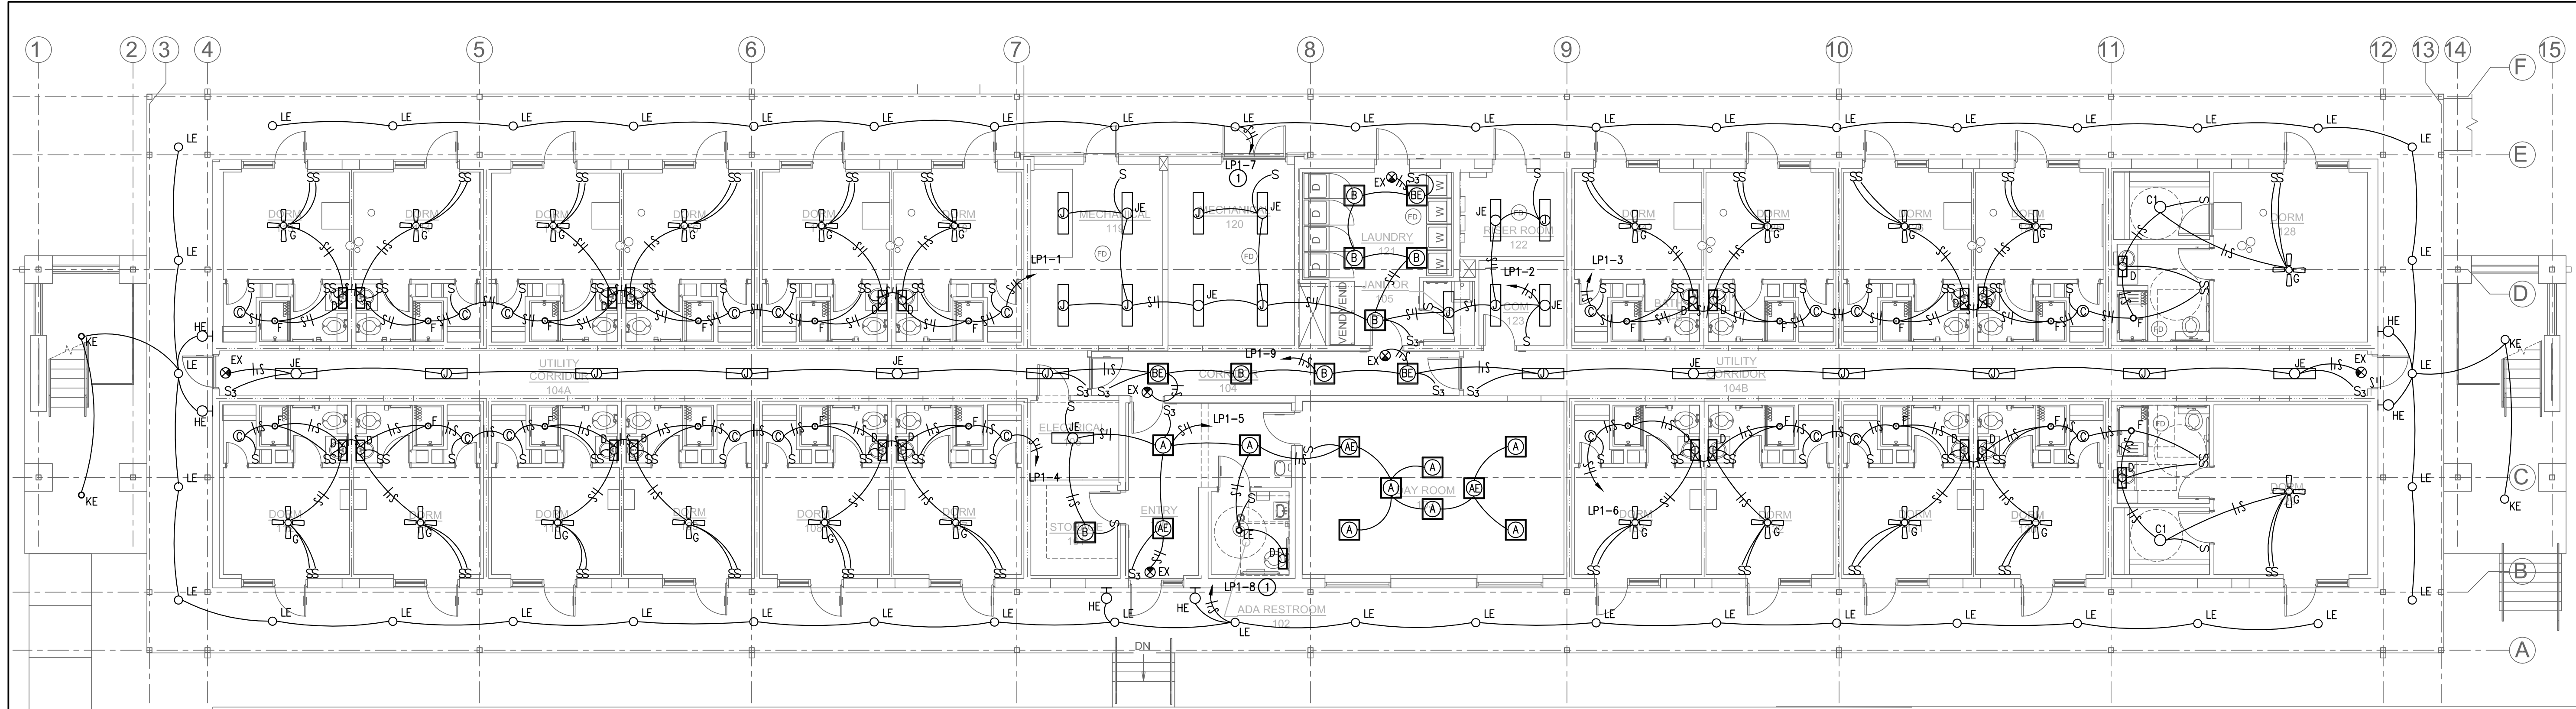



1 LIGHTING PLAN - FIRST FLOOR
SCALE: 1/8" = 1'-0"

KEYED NOTES:

- 1 CIRCUIT SHALL BE CONNECTED TO AN EMERGENCY BATTERY INVERTER TO PROVIDE EGRESS LIGHTING. LIGHTING SHALL ALSO BE TIME CLOCK AND PHOTO CELL CONTROLLED.

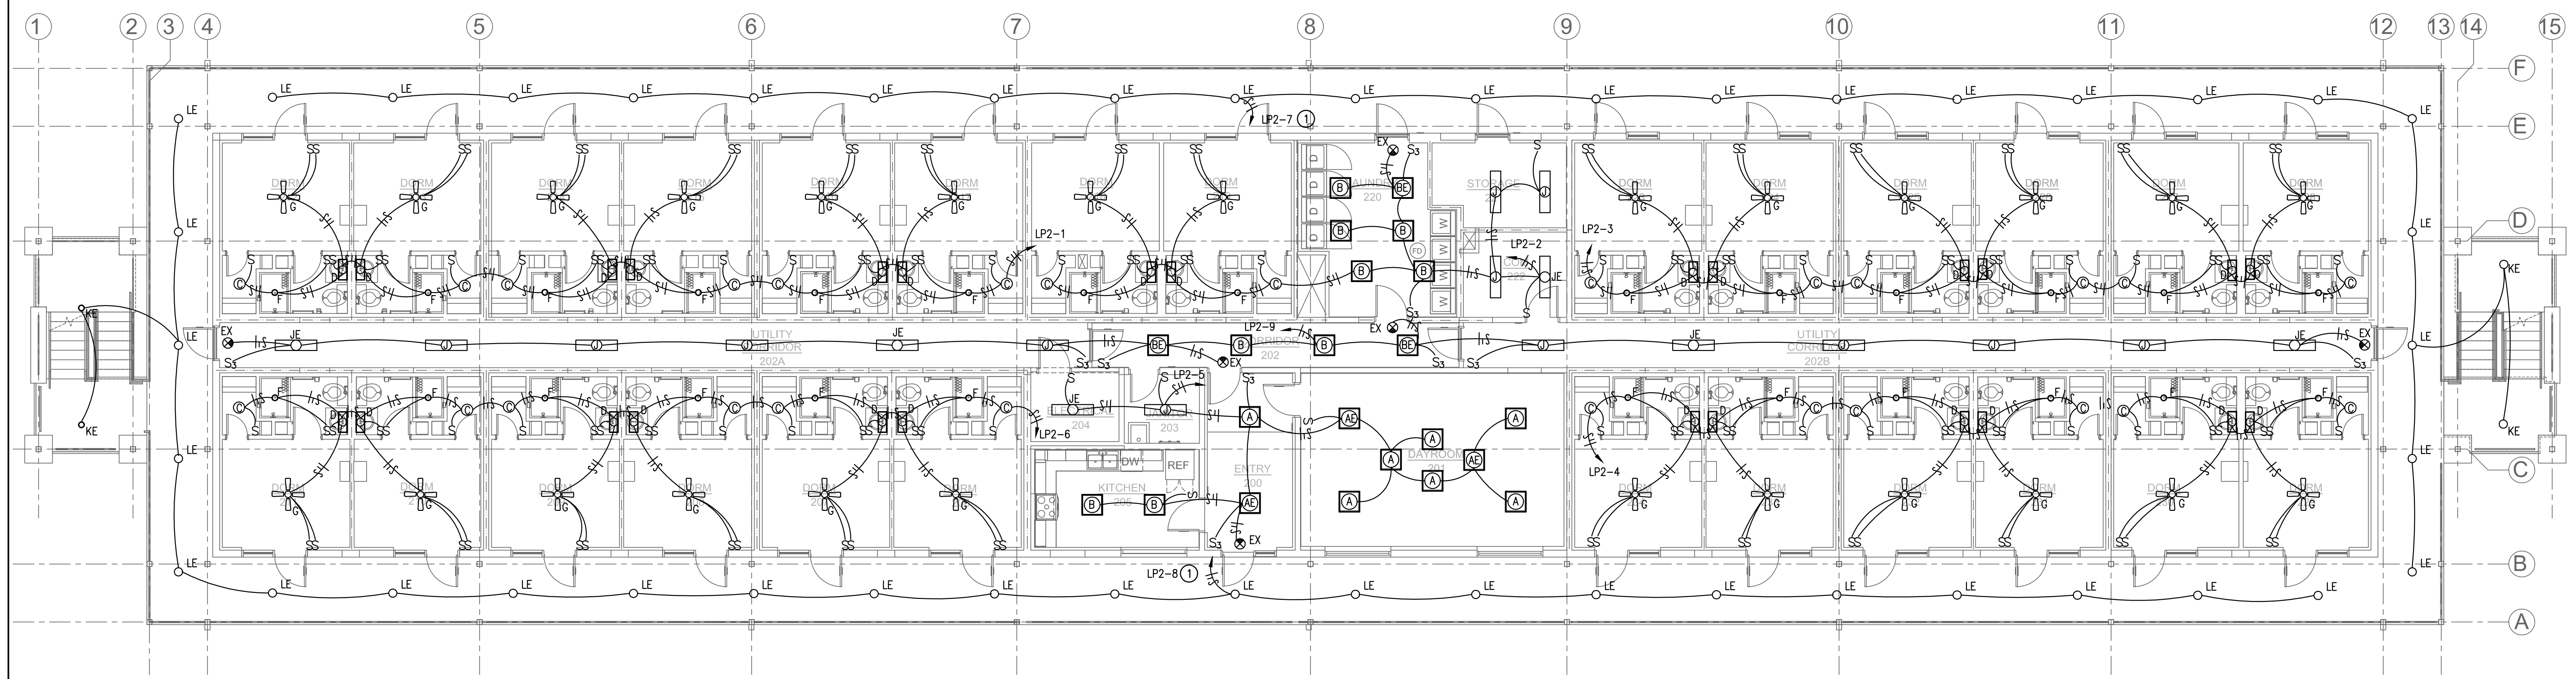

2 LIGHTING PLAN - SECOND FLOOR
SCALE: 1/8" = 1'-0"

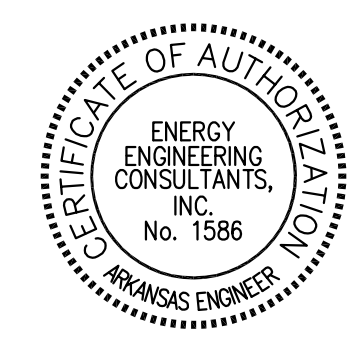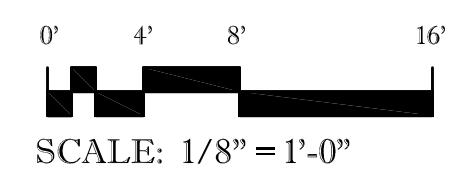

EECI
ENERGY ENGINEERING
CONSULTANTS, INC.

10 CORPORATE HILL DR., STE. 100 PH: (501) 244-0511
LITTLE ROCK, AR 72205 FX: (501) 244-0241



LITTLE ROCK A.F.B.
ARKANSAS



CLEMENTS & ASSOCIATES
ARCHITECTURE, INC.
507 MAIN STREET
NORTH LITTLE ROCK, ARKANSAS 72114
PHONE: 501-975-3380
WWW.CLEMENTSARCHITECTS.COM



No.	Revision/Issue	Date	By	APP'D

**REPAIR (SUS) AIRMEN
DORMITORY BLDG 854**

LIGHTING PLAN

DESIGNED BY	GC	SHEET	E2.01
HS, BD	GC		
DESIGNED BY	GC	DATE	29 FEB. 2024
HS	NKAK 21-1034	DATE	29 FEB. 2024
AS NOTED	89	OF	100