


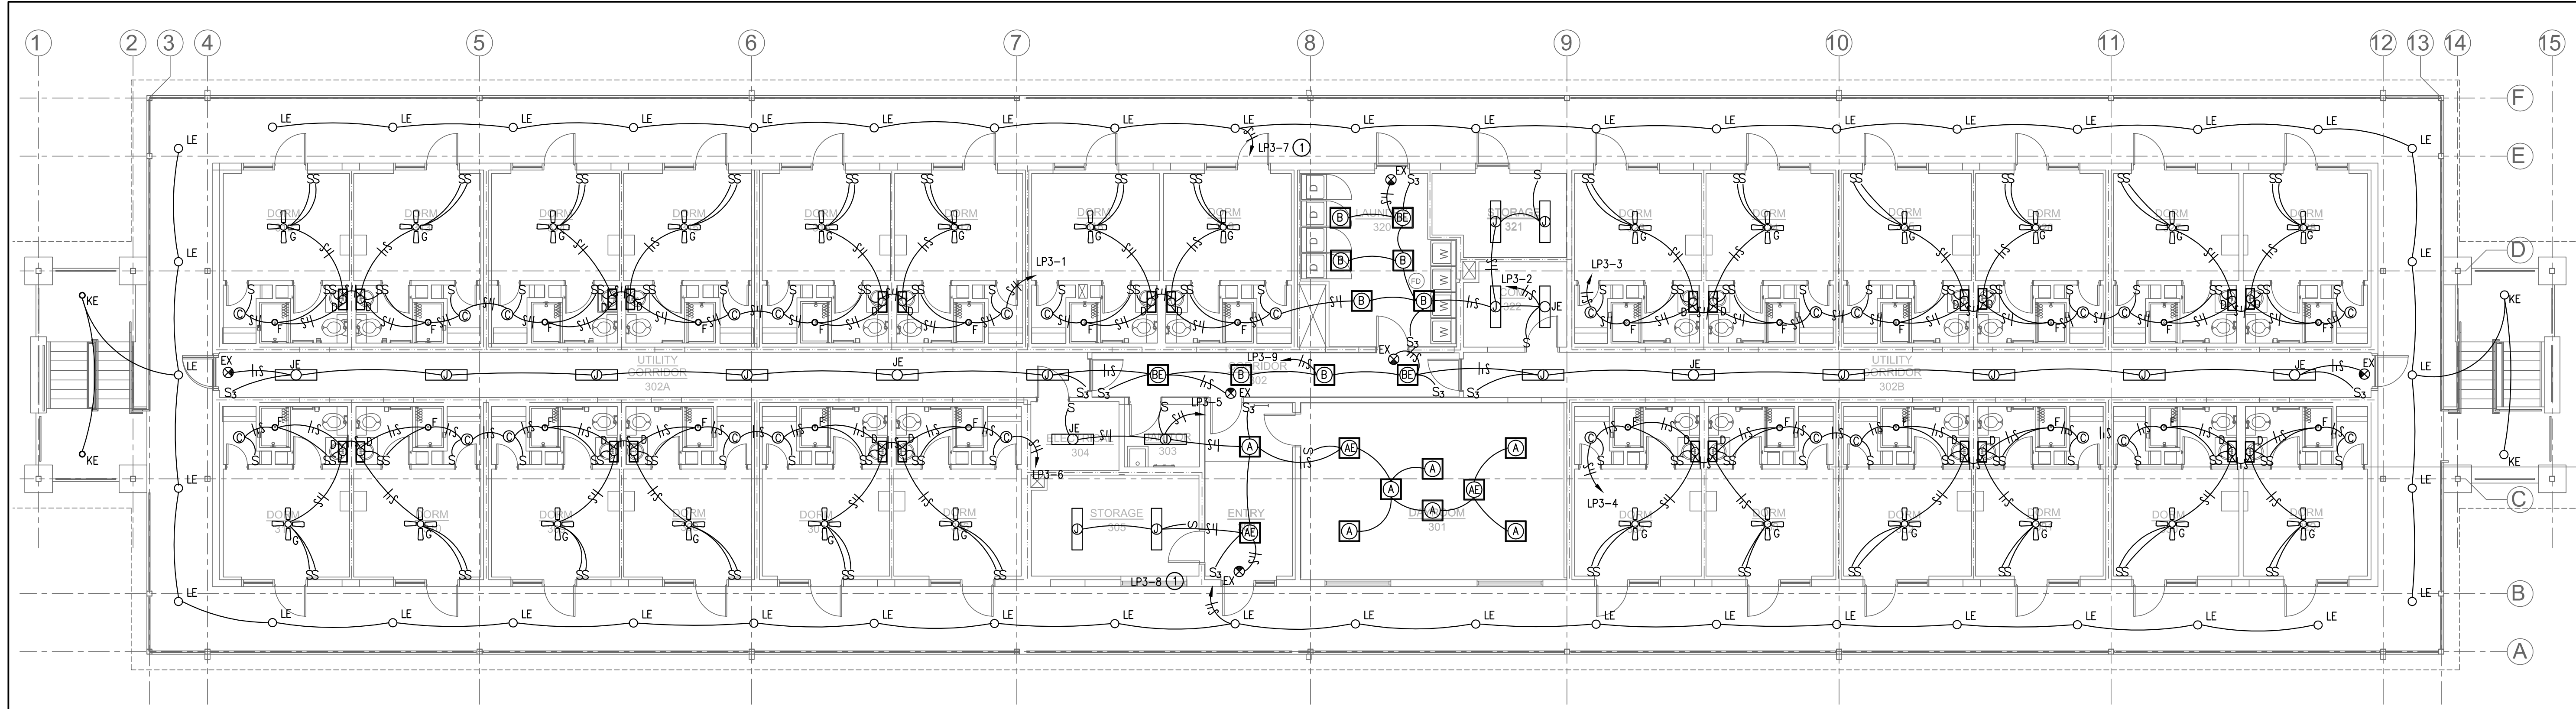



1 LIGHTING PLAN - THIRD FLOOR
SCALE: 1/8" = 1'-0"

KEYED NOTES:

- ① CIRCUIT SHALL BE CONNECTED TO AN EMERGENCY BATTERY INVERTER TO PROVIDE EGRESS LIGHTING. LIGHTING SHALL ALSO BE TIME CLOCK AND PHOTO CELL CONTROLLED.

B-854 LIGHT FIXTURE SCHEDULE										
TYPE	MANUFACTURER	PART NUMBER	VOLTAGE	SOURCE	INPUT POWER (W)	CRI	CCT	MOUNTING	REMARKS	NOTES
A	LITHONIA	2BLT2 33L ADSM EZ1 LP935	UNV	LED	26.67	80	3500K	RECESSED	2X2 DECORATIVE, LENS	1
AE	LITHONIA	2BLT2 33L ADSM EZ1 LP935 EL7L	UNV	LED	26.67	80	3500K	RECESSED	2X2 DECORATIVE, LENS, BATTERY	1
B	LITHONIA	2BLT2 33L ADSM EZ1 LP935	UNV	LED	26.67	80	3500K	RECESSED	2X2 DECORATIVE, LENS	1
BE	LITHONIA	2BLT2 33L ADSM EZ1 LP935 EL7L	UNV	LED	26.67	80	3500K	RECESSED	2X2 DECORATIVE, LENS, BATTERY	1
C	JUNO	JSF 11IN SWW5 90CRI MVOLT WH	UNV	LED	14.3	80	3500K	SURFACE	11" DECORATIVE ROUND, LENS	1
C1	JUNO	JSF 13IN SWW5 90CRI MVOLT WH	UNV	LED	19.5	80	3500K	SURFACE	13" DECORATIVE ROUND, LENS	1
D	VISA LIGHTING	CB5500 L30K(H)-MVOLT SNA SNA KA DCC	UNV	LED	15	80	3000K	WALL	2 FOOT LINEAR VANITY, LENS, DAMP LOCATION	1,2
F	JUNO	JPDZ6 SQDC AL010 SWW5D 90CRI JPDZRMJBX 120FRPC WWH	UNV	LED	15.2	80	3500K	RECESSED	6" DOWNLIGHT, LENS, SHOWER, DAMP LOCATION	1,2
G	WIND RIVER	WR2028N	120V	LED	17	80	3500K	SURFACE	42" CEILING FAN, LOW PROFILE, INTEGRAL LED LIGHT KIT	1
HE	EUREKA	3418 LED.HO 35 120V DP EMB BLKE FRO 3981EA	UNV	LED	23.9	80	3500K	WALL	SCONCE, LENS, EXTERIOR, BATTERY	1,3
J	LITHONIA	BLWP4 30L ADSM GZ10 LP840 NEST7ADSX DIM10	UNV	LED	25	80	3500K	SURFACE	4 FOOT STRIP, LENS	1
JE	LITHONIA	BLWP4 30L ADSM GZ10 LP840 NEST7ADSX DIM10 E10WLCP	UNV	LED	25	80	3500K	SURFACE	4 FOOT STRIP, LENS, BATTERY	1
KE	LUMINAIRE LED	VPF4 4FT PRD 40W 35K MVOLT OP BRZ WL EL	UNV	LED	40	80	4000K	RECESSED	DOWNLIGHT, LENS, EXTERIOR, BATTERY	1,3
LE	LITHONIA	LDN6SQ 20LM 35K LS6 AR LSS MVOLT UGZ EL	UNV	LED	25	80	4000K	RECESSED	DOWNLIGHT, LENS, EXTERIOR	1,3
EX	LITHONIA	EDG 1 R EL	UNV	LED	2.5	---	---	UNIVERSAL	EXIT, EDGE-LIT, RED LED, BATTERY	1

- NOTES:
1. FIXTURE COLOR TO BE SELECTED FROM MANUFACTURERS STANDARD COLOR SELECTION DURING SUBMITTAL REVIEW.
2. FIXTURE SHALL BE MANUFACTURED WITH NON-RUSTING HOUSING MATERIALS.
3. FIXTURE SHALL BE CONNECTED TO CENTRAL BATTERY INVERTER ON EACH FLOOR IN LIEU OF INTERNAL BATTERY.

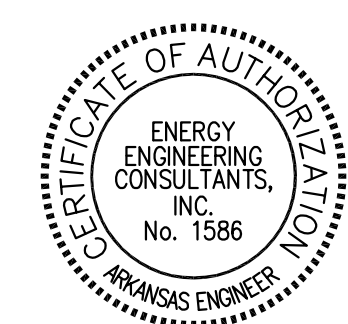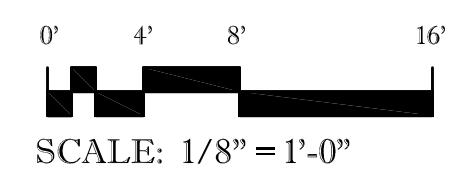

EECI
ENERGY ENGINEERING
CONSULTANTS, INC.

10 CORPORATE HILL DR., STE. 100 PH: (501) 244-0511
LITTLE ROCK, AR 72205 FX: (501) 244-0241



LITTLE ROCK A.F.B.
ARKANSAS



CLEMENTS & ASSOCIATES
ARCHITECTURE, INC.
507 MAIN STREET
NORTH LITTLE ROCK, ARKANSAS 72114
PHONE: 501-975-3380
WWW.CLEMENTSARCHITECTS.COM



						APPD
						BY
						Date
						Revision/Issue
						No.

REPAIR (SUS) AIRMEN DORMITORY BLDG 854		LIGHTING PLAN	
DESIGNED BY HS, BD	PLAT. DESCRIPTION GC	DESIGNED BY HS	PLAT. NUMBER NKAK 21-1034
DATE 29 FEB. 2024	SHEET E2.02	DATE 29 FEB. 2024	SHEET 90 OF 100
AS NOTED			