


- | HVAC GENERAL NOTES |  |
|--------------------|--|
| 1.                 | ALL LIGHTER SOLID LINES REPRESENT PIPING, DUCTWORK, EQUIPMENT, ETC. TO REMAIN.                             |
| 2.                 | ALL DARKER SOLID LINES REPRESENT NEW PIPING, DUCTWORK, EQUIPMENT, ETC.                                     |
| 3.                 | FIELD VERIFY EXACT SIZE AND LOCATION OF ALL EXISTING ITEMS SHOWN ON THIS PLAN THAT ARE TO BE CONNECTED TO. |

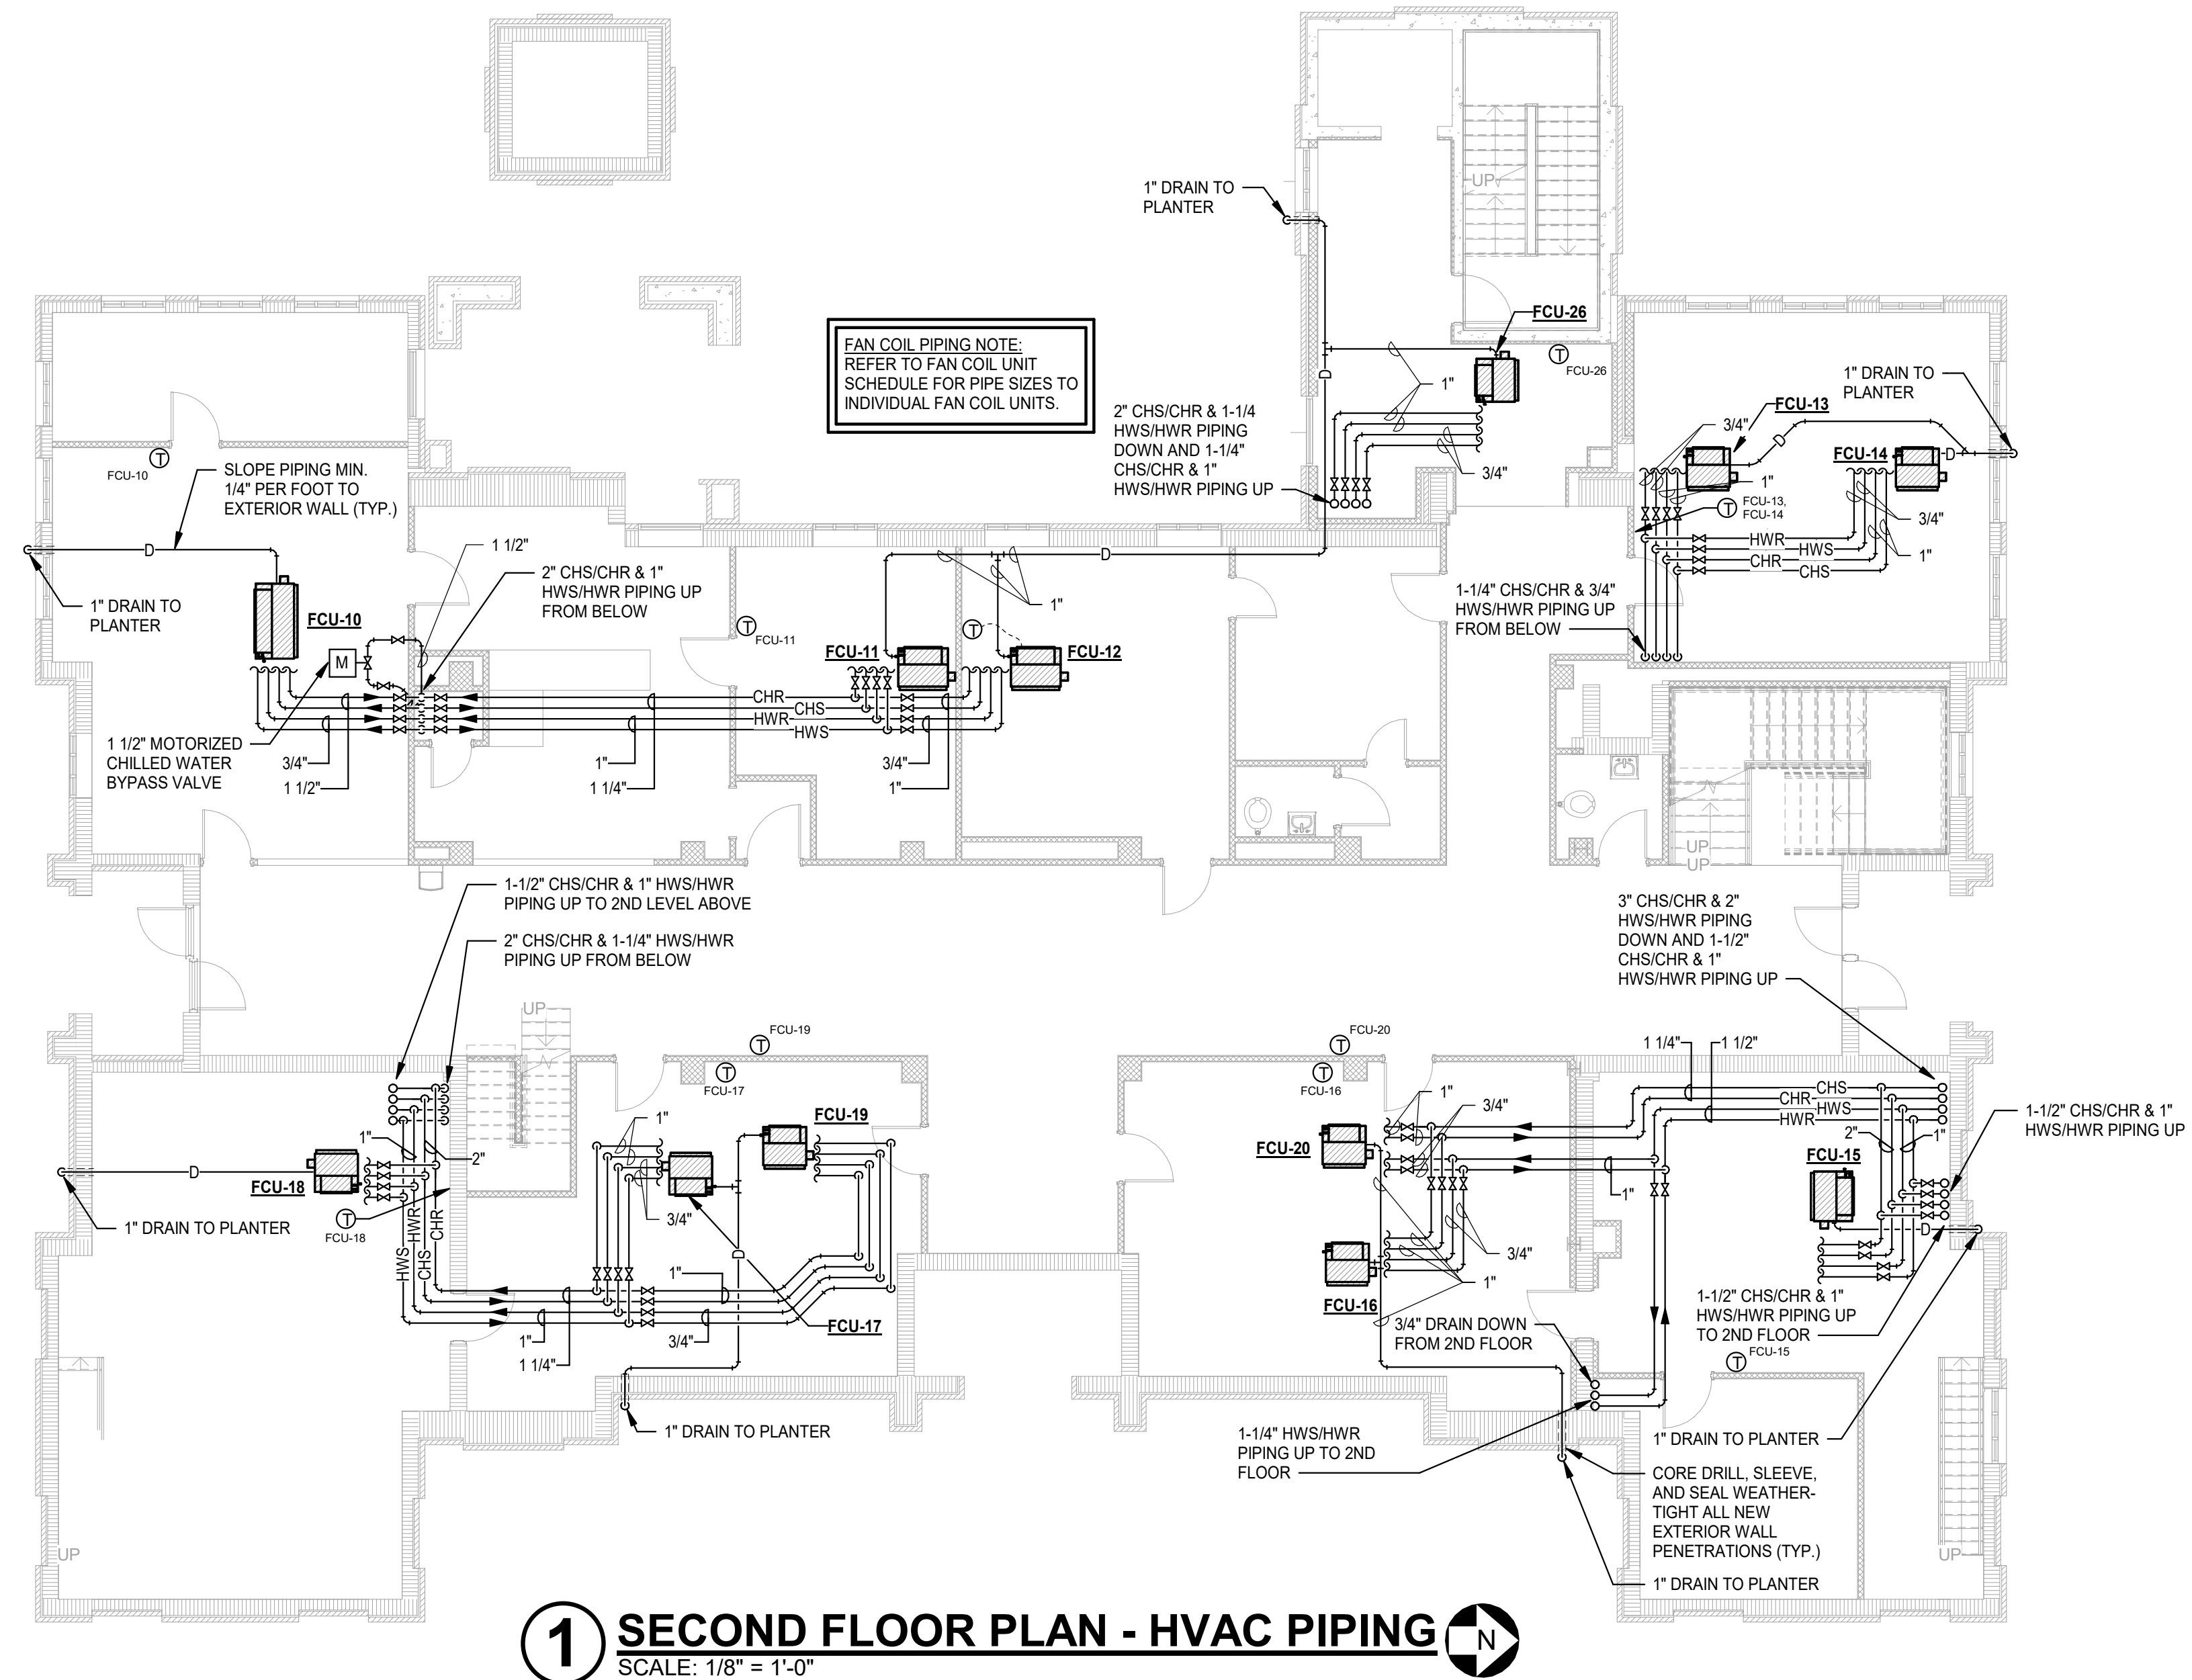


**1 SECOND FLOOR PLAN - HVAC PIPING**  
 SCALE: 1/8" = 1'-0"

**MECHANICAL RENOVATIONS FOR:  
 CRAIGHEAD COUNTY COURTHOUSE**  
 Jonesboro, Arkansas



Revision Schedule	Issued by
Tag	Rev. Date
Rev. Description	Rev. Date

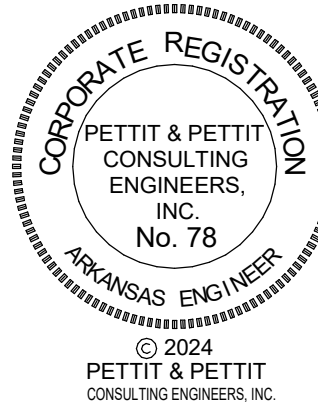

Commission Number  
2309D

**M103**

Date: November 11, 2024