


C:\USERS\RAMB301\APPDATA\LOCAL\AUTODESK\AUTOCAD PLANT 3D\COLORBROWSE\CACHE\406493\PID.DWG\G-26.DWG 8/21/2024 4:28 PM. RAMSEY, AUSTIN W. LAYOUT

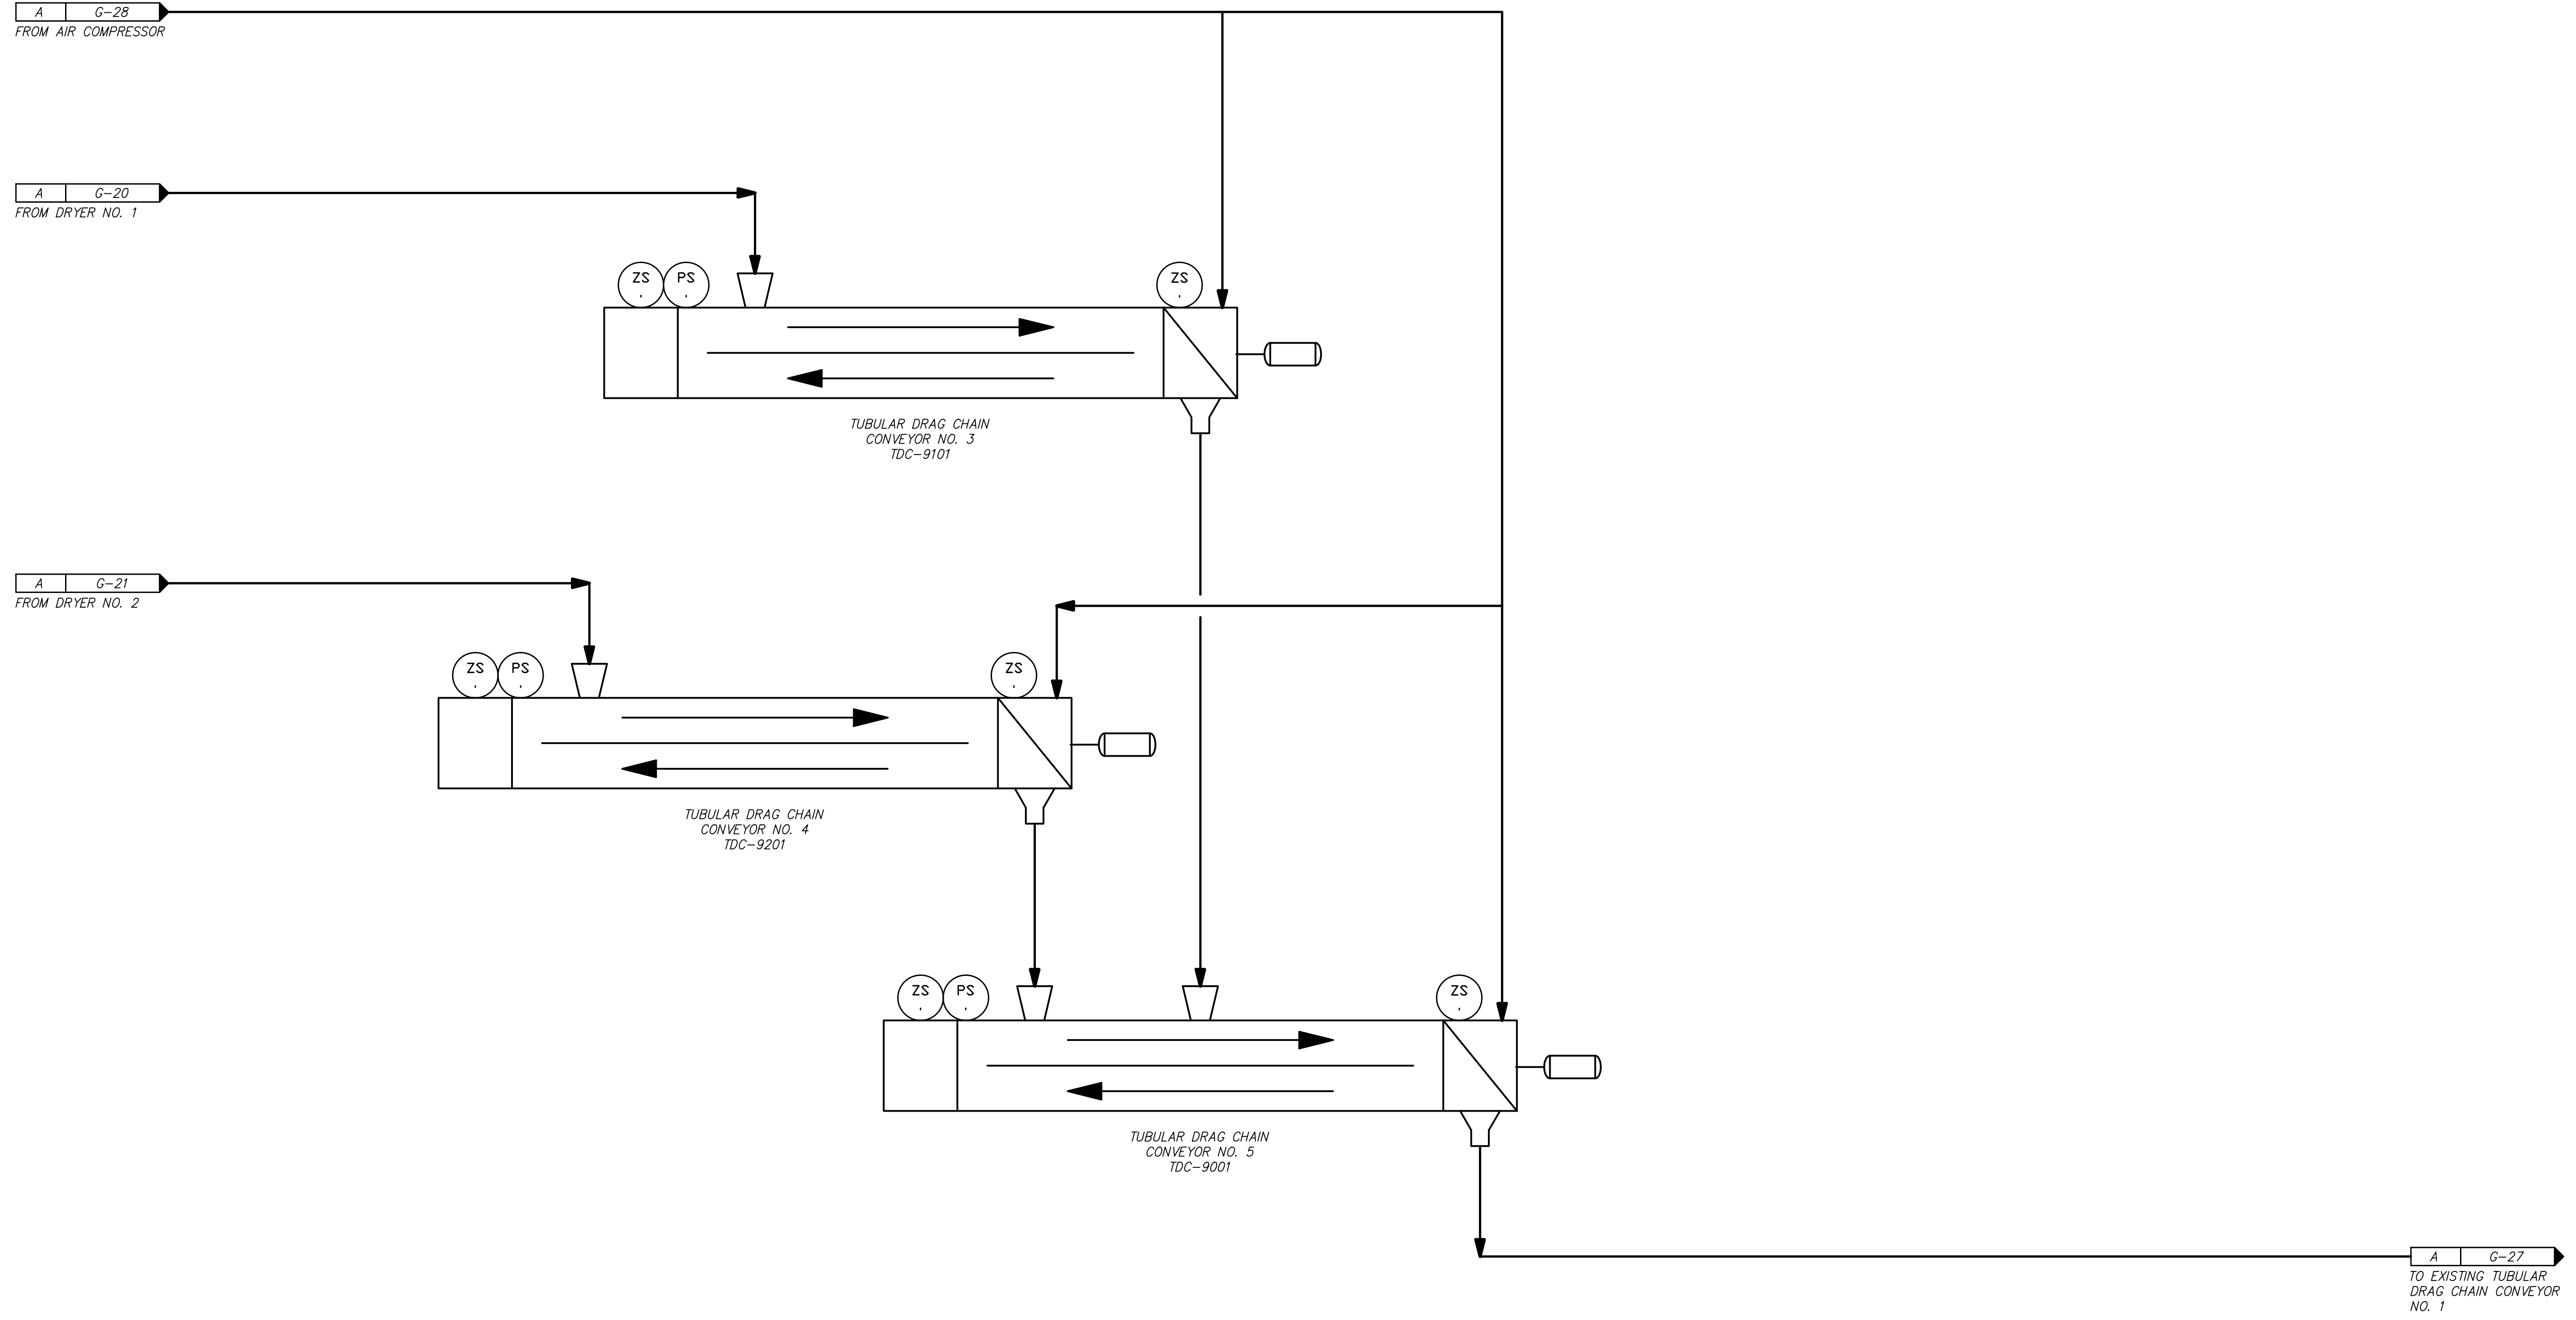

1"  
ONE INCH  
AT FULL SIZE  
IF NOT ONE INCH  
SCALE ACCORDINGLY

DATE	
REVISION	



**HAWKINS WEIR ENGINEERS, INC.**  
**BLACK & VEATCH**

ROGERS, ARKANSAS  
 ROGERS POLLUTION CONTROL FACILITY (RCF)  
 SOLIDS HANDLING IMPROVEMENTS, PHASE II  
 PROCESS FLOW DIAGRAM  
 TUBULAR DRAG CHAIN CONVEYOR  
 FOR: ROGERS WATER UTILITIES

DATE: AUGUST 2024  
 SCALE: NONE  
 DESIGNED BY: KJJ  
 DRAWN BY: AWR  
 HWEI NO.: 2020043  
 FILENAME: