


C:\USERS\RAMB3010\APPDATA\LOCAL\AUTODESK\AUTOCAD PLANT 3D\COLORATION\CACHE\406493\PID DWG\G-30.DWG. 8/21/2024 4:07 PM. RAMSEY, AUSTIN W. LAYOUT

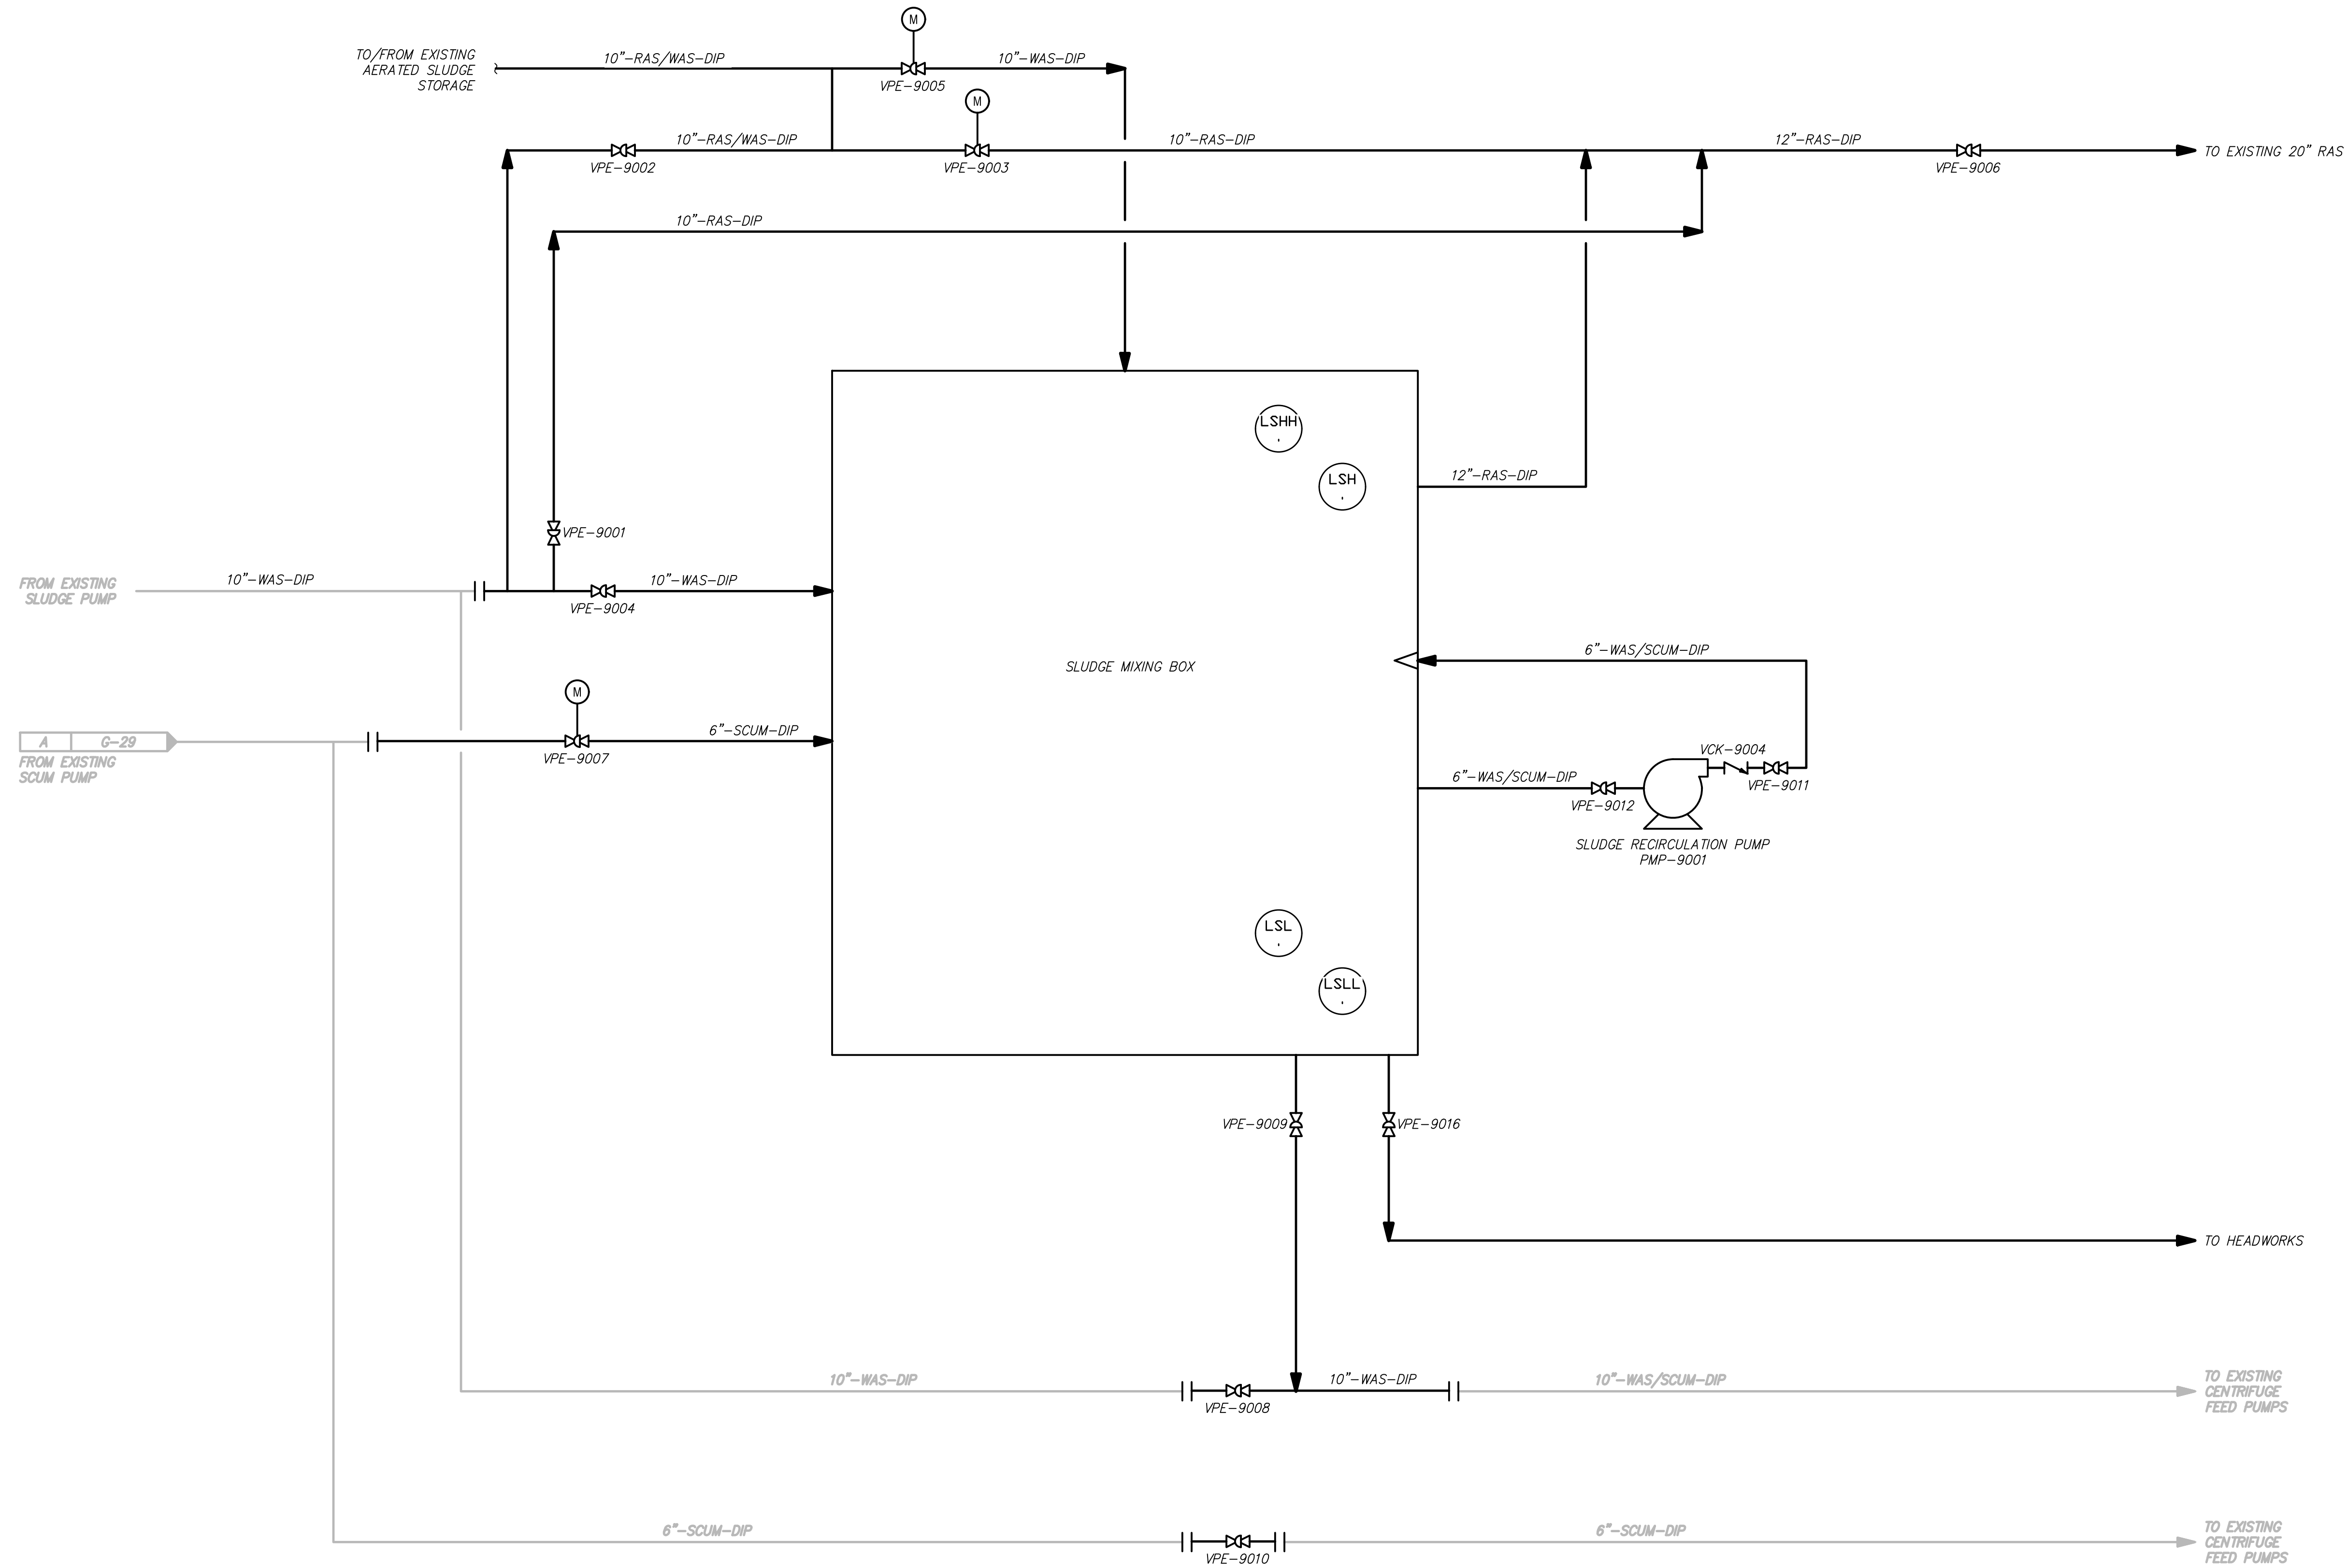

1"  
ONE INCH  
AT FULL SIZE  
IF NOT ONE INCH  
SCALE ACCORDINGLY

DATE	REVISION



**HAWKINS WEIR ENGINEERS, INC.**  
**BLACK & VEATCH**

ROGERS, ARKANSAS  
 ROGERS POLLUTION CONTROL FACILITY (RCF)  
 SOLIDS HANDLING IMPROVEMENTS, PHASE II  
**PROCESS FLOW DIAGRAM  
 SLUDGE MIXING BOX**  
 FOR: ROGERS WATER UTILITIES

DATE: AUGUST 2024  
 SCALE: NONE  
 DESIGNED BY: KJJ  
 DRAWN BY: AWR  
 HWEI NO.: 2020043  
 FILENAME:

SHEET NO.  
**G-30**