


120V FROM CPT


MAKEUP AIR UNIT MA-201 CONTROL AND RISER DIAGRAM

DETAIL EE EA-4
N.T.S.

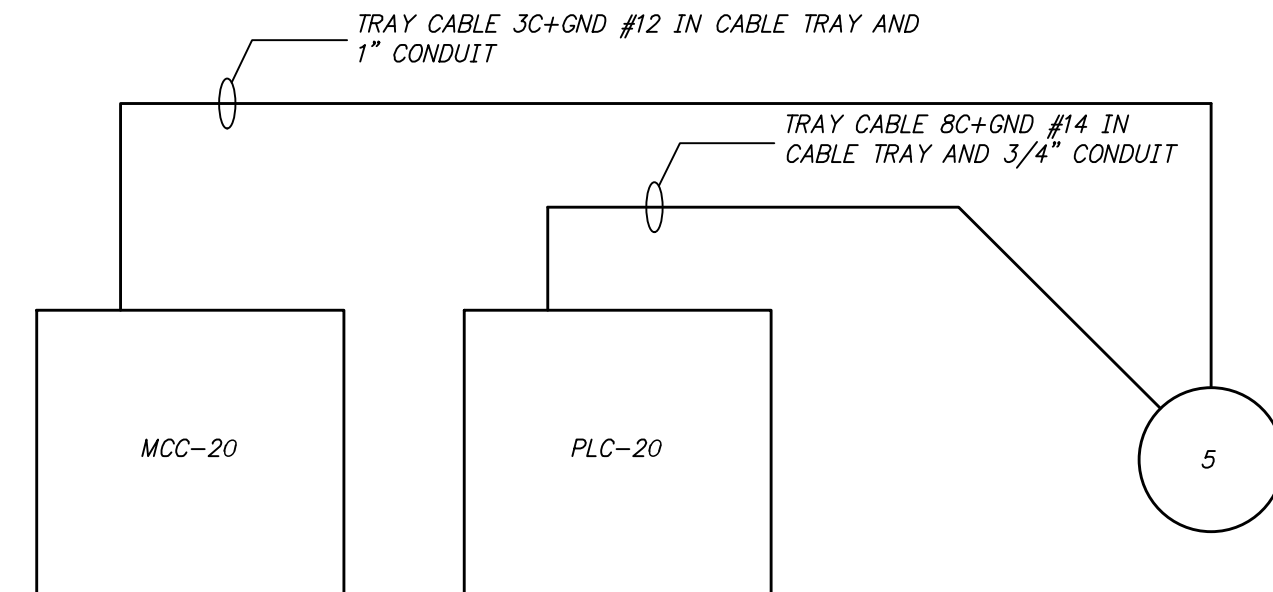


ELECTRIC UNIT HEATER CONTROL AND RISER DIAGRAM

DETAIL FF EA-4
N.T.S.

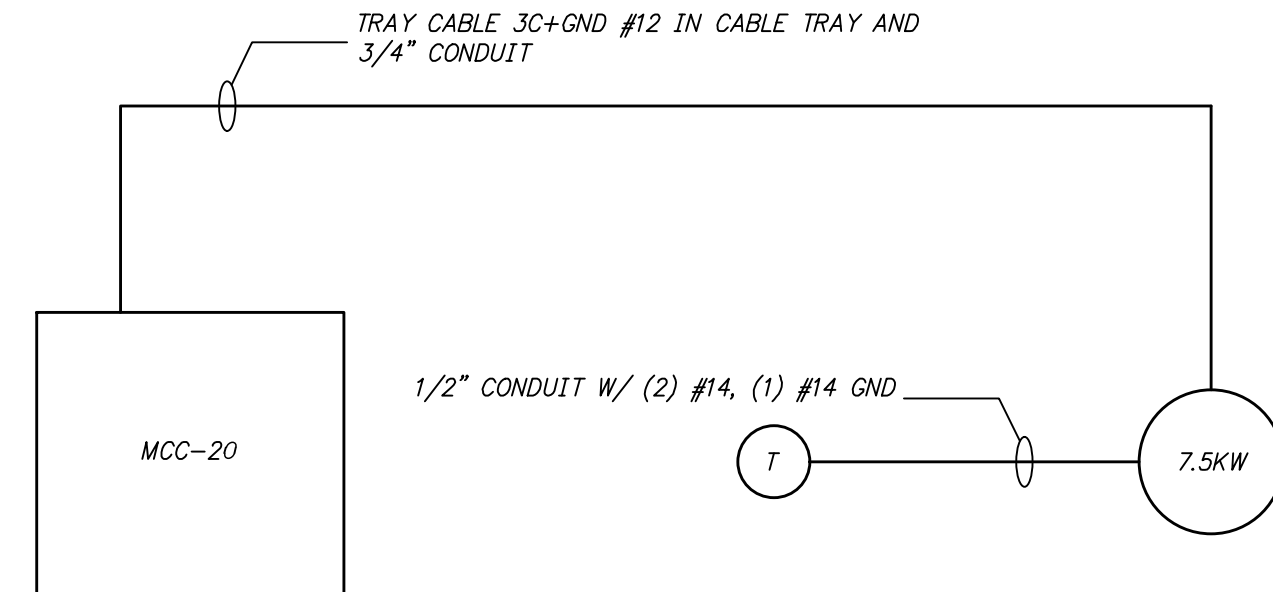


OVERHEAD COILING DOOR CONTROL AND RISER DIAGRAM

DETAIL GG EA-4
N.T.S.

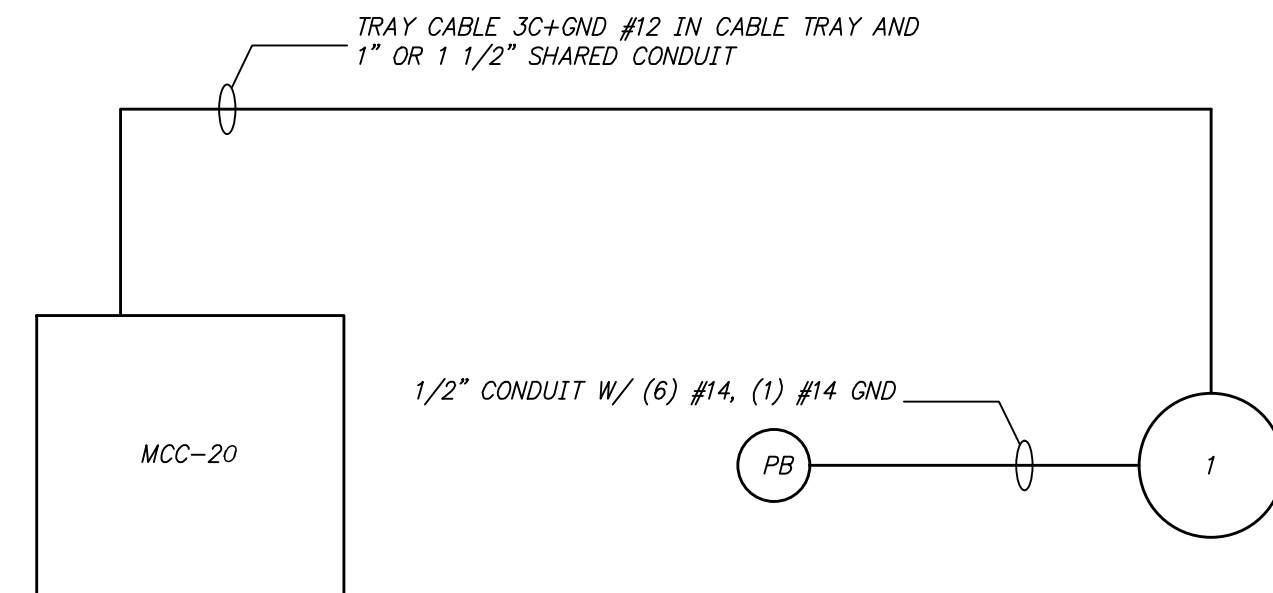


SCREW CONVEYOR GATE ACTUATORS CONTROL AND RISER DIAGRAM (TYP OF 2)

DETAIL HH EA-4
N.T.S.

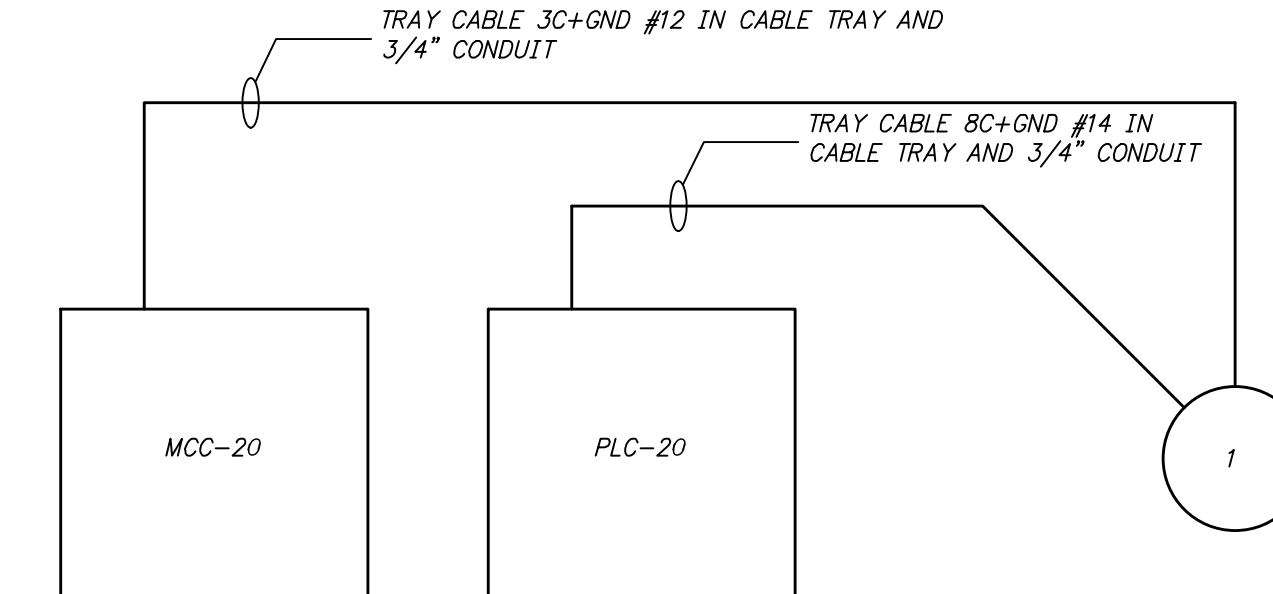


120V FROM MCC CPT

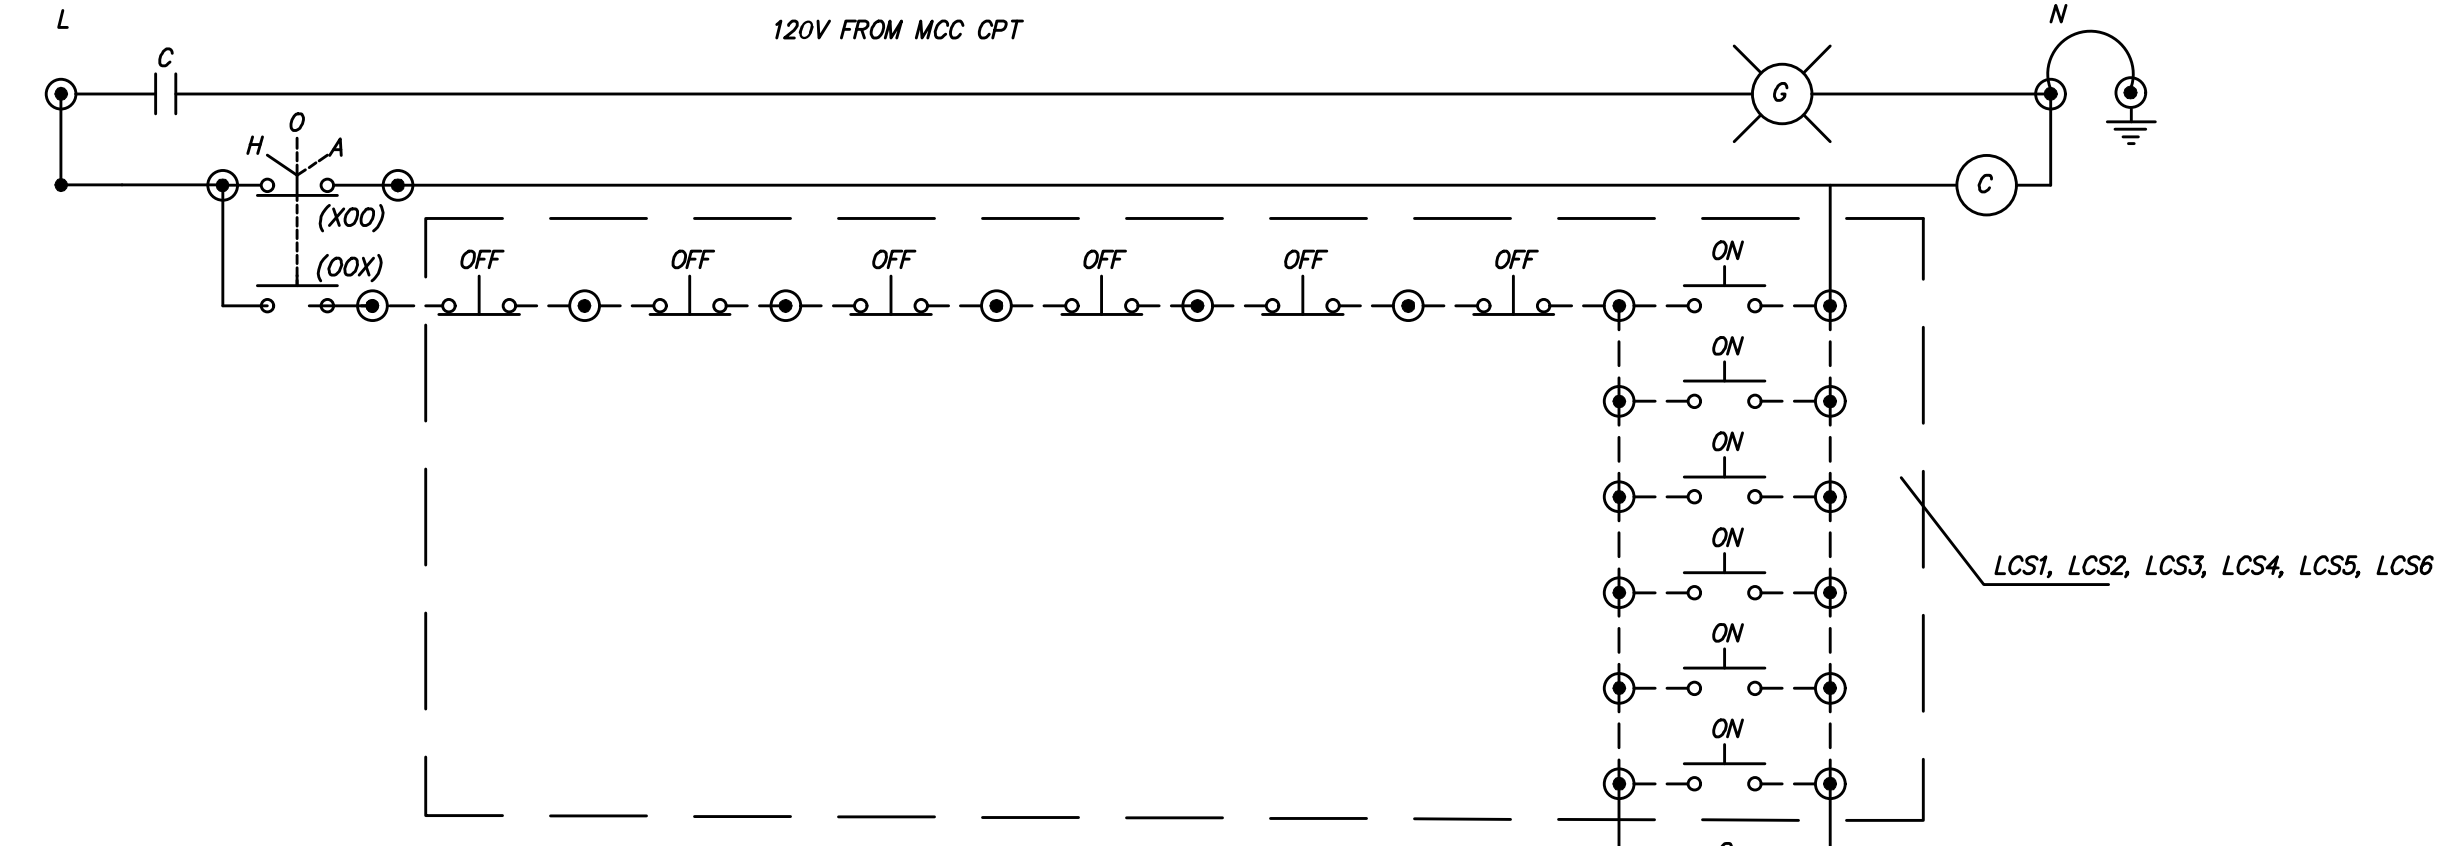


INTERIOR HIGH BAY LIGHTING RISER DIAGRAM

DETAIL II EA-4
N.T.S.

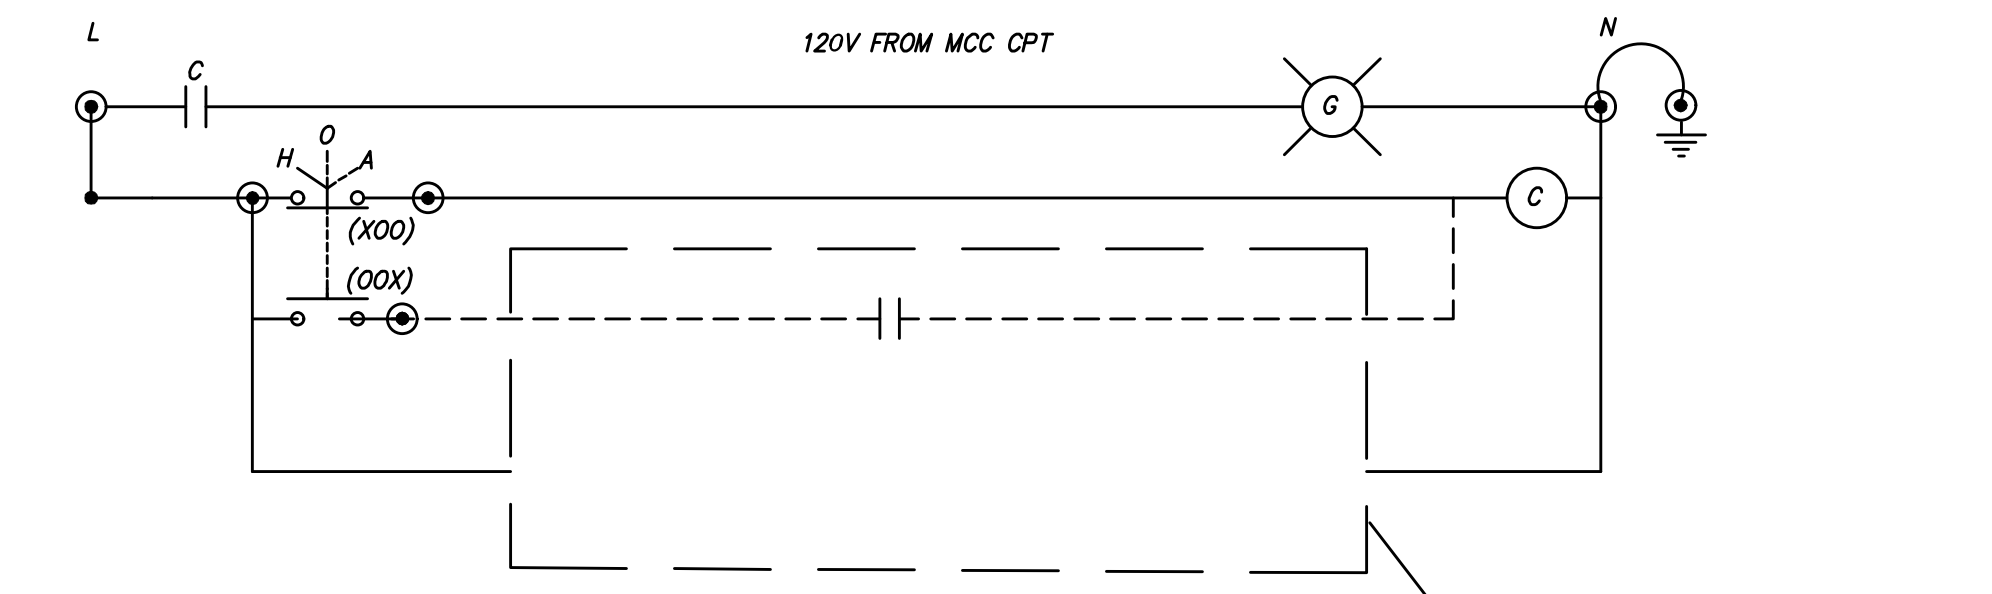


EXTERIOR LIGHTING RISER DIAGRAM

DETAIL JJ EA-4
N.T.S.

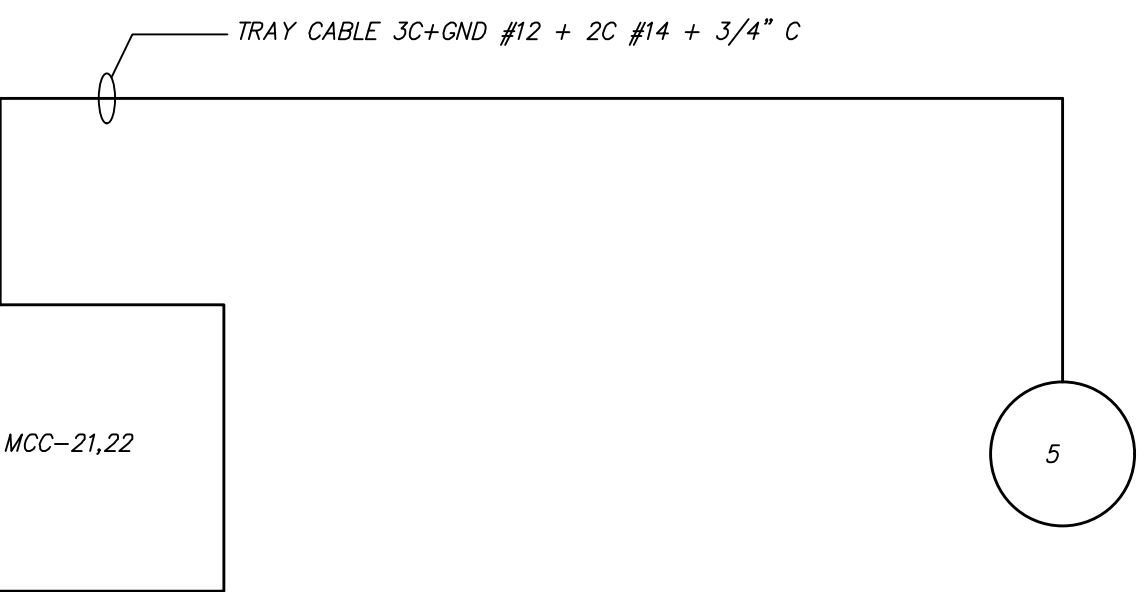

HIGH PRESSURE PUMP BELT CLEANING CONTROL AND RISER DIAGRAM (TYP OF 2)

DETAIL CC EA-2,3
N.T.S.

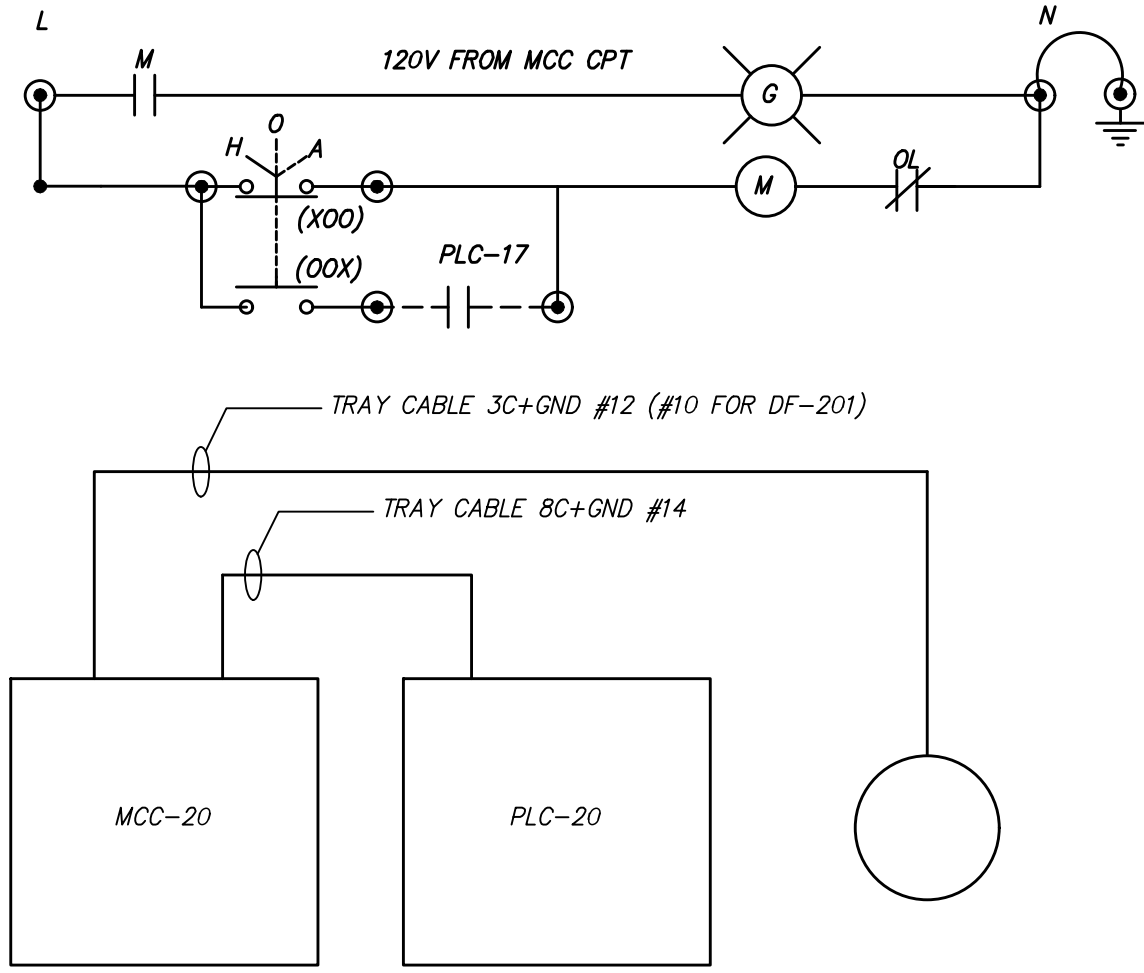

EXHAUST OR SUPPLY FAN CONTROL AND RISER DIAGRAM (TYP OF 8)

DETAIL DD EA-4
N.T.S.

1" ONE INCH AT FULL SIZE IF NOT ONE INCH SCALE ACCORDINGLY

DATE	
REVISION	



HAWKINS WEIR ENGINEERS, INC.
BLACK & VEATCH

ROGERS, ARKANSAS
ROGERS POLLUTION CONTROL FACILITY (PCF)
SOLIDS HANDLING IMPROVEMENTS, PHASE II
DRYER BUILDING MCC CONTROL AND RISER DIAGRAM VI
FOR: ROGERS WATER UTILITIES

DATE: AUGUST 2024
SCALE: NTS
DESIGNED BY: LSM
DRAWN BY: LSM
HWEI NO.: 2020043
FILENAME: EA-10

SHEET NO. EA-10

Z:\20\2020043 ROGERS SOLIDS HANDLING IMPROVEMENTS, PH 2\DRAWINGS\CONSTRUCTION DRAWINGS\WIP\EA-10.DWG, 8/26/2024 11:16 AM, MATT WEIR, LAYOUT