


Z:\20\2020043 ROGERS SOLIDS HANDLING IMPROVEMENTS, PH 2\DRAWINGS\CONSTRUCTION DRAWINGS\WTPA\ED-02.DWG, 8/26/2024 11:18 AM, MATT WEIR, LAYOUT

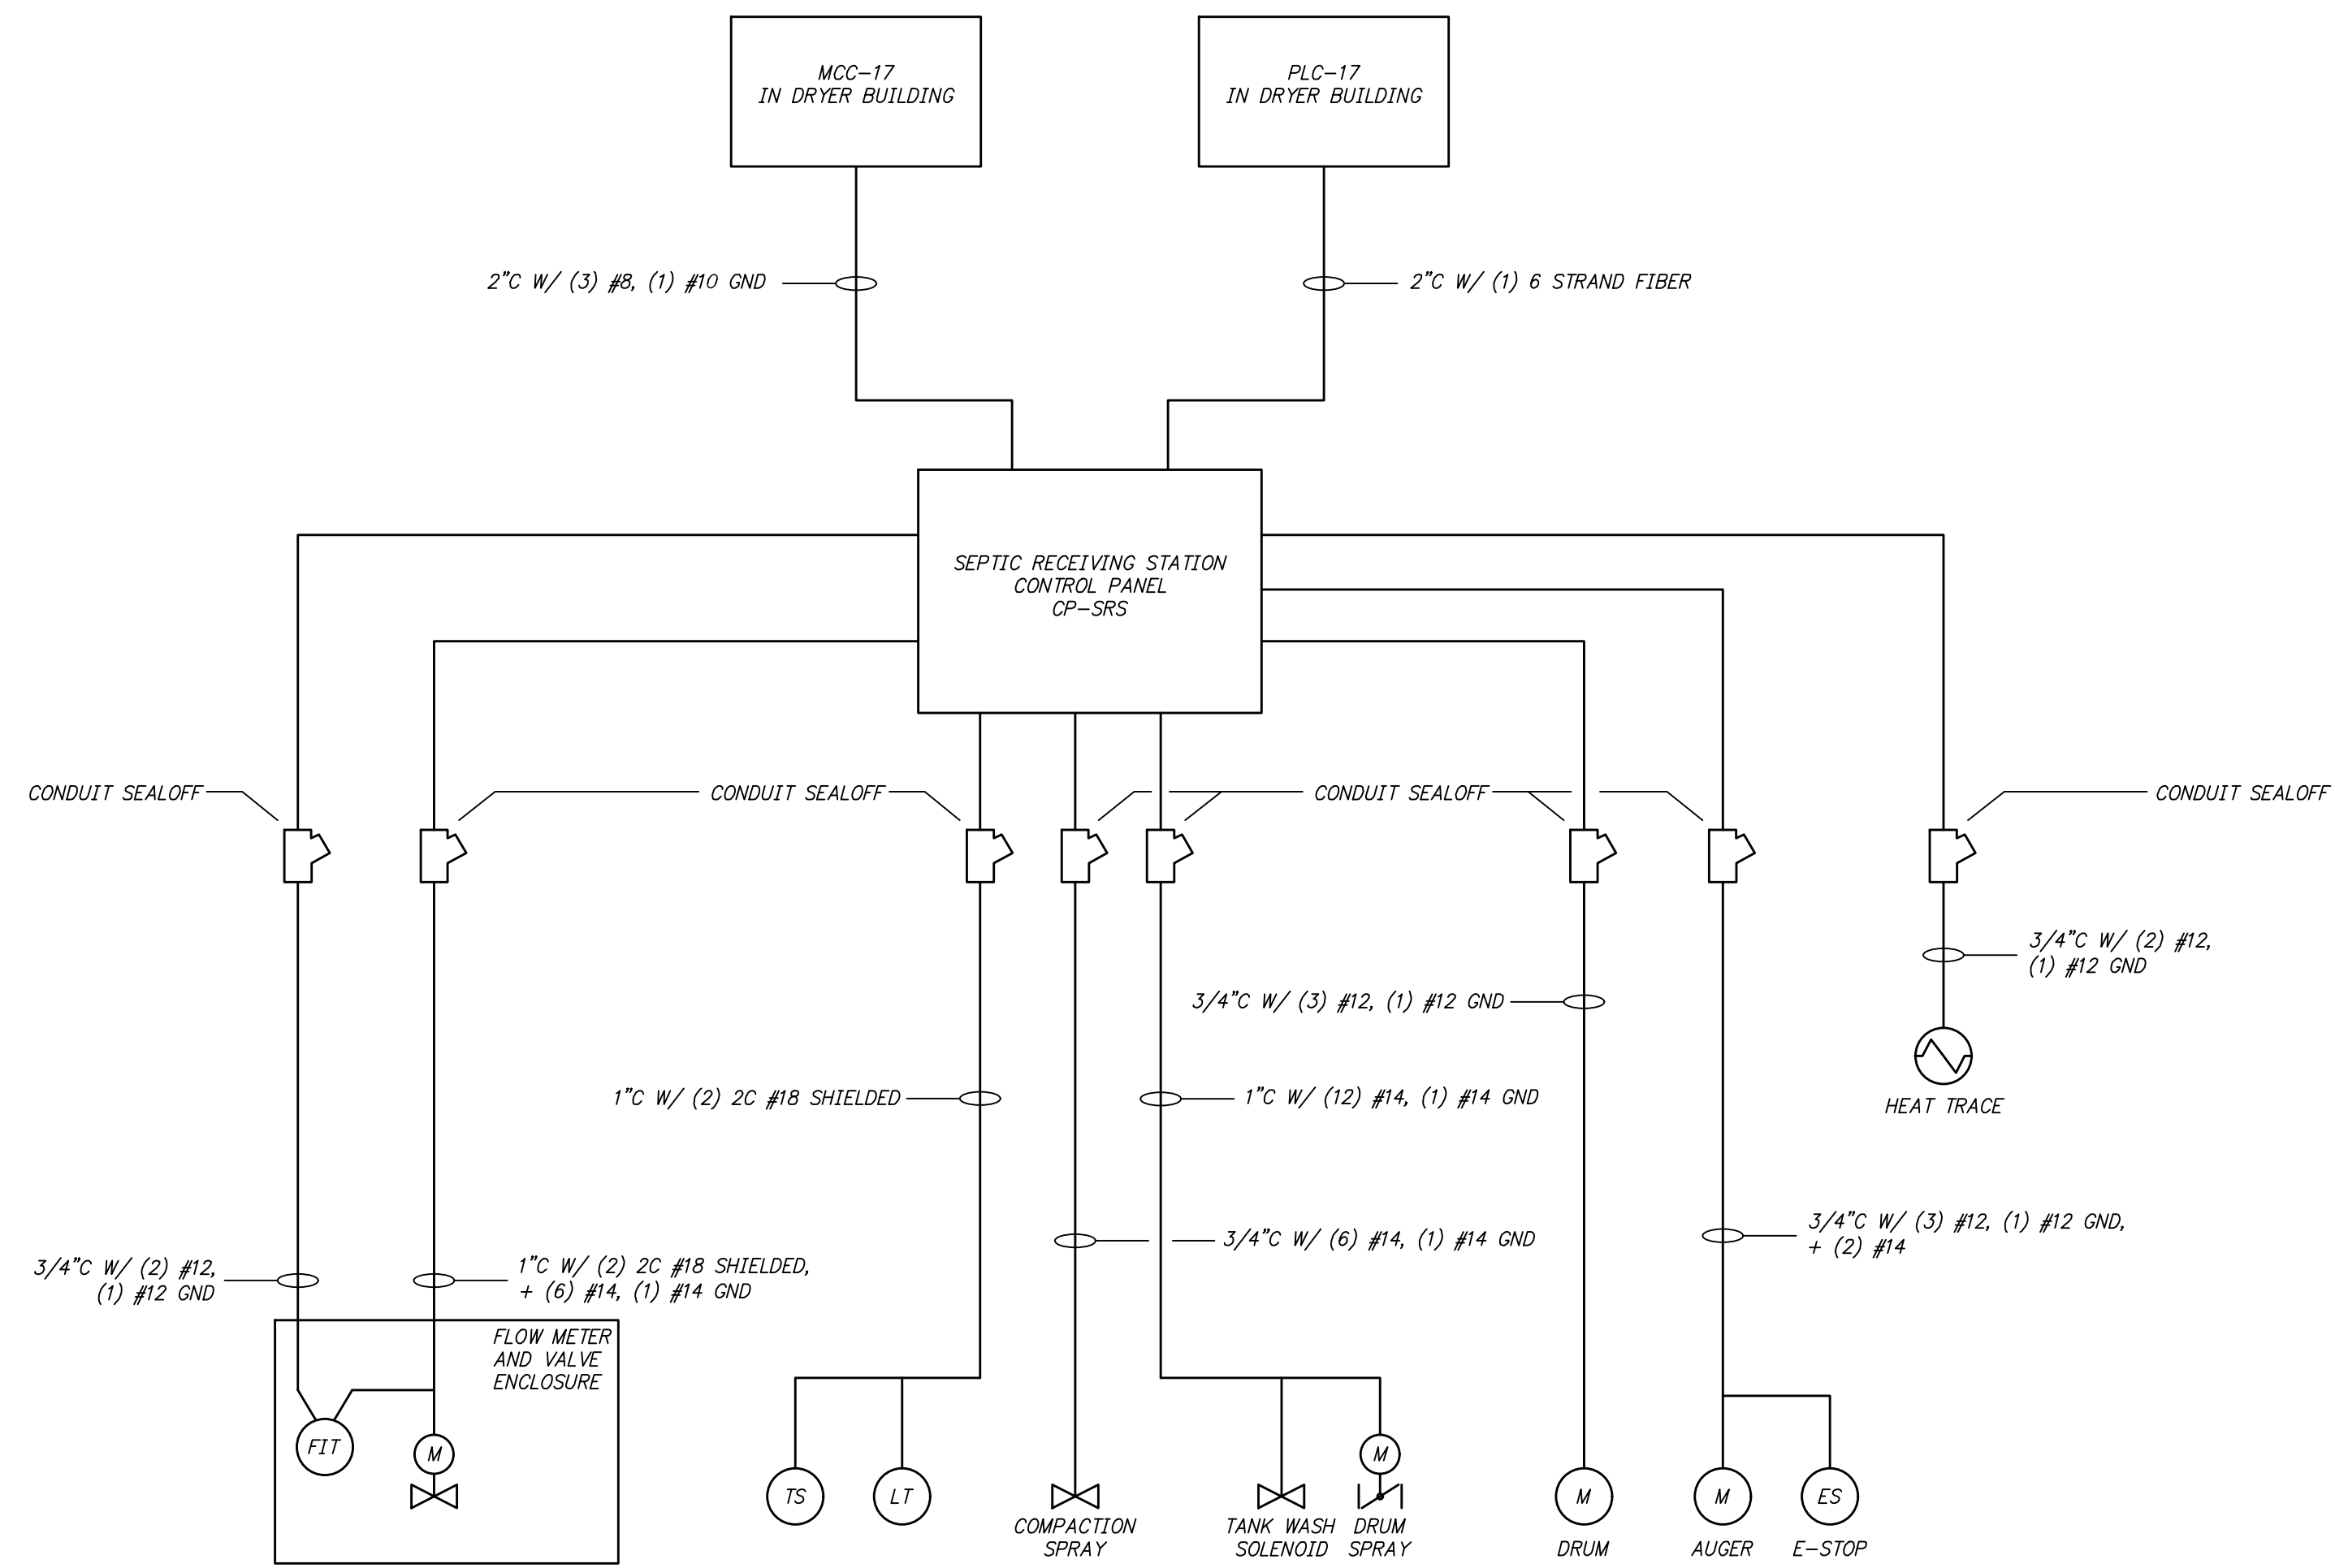

SEPTIC RECEIVING STATION  
POWER AND CONTROLS RISER DIAGRAM  
DETAIL B  
N.T.S. ED-1

ONE INCH  
AT FULL SIZE  
IF NOT ONE INCH  
SCALE ACCORDINGLY

DATE	REVISION



**HAWKINS WEIR ENGINEERS, INC.**  
**BLACK & VEATCH**

ROGERS, ARKANSAS  
 ROGERS POLLUTION CONTROL FACILITY (PCF)  
 SOLIDS HANDLING IMPROVEMENTS, PHASE II  
 SEPTIC RECEIVING STATION  
 ELECTRICAL DETAILS  
 FOR: ROGERS WATER UTILITIES

DATE: AUGUST 2024  
 SCALE: NTS  
 DESIGNED BY: LSM  
 DRAWN BY: LSM  
 HWEI NO.: 2020043  
 FILENAME: ED-02

© HAWKINS-WEIR ENGINEERS, INC. 2024