


C:\PW_WORKING\BWW_AMERICAS\0159427\0-03.DWG. 8/27/2024 12:43 PM. FISHER, STEPHON. MF-01

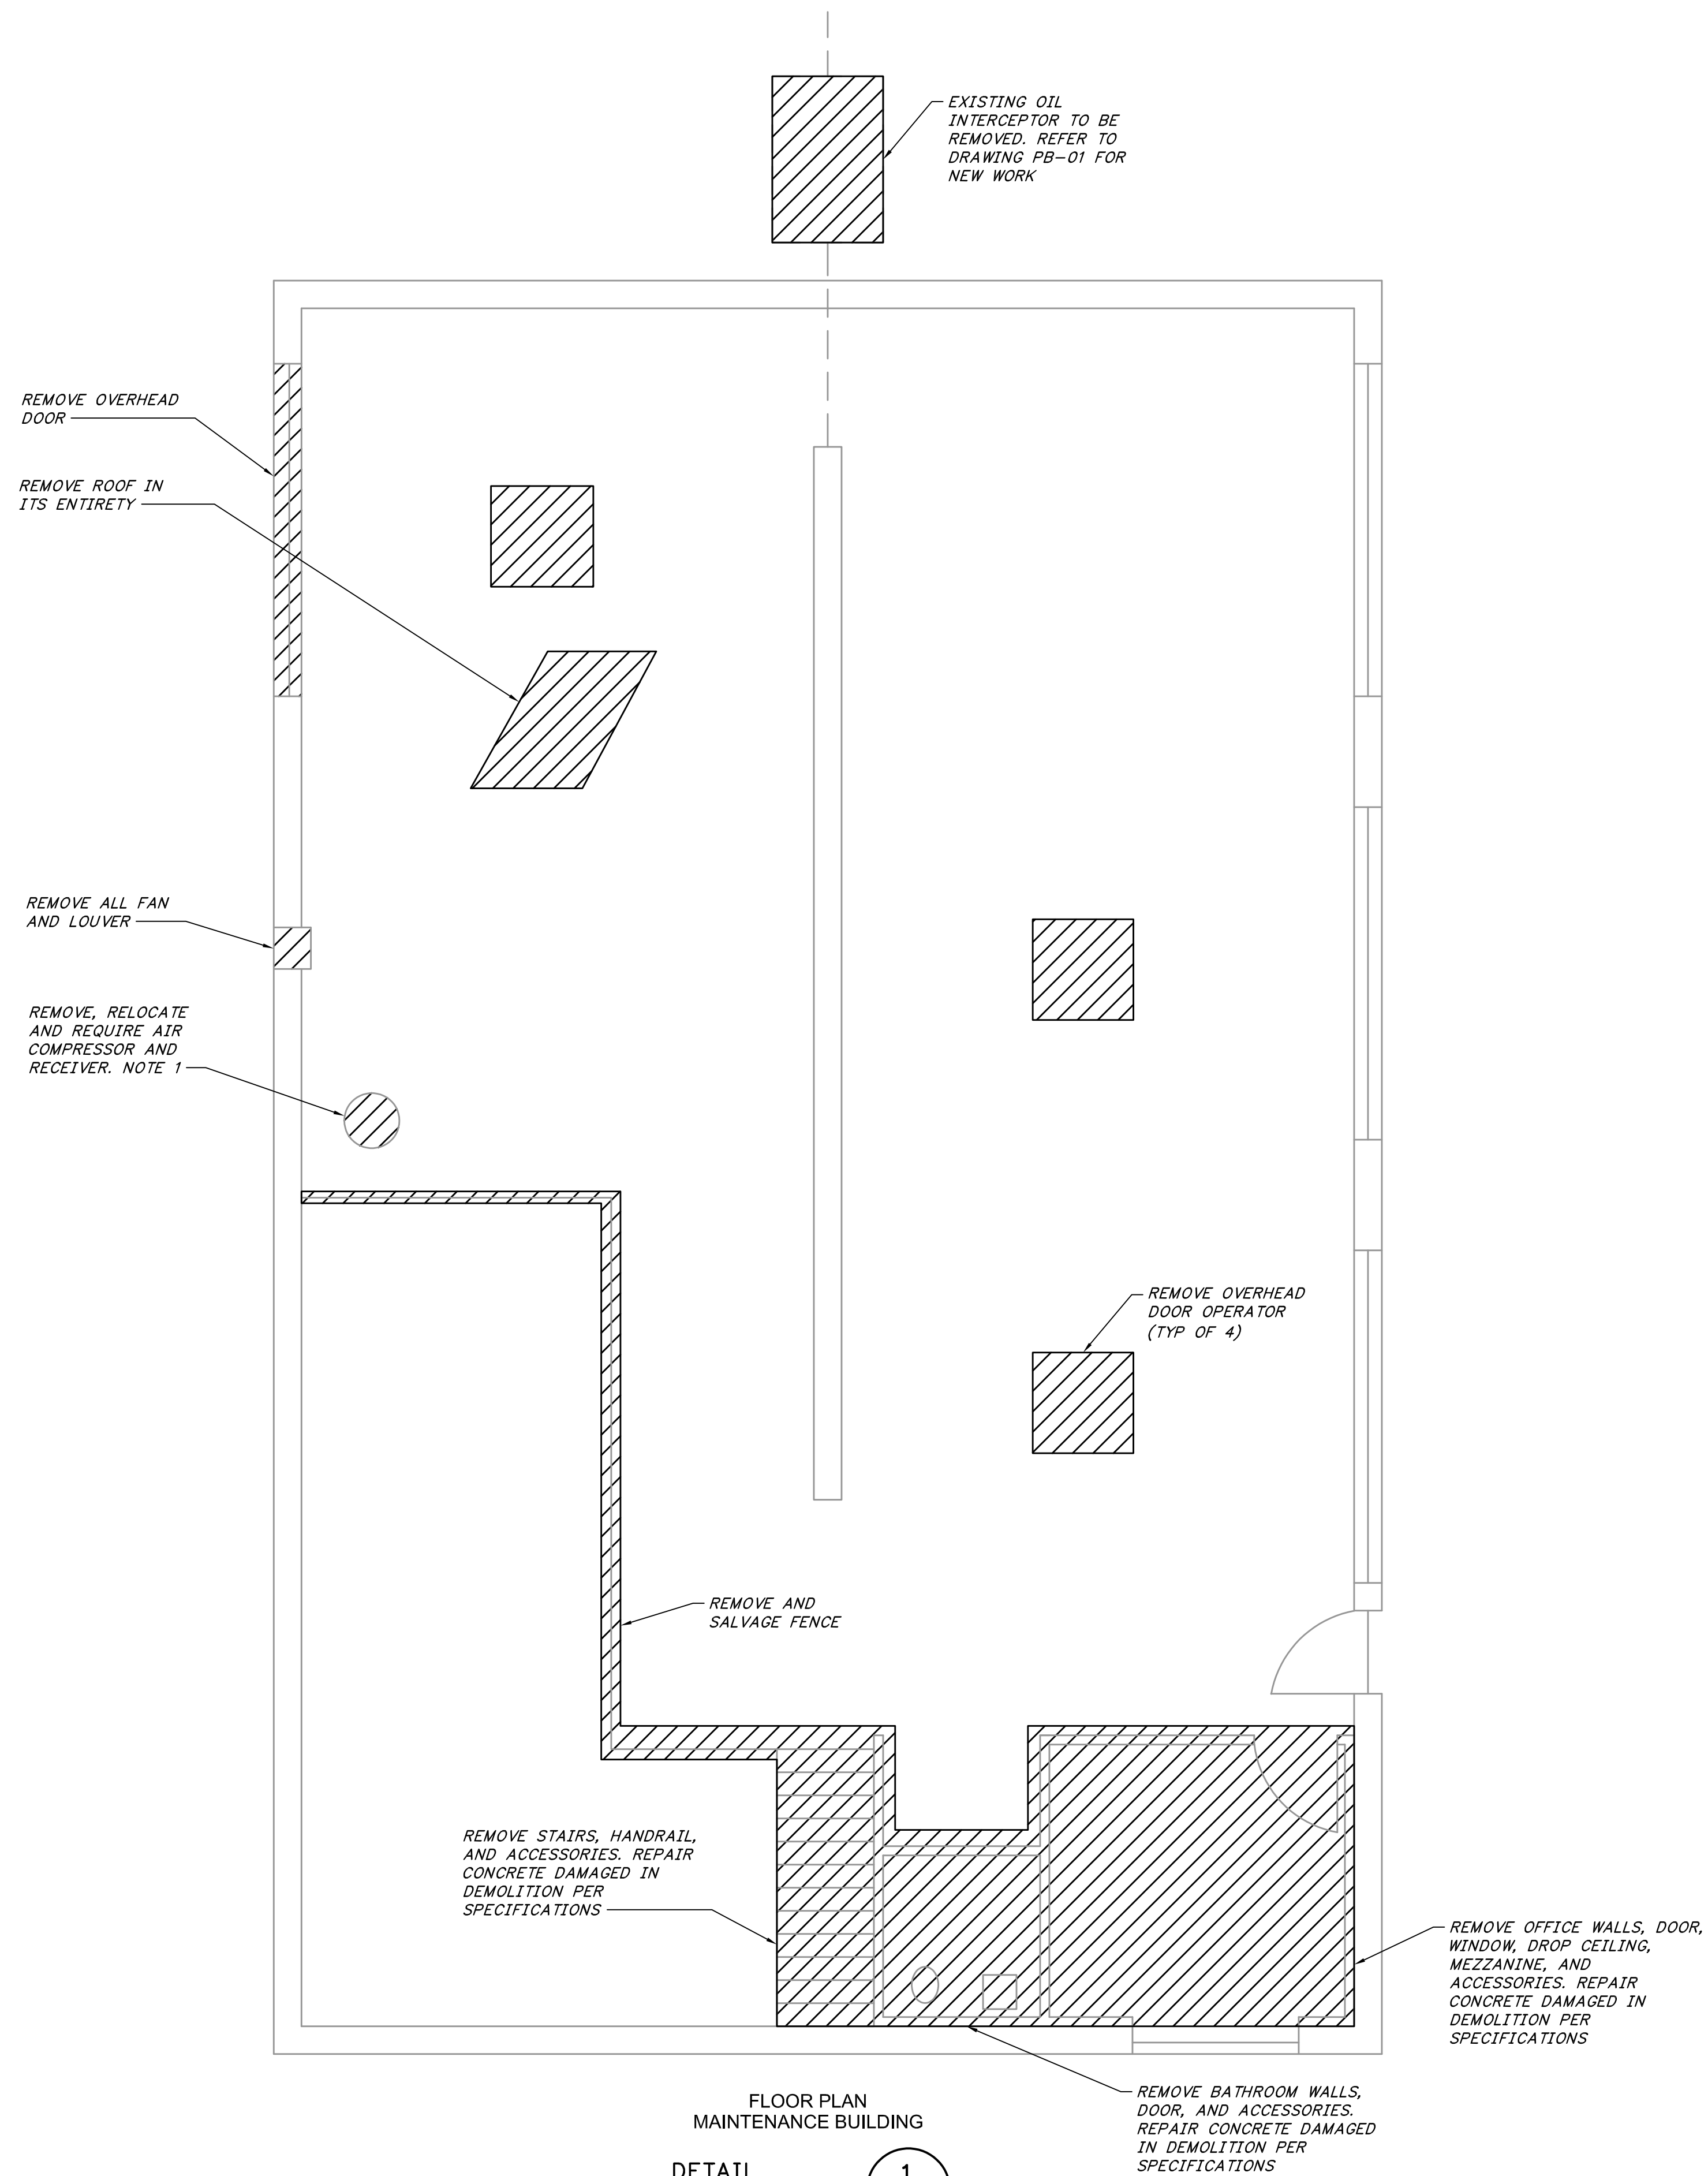

FLOOR PLAN
MAINTENANCE BUILDING
DETAIL 1
1/4" = 1'-0"

NOTES
1. CONTRACTOR TO COORDINATE WITH ROGERS WATER UTILITIES FOR LOCATION AND DRAIN REQUIREMENTS FOR COMPRESSOR AND RECEIVER.

1"
ONE INCH AT FULL SIZE IF NOT ONE INCH SCALE ACCORDINGLY

DATE	REVISION



HAWKINS WEIR ENGINEERS, INC.
BLACK & VEATCH

ROGERS, ARKANSAS
ROGERS POLLUTION CONTROL FACILITY (RPF)
SOLIDS HANDLING IMPROVEMENTS, PHASE II
DEMOLITION FLOOR PLAN
MAINTENANCE BUILDING
FOR: ROGERS WATER UTILITIES

DATE: AUGUST 2024
SCALE: 1/4" = 1'-0"
DESIGNED BY: LRO
DRAWN BY: AIP
HWEI NO.: 2020043
FILENAME:

SHEET NO.
D-03