


C:\USERS\RAMB3010\APPDATA\LOCAL\AUTODESK\AUTOCAD PLANT 3D\COLLABORATION\CACHE\406493\PID.DWG\G-19.DWG 8/21/2024 10:04 AM RAMSEY, JUSTIN W. LAYOUT

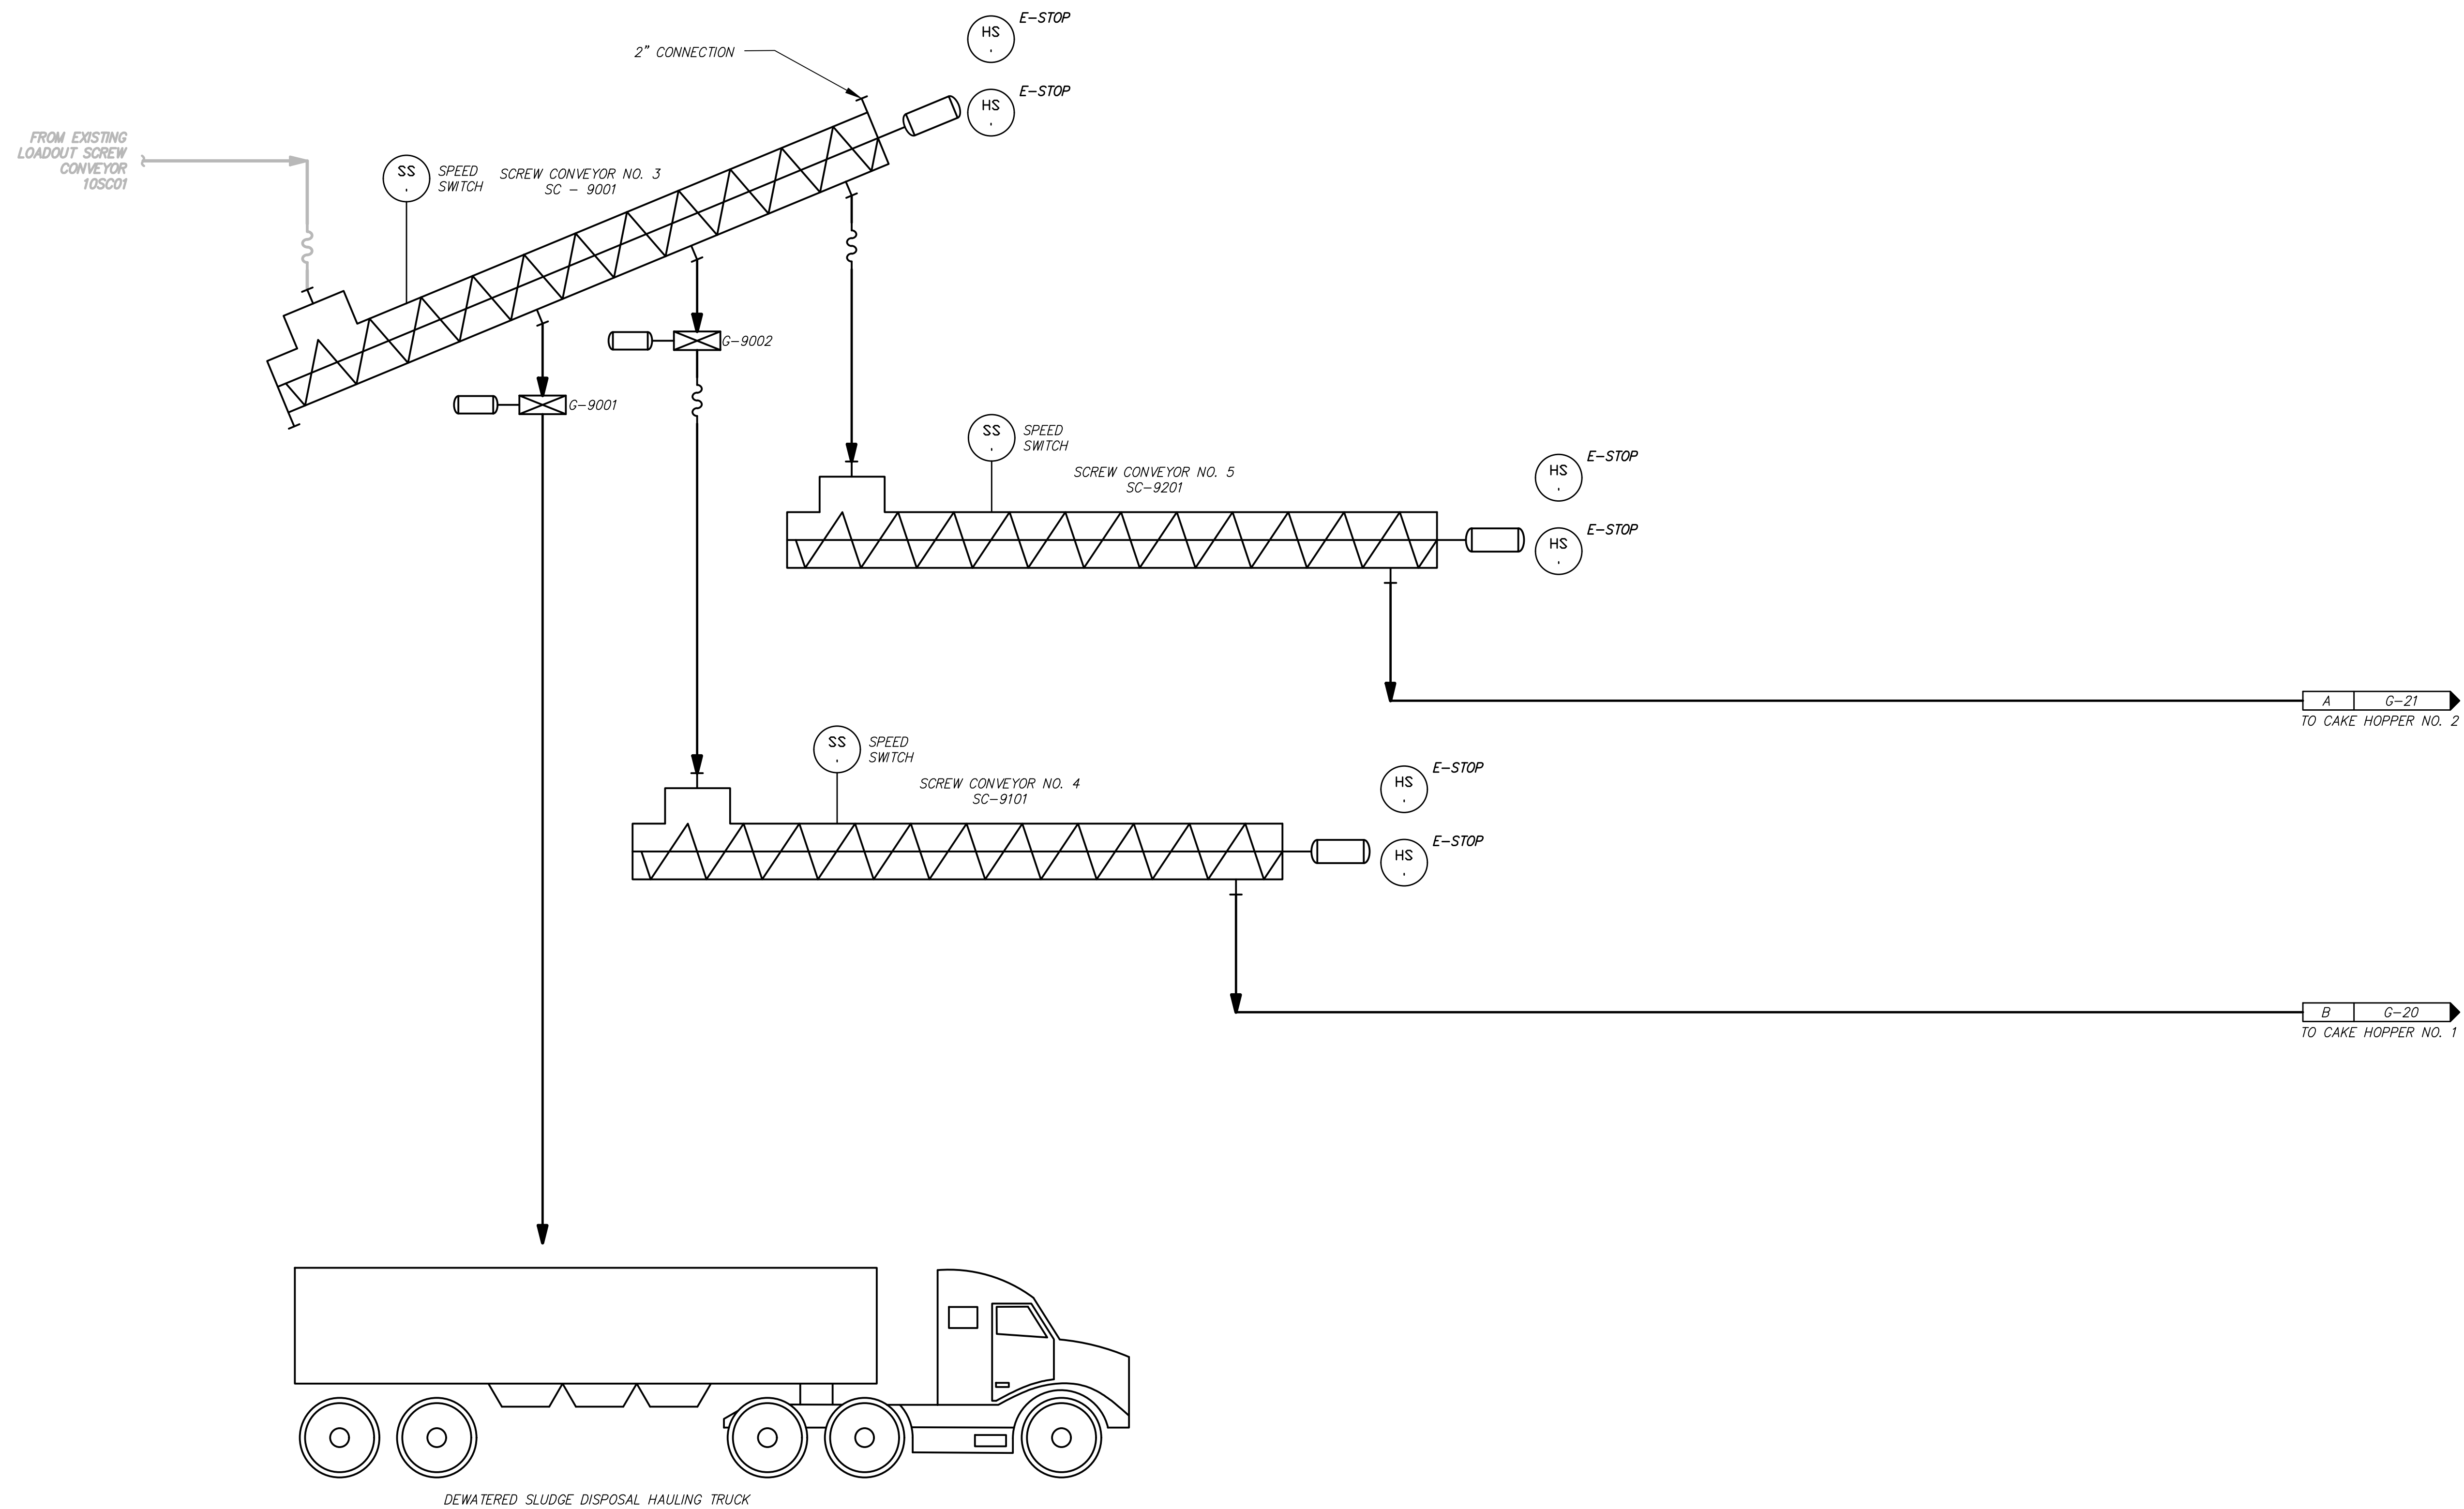

1" ONE INCH AT FULL SIZE IF NOT ONE INCH SCALE ACCORDINGLY

DATE	
REVISION	



**HAWKINS WEIR ENGINEERS, INC.**  
**BLACK & VEATCH**

ROGERS, ARKANSAS  
 ROGERS POLLUTION CONTROL FACILITY (RCF)  
 SOLIDS HANDLING IMPROVEMENTS, PHASE II  
 PROCESS FLOW DIAGRAM  
 SCREW CONVEYORS  
 FOR: ROGERS WATER UTILITIES

DATE: AUGUST 2024  
 SCALE: NONE  
 DESIGNED BY: LRO  
 DRAWN BY: AWR  
 HWEI NO.: 2020043  
 FILENAME:

SHEET NO.  
**G-19**