

ONE INCH
AT FULL SIZE
IF NOT ONE INCH
SCALE ACCORDINGLY

DATE	
REVISION	




HAWKINS WEIR ENGINEERS, INC.
BLACK & VEATCH

ROGERS, ARKANSAS
 ROGERS POLLUTION CONTROL FACILITY (RPF)
 SOLIDS HANDLING IMPROVEMENTS, PHASE II
 PROCESS FLOW DIAGRAM
 BOILER NUMBER 2
 FOR: ROGERS WATER UTILITIES

DATE: AUGUST 2024
 SCALE: NONE
 DESIGNED BY: MNH
 DRAWN BY: AWR
 HWEL NO.: 2020043
 FILENAME:

SHEET NO.
G-23

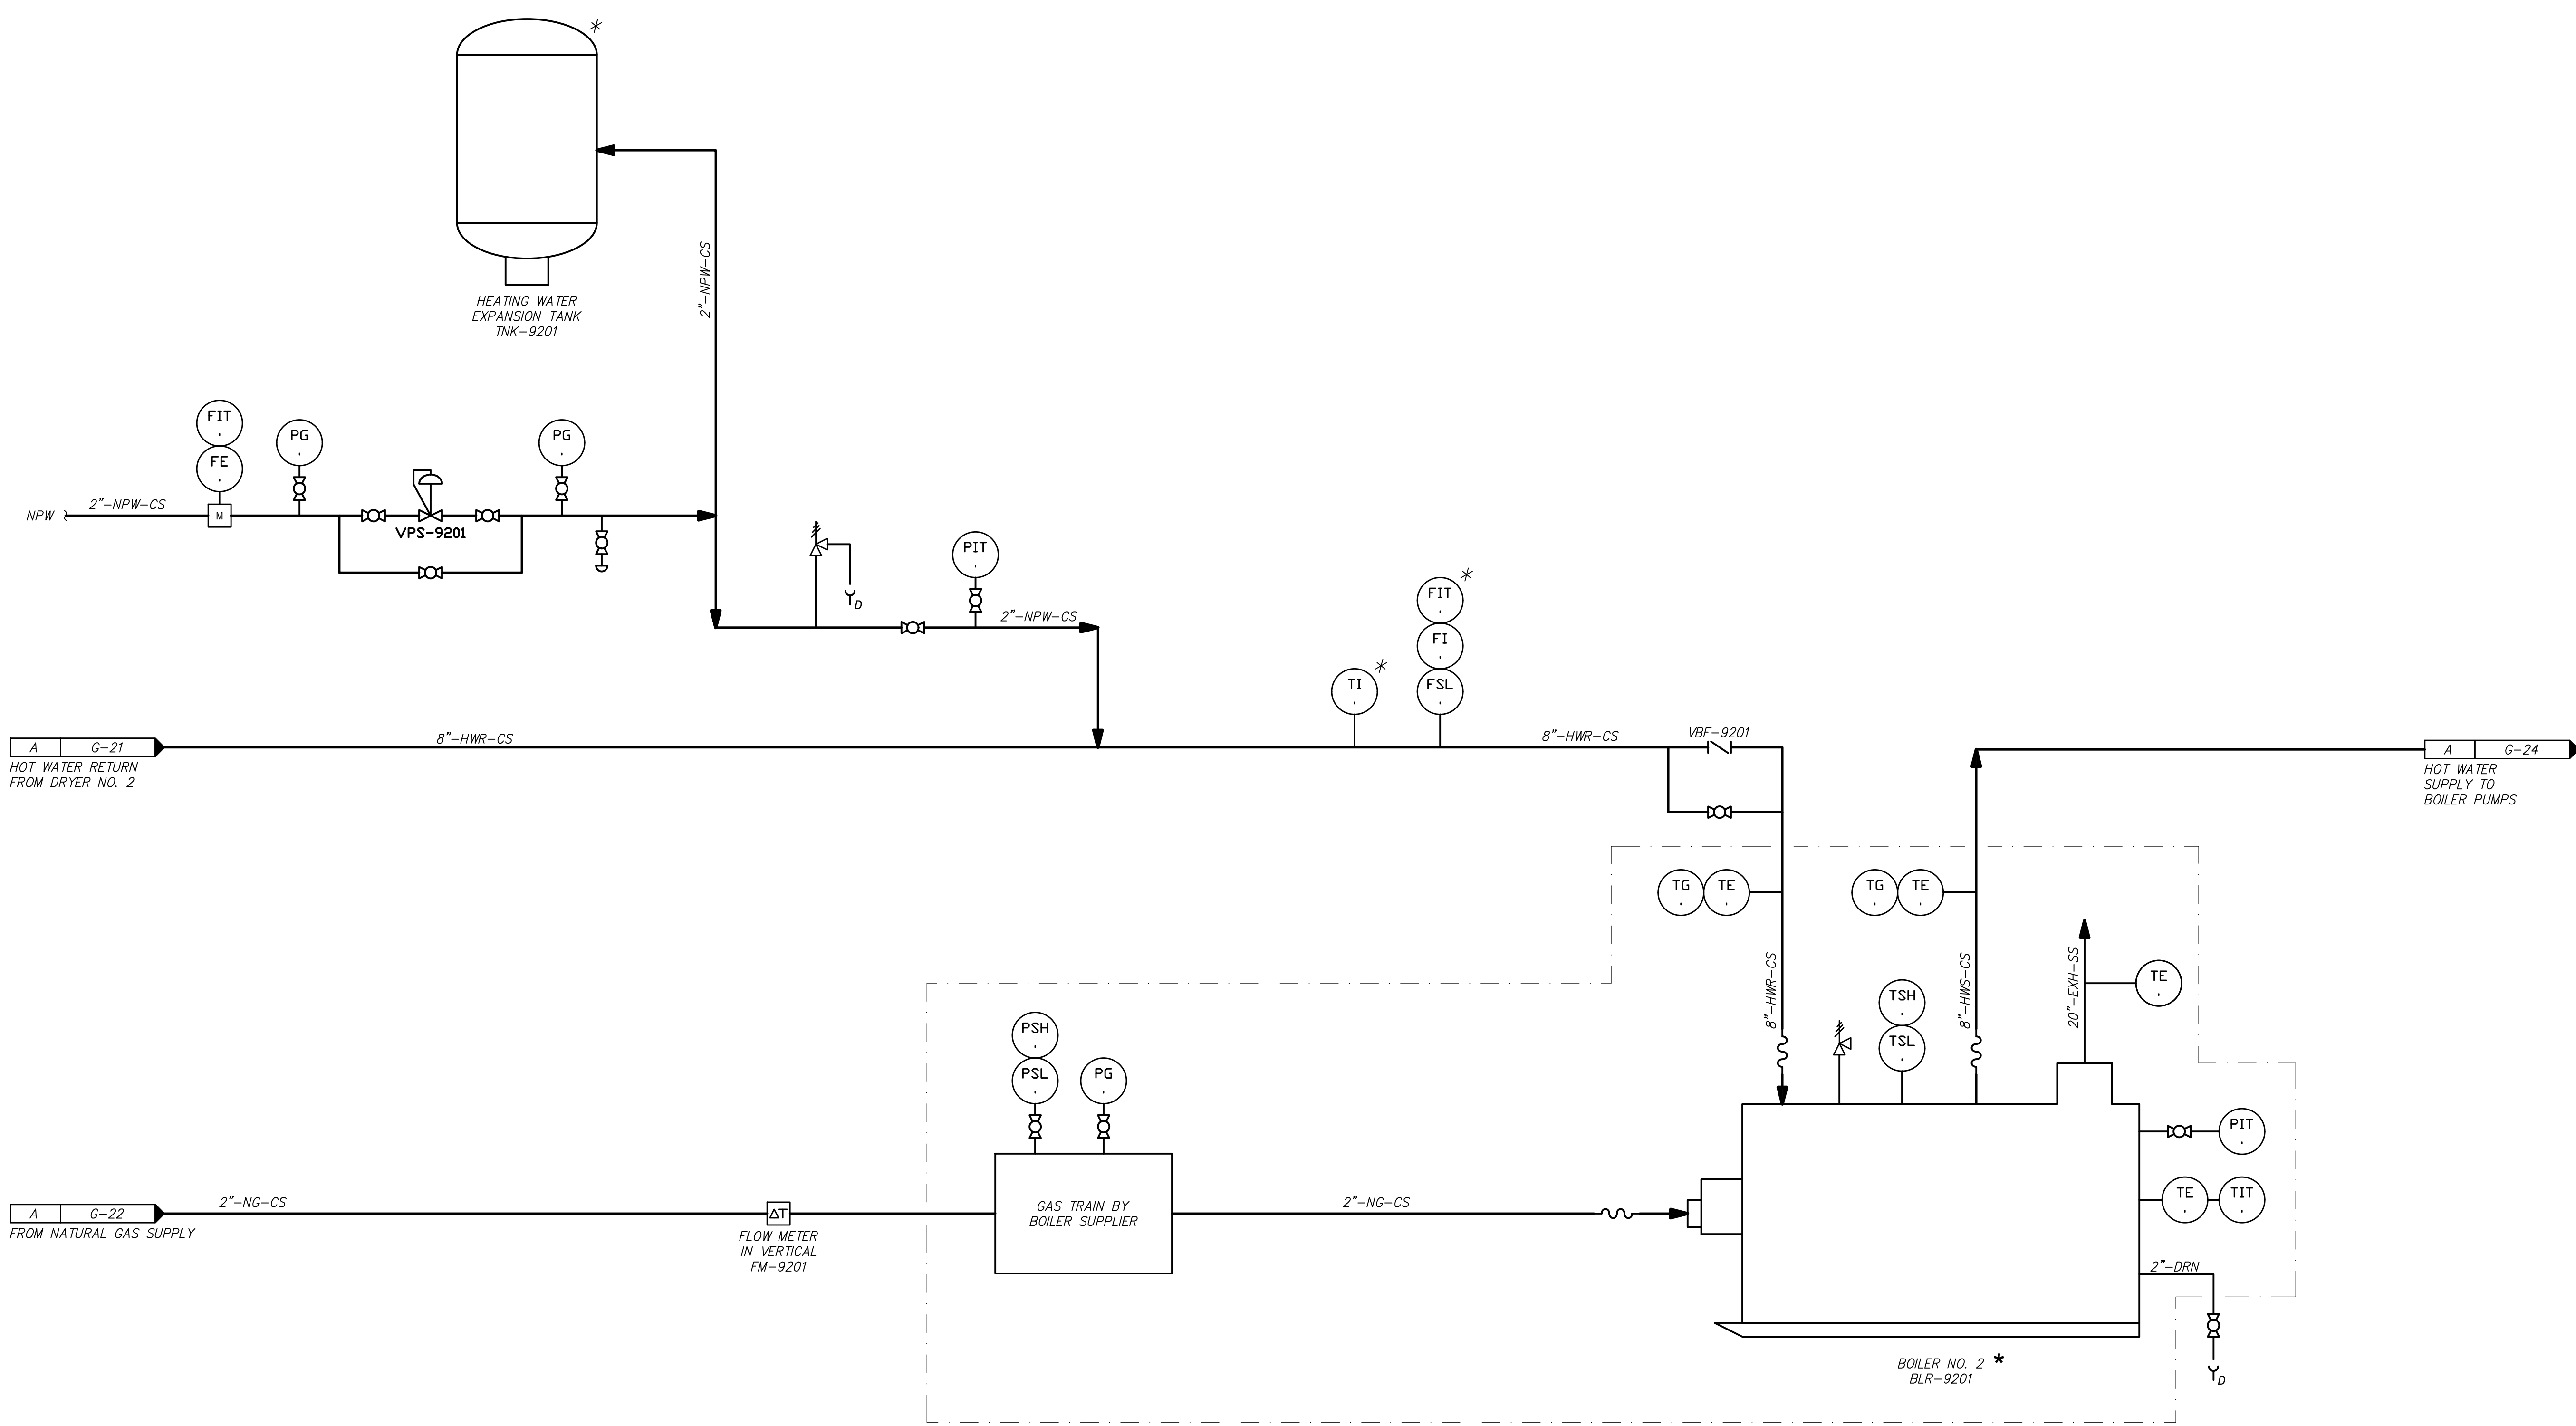

GENERAL NOTES:
 1. ALL ITEMS MARKED WITH AN ASTERISK OR INDICATED BY A DASHED OUTLINE SHALL BE PROVIDED AS PART OF THE THERMAL SLUDGE DRYER SYSTEM BY THE SUPPLIER UNDER APPENDIX A OF THE SPECIFICATIONS.

C:\USERS\RAMB3010\APPDATA\LOCAL\AUTODESK\AUTOCAD PLANT 3D\COLLABORATION\CACHE\406493\PID.DWG\G-23.DWG. 8/21/2024 12:49 PM. RAMBEY, AUSTIN W. LAYOUT