


C:\USERS\RAMB3010\APPDATA\LOCAL\AUTODESK\AUTOCAD PLANT 3D\COLLABORATION\CACHE\406493\PID.DWG\G-24.DWG 8/21/2024 2:10 PM RAMSEY, AUSTIN W. LAYOUT1

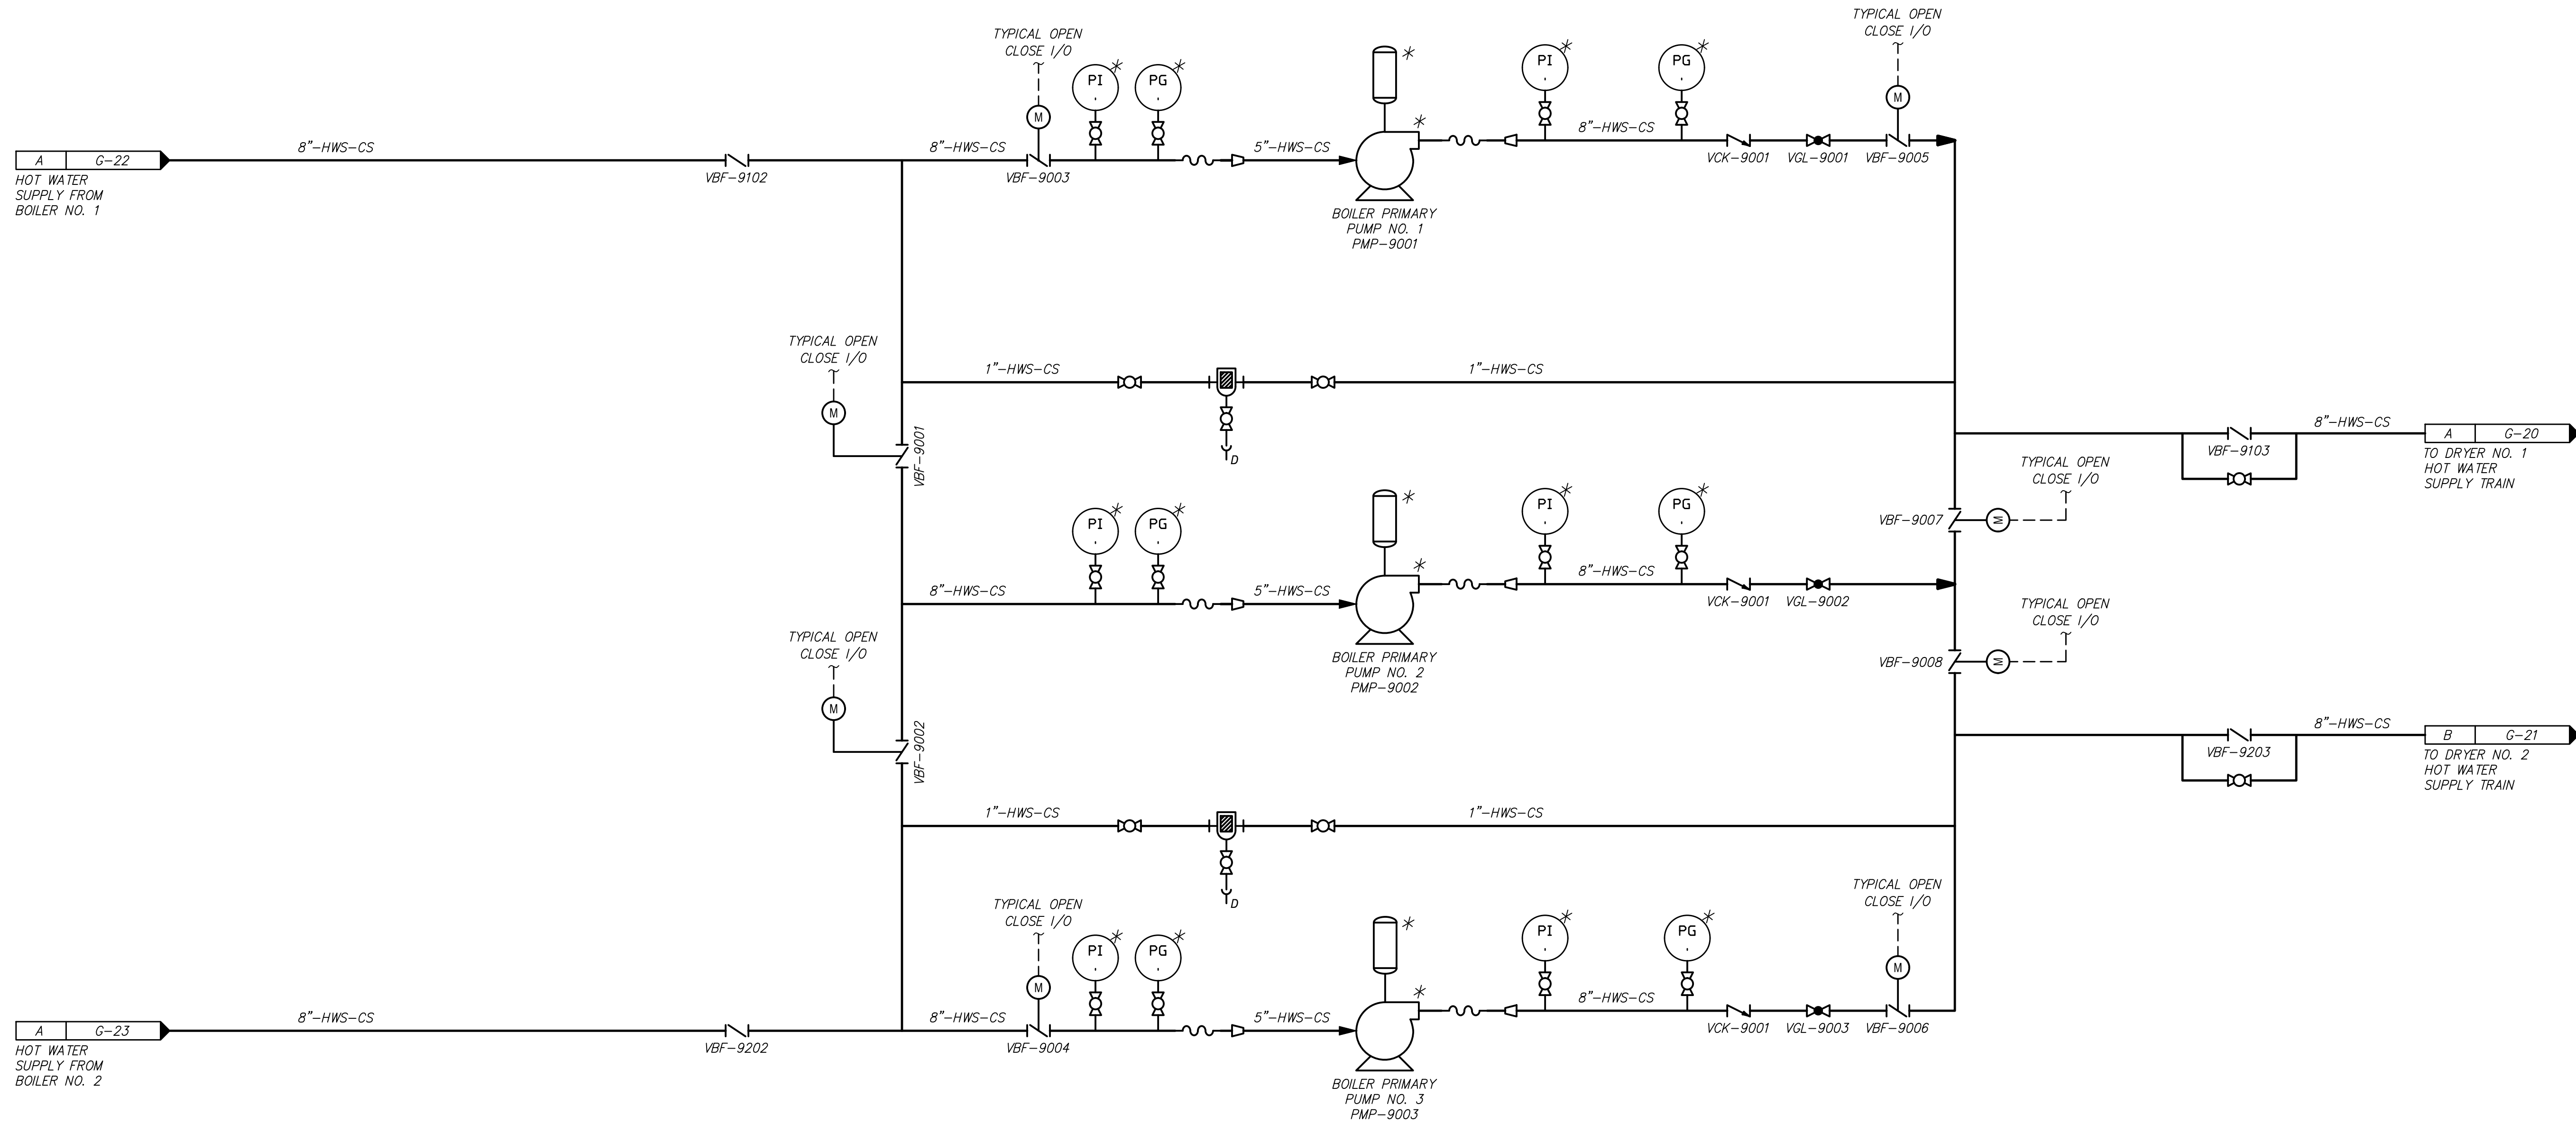

GENERAL NOTES:

1. ALL ITEMS MARKED WITH AN ASTERISK OR INDICATED BY A DASHED OUTLINE SHALL BE PROVIDED AS PART OF THE THERMAL SLUDGE DRYER SYSTEM BY THE SUPPLIER UNDER APPENDIX A OF THE SPECIFICATIONS.

ONE INCH AT FULL SIZE IF NOT ONE INCH SCALE ACCORDINGLY

DATE	
REVISION	



HAWKINS WEIR ENGINEERS, INC.
BLACK & VEATCH

ROGERS, ARKANSAS
 ROGERS POLLUTION CONTROL FACILITY (PCF)
 SOLIDS HANDLING IMPROVEMENTS, PHASE II
 PROCESS FLOW DIAGRAM
 BOILER PUMPS
 FOR: ROGERS WATER UTILITIES

DATE: AUGUST 2024
 SCALE: NONE
 DESIGNED BY: MNH
 DRAWN BY: AWR
 HWEI NO.: 2020043
 FILENAME:

SHEET NO. G-24