


C:\USERS\RAMB301\APPDATA\LOCAL\AUTODESK\AUTOCAD PLANT 3D\COLORADO\AUTOCAD PLANT 3D\COLORADO\AUTOCAD PLANT 3D\406483\PID DWG\G-29.DWG. 8/21/2024 4:30 PM. RAMSEY, AUSTIN W. LAYOUT

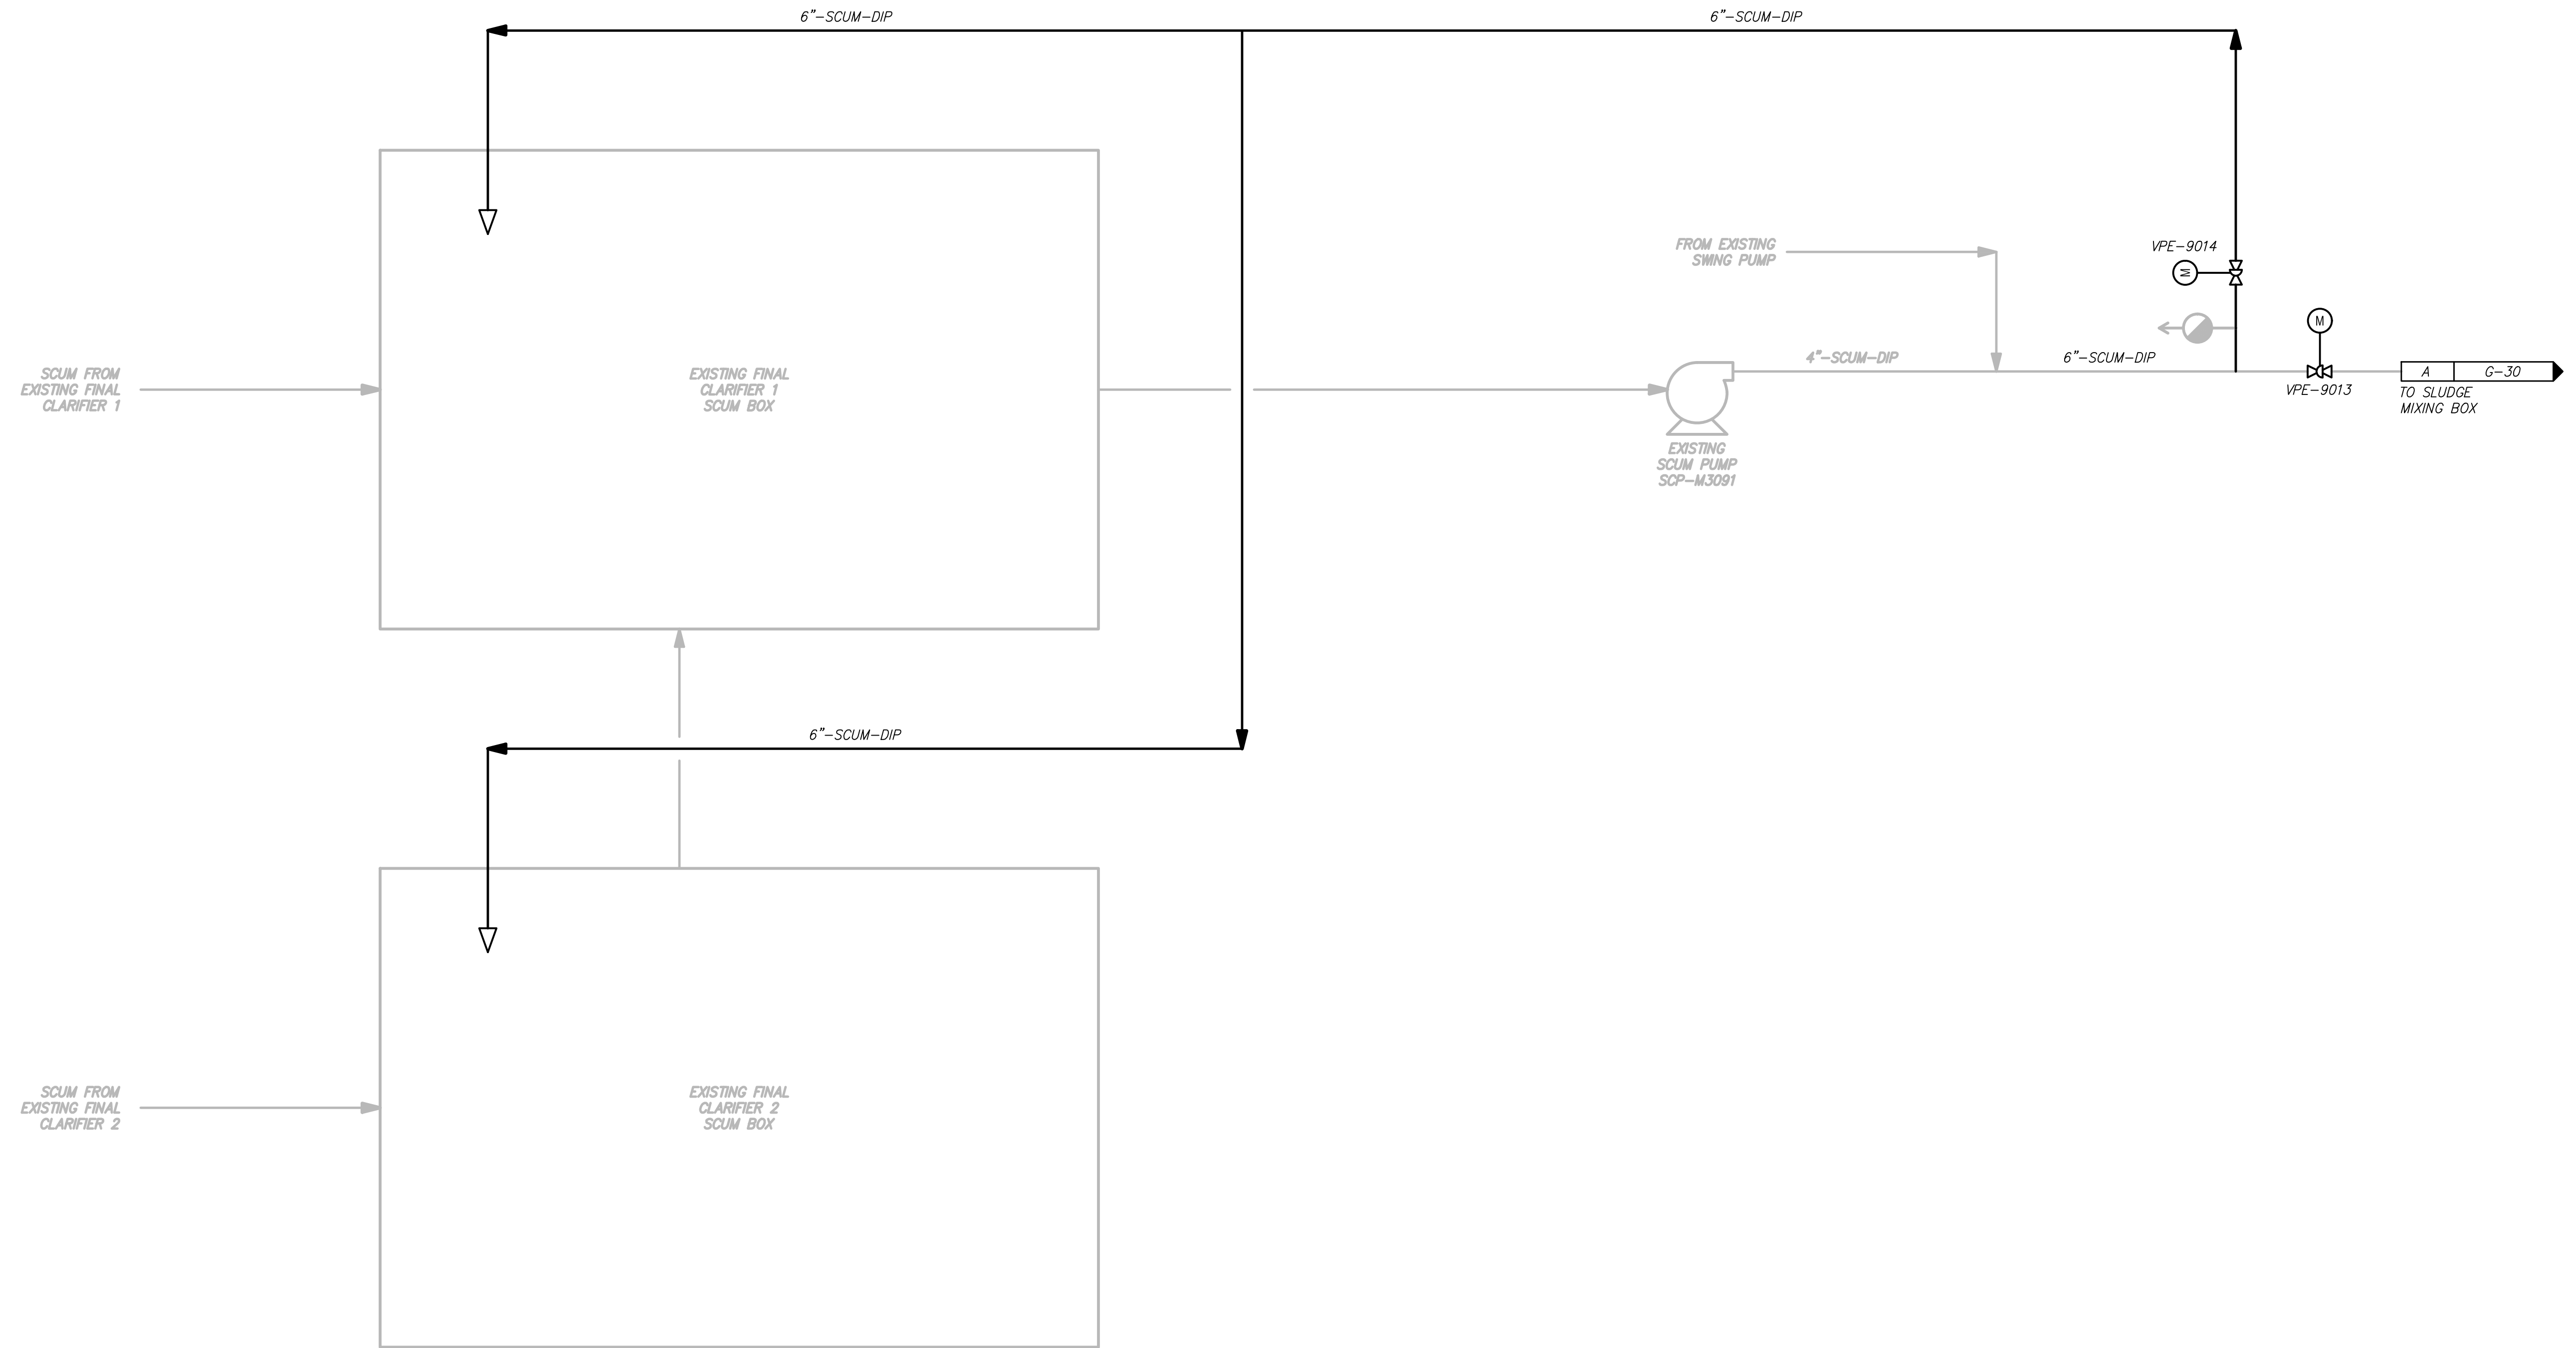

1"

ONE INCH AT FULL SIZE IF NOT ONE INCH SCALE ACCORDINGLY

| DATE | REVISION |
|------|----------|
|      |          |
|      |          |
**HW** HAWKINS WEIR ENGINEERS, INC.

**RV** BLACK & VEATCH

ROGERS, ARKANSAS

ROGERS POLLUTION CONTROL FACILITY (PCF) SOLIDS HANDLING IMPROVEMENTS, PHASE II

PROCESS FLOW DIAGRAM FINAL CLARIFIER SCUM

FOR: ROGERS WATER UTILITIES

DATE: AUGUST 2024

SCALE: NONE

DESIGNED BY: KJJ

DRAWN BY: AWR

HWEI NO.: 2020043

FILENAME: