

ONE INCH
AT FULL SIZE
IF NOT ONE INCH
SCALE ACCORDINGLY

DATE	
REVISION	




HAWKINS WEIR ENGINEERS, INC.
BLACK & VEATCH

ROGERS, ARKANSAS
ROGERS POLLUTION CONTROL FACILITY (RCF)
SOLIDS HANDLING IMPROVEMENTS, PHASE II
PROCESS FLOW DIAGRAM
HEAT EXCHANGERS
FOR: ROGERS WATER UTILITIES

DATE: AUGUST 2024
SCALE: NONE
DESIGNED BY: MNH
DRAWN BY: AWR
HWEI NO.: 2020043
FILENAME:

SHEET NO.
G-31

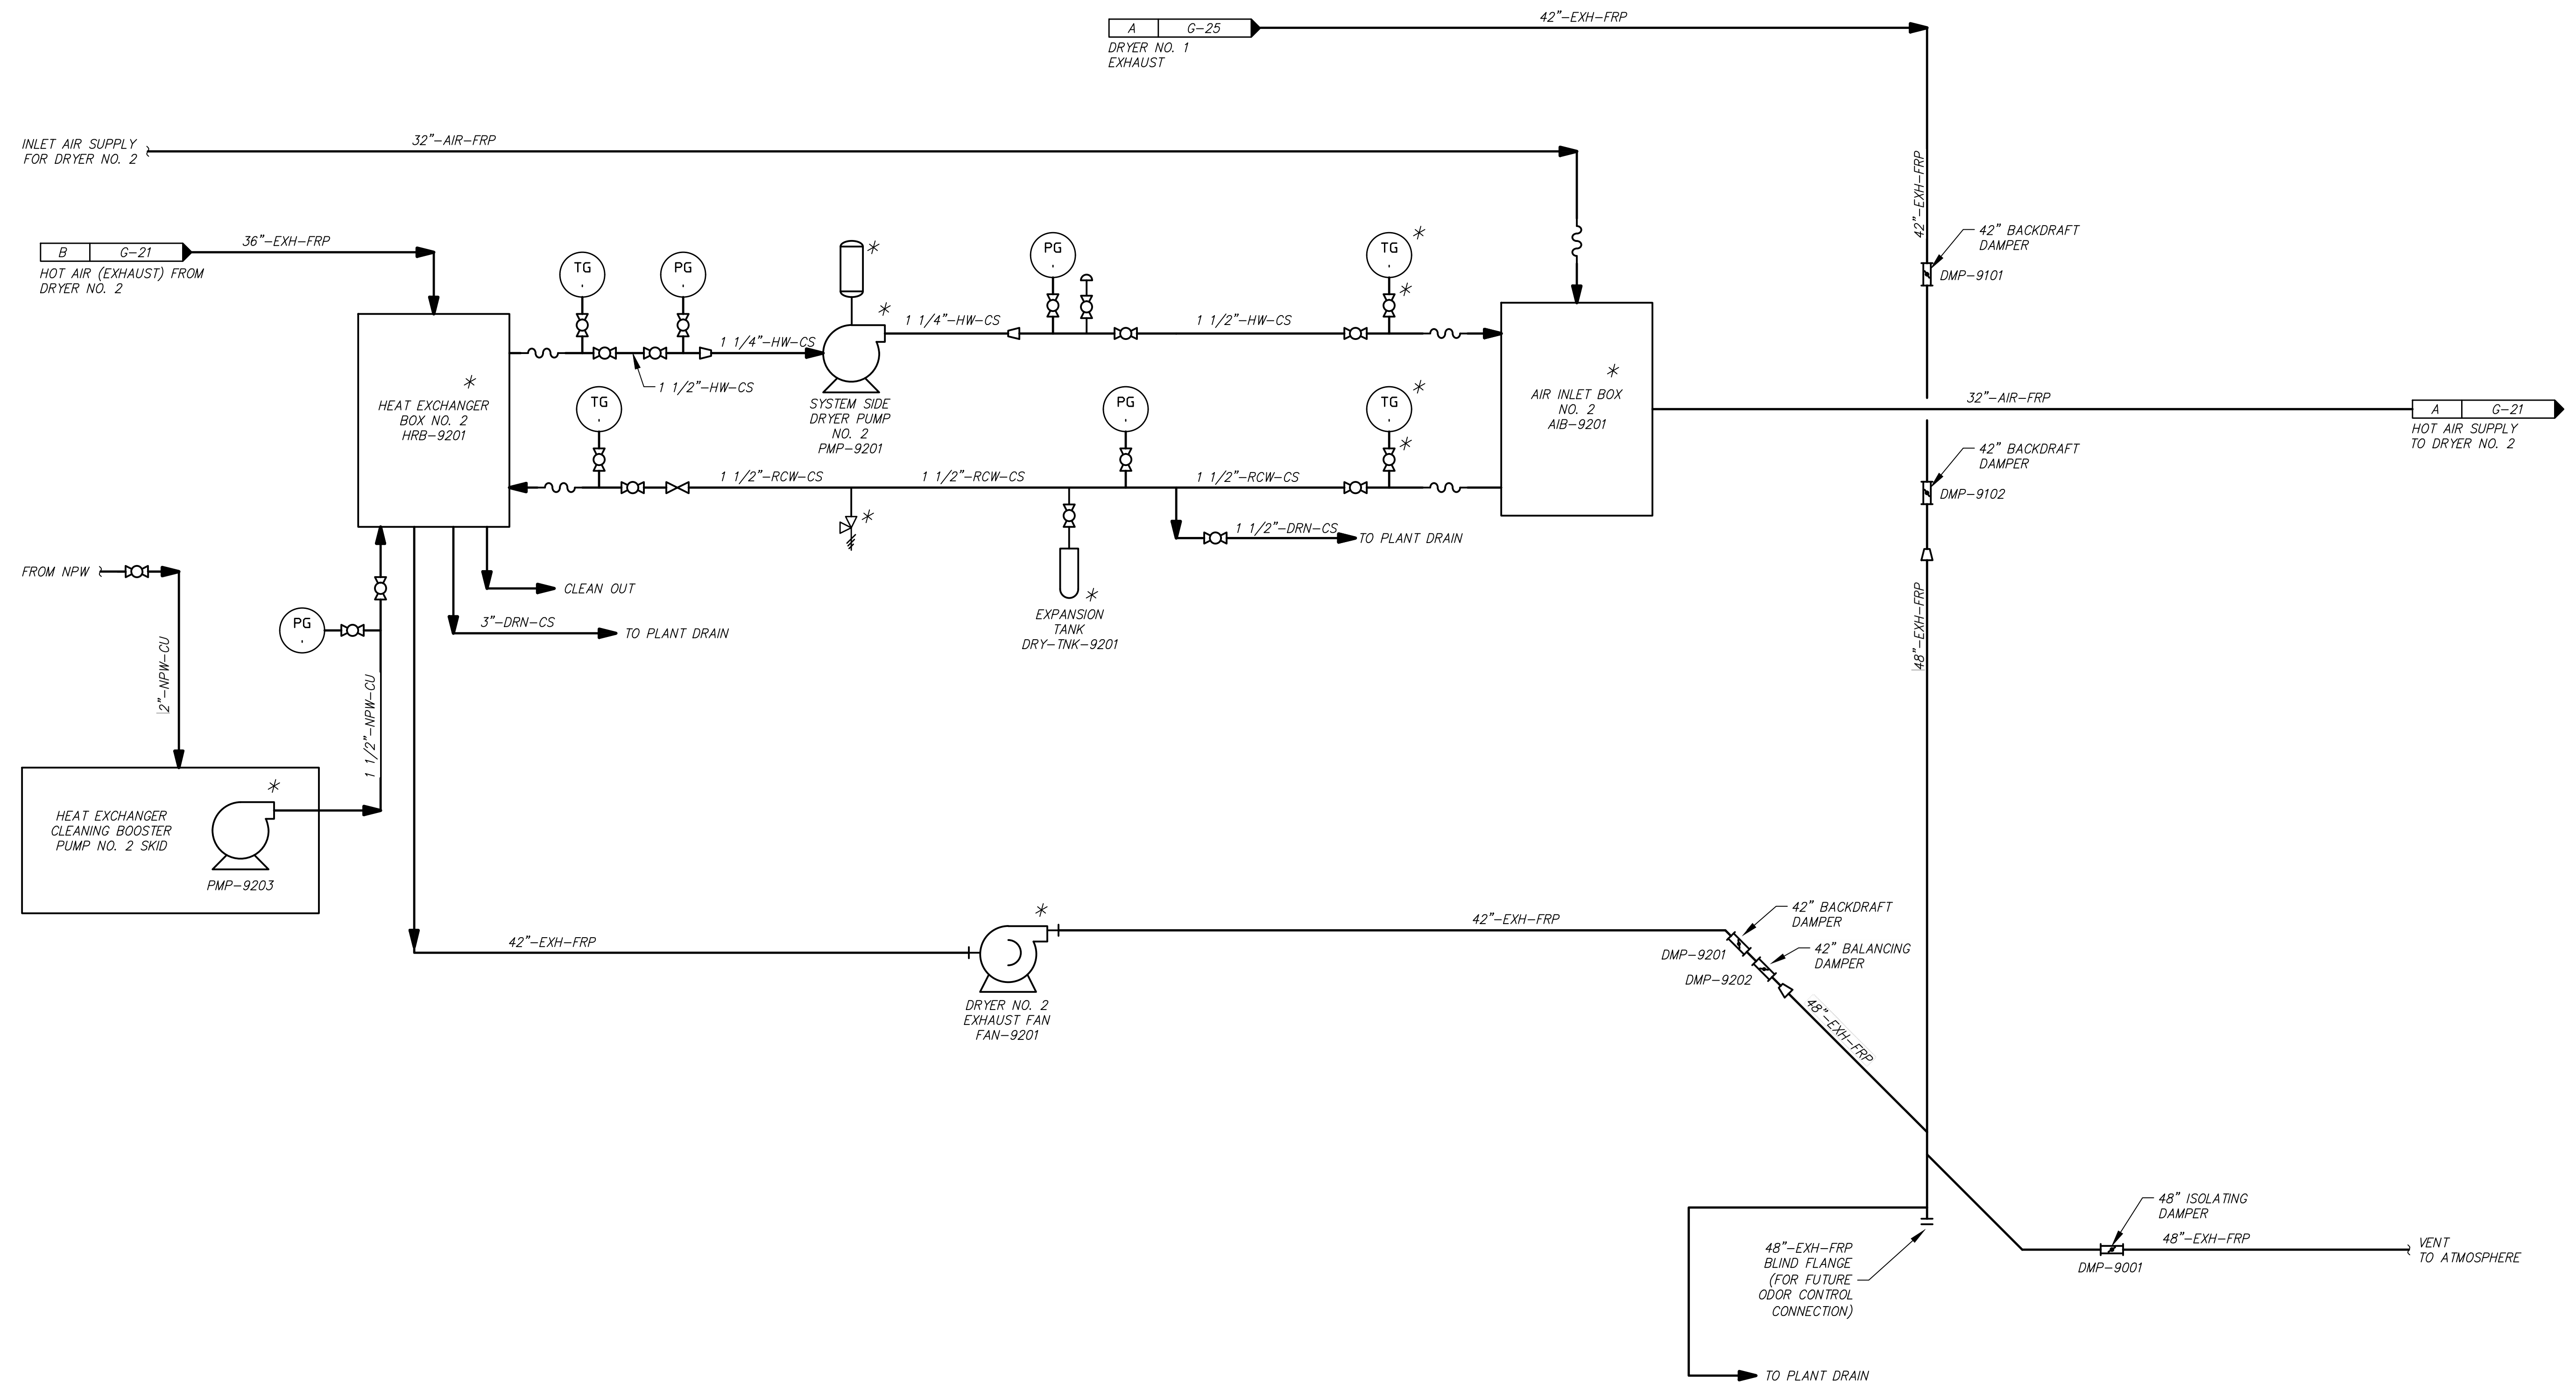

GENERAL NOTES:
1. ALL ITEMS MARKED WITH AN ASTERISK OR INDICATED BY A DASHED OUTLINE SHALL BE PROVIDED AS PART OF THE THERMAL SLUDGE DRYER SYSTEM BY THE SUPPLIER UNDER APPENDIX A OF THE SPECIFICATIONS.

C:\USERS\RAMB3010\APPDATA\LOCAL\AUTODESK\AUTOCAD PLANT 3D\COLORABORATION\CACHE\406493\PID.DWG\G-31.DWG, 8/26/2024, 8:28 PM, RAMSEY, AUSTIN W., LAYOUT