
 


8/27/2024 9:29:54 AM / RLG / DRYER BUILDING

Autodesk Docs://406493 - Rogers PCF Solids Phase 2/406493-Solids Building-BV.rvt

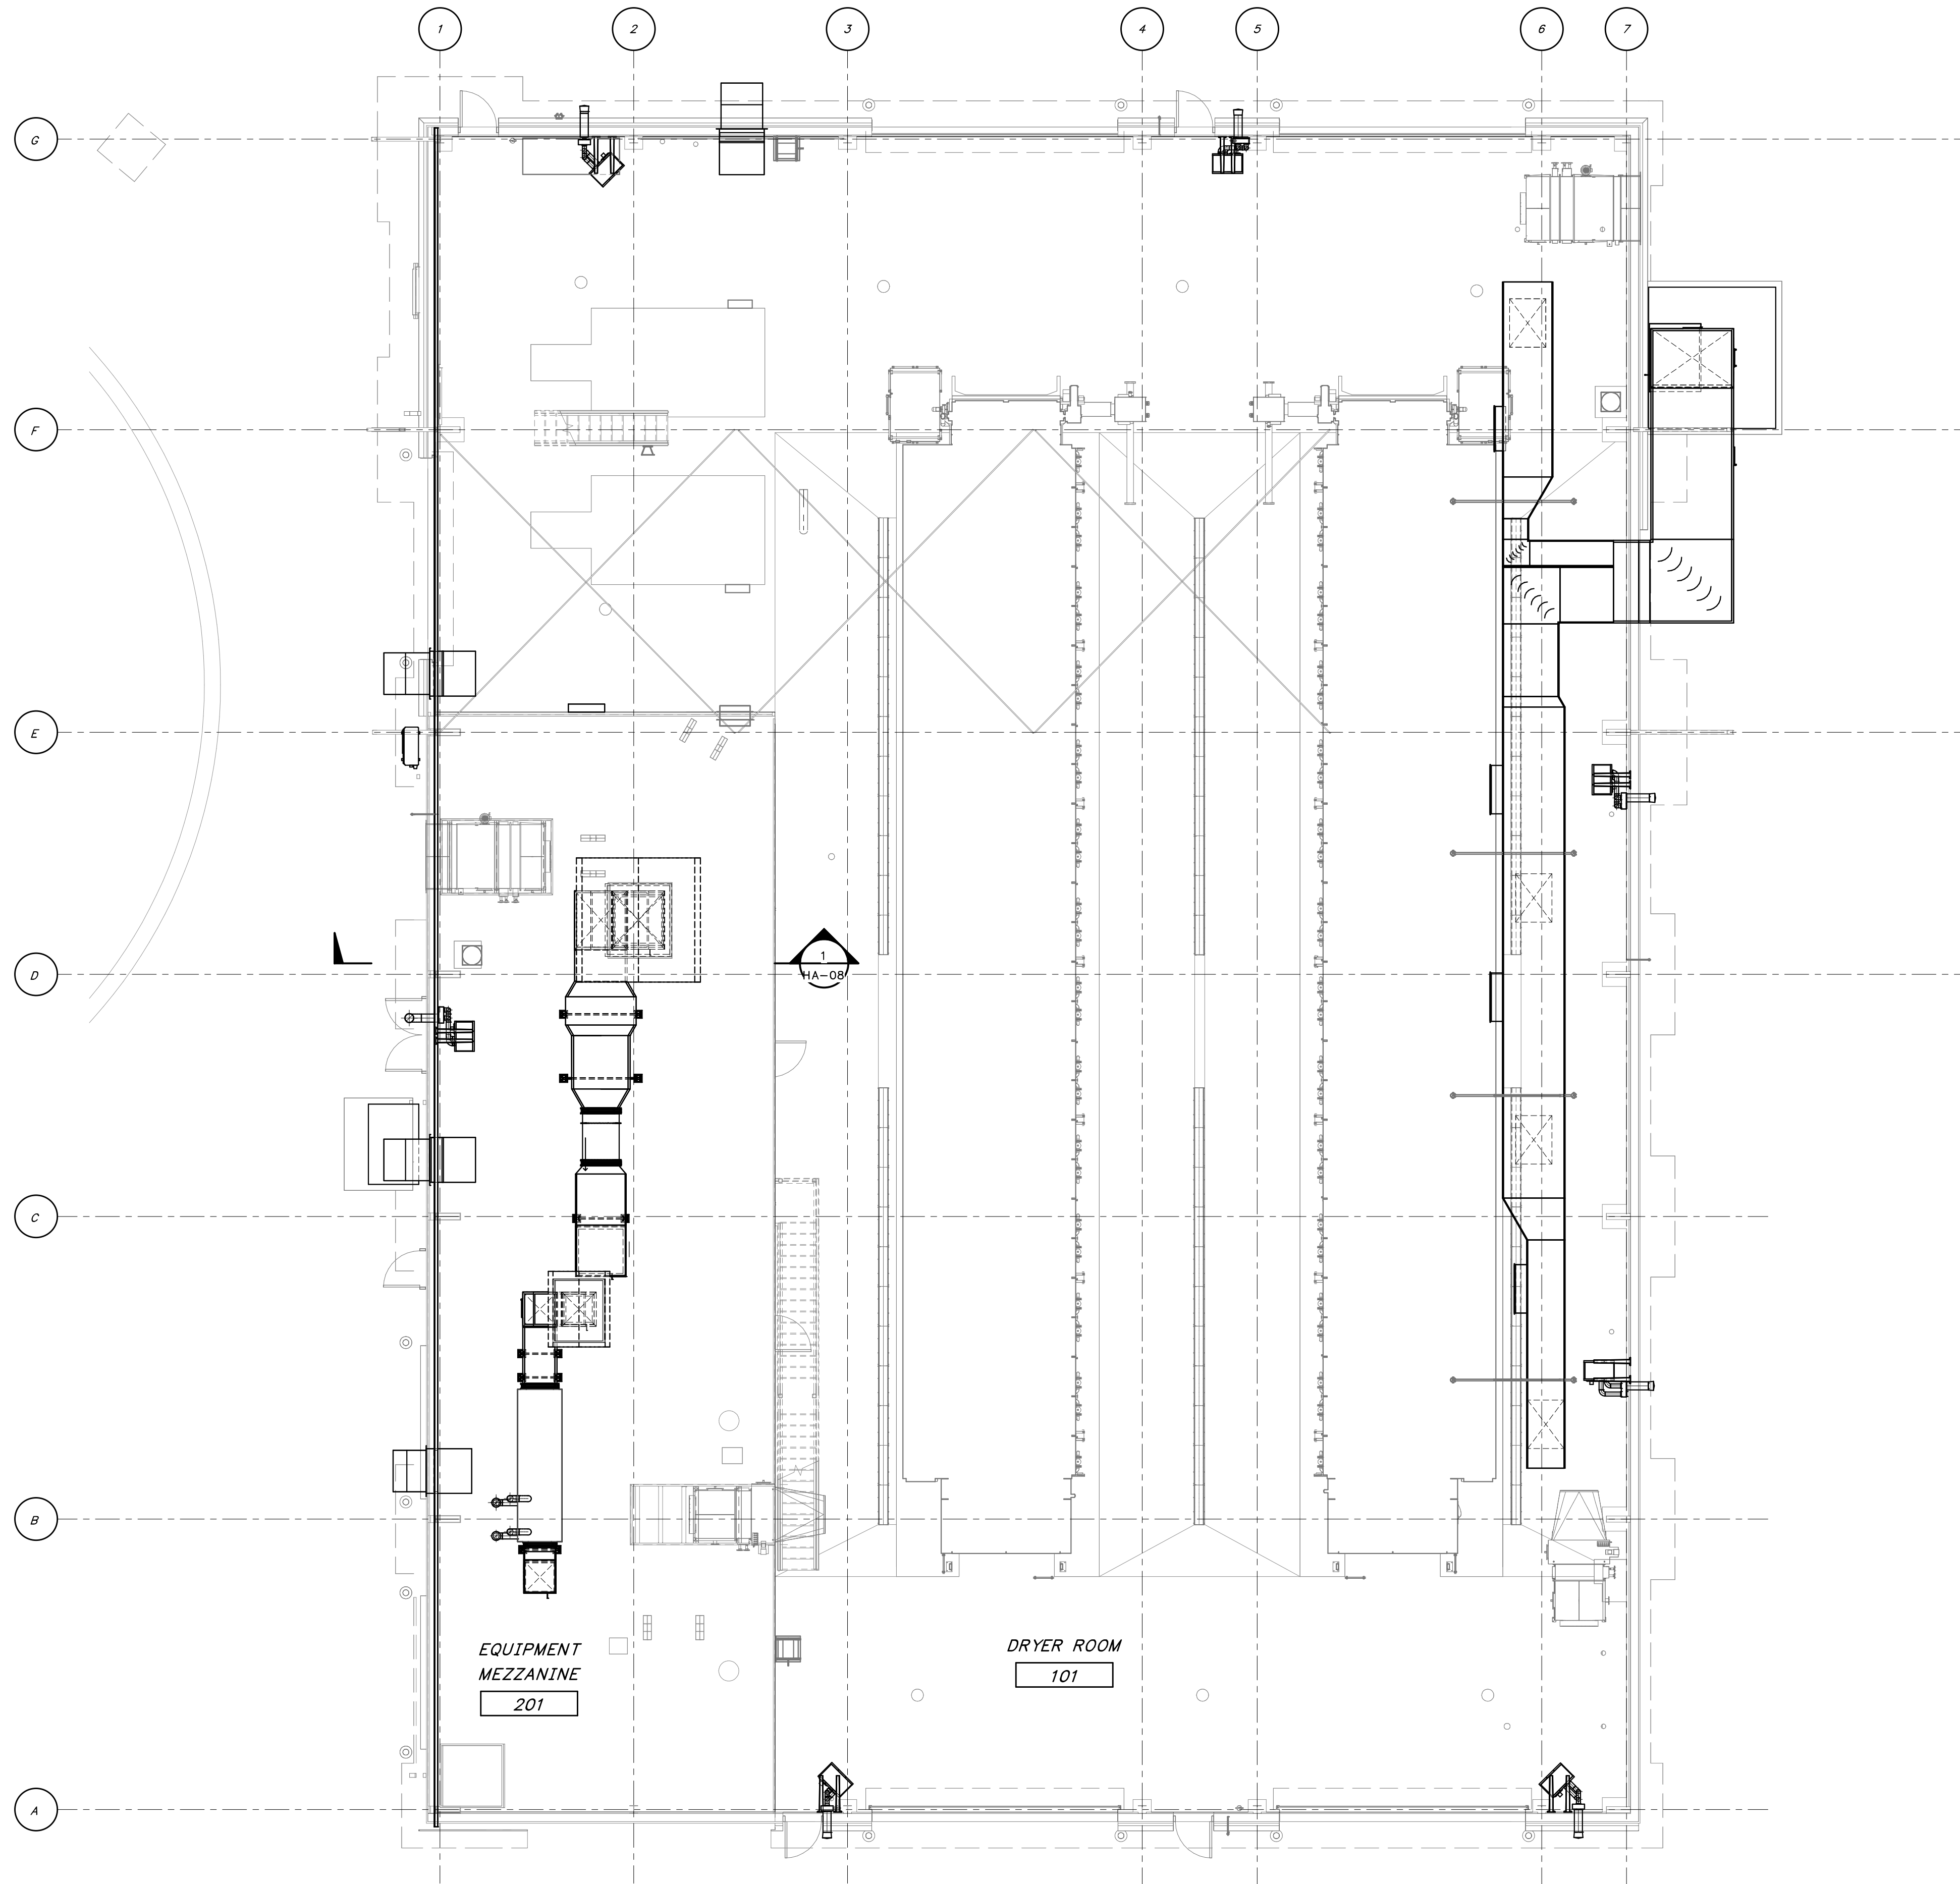


OVERALL - HVAC PLAN
1/8" = 1'-0"



1"
ONE INCH
AT FULL SIZE
IF NOT ONE INCH
SCALE ACCORDINGLY

DATE

REVISION

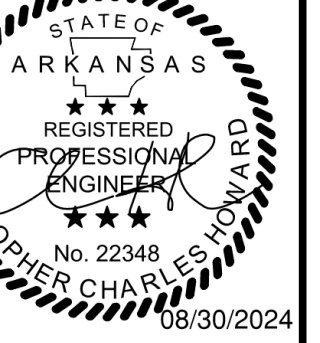

ROGERS, ARKANSAS
ROGERS POLLUTION CONTROL FACILITY (PCF)
SOLIDS HANDLING IMPROVEMENTS, PHASE II

DRYER BUILDING
OVERALL HVAC FLOOR PLAN
FOR: ROGERS WATER UTILITIES

DATE: AUGUST 2024
SCALE: 1/8" = 1'-0"
DESIGNED BY: APC
DRAWN BY: RLG
HWEI NO.: 2020043

FILENAME:
SHEET NO.
HA-02

© HAWKINS-WEIR ENGINEERS, INC. 2023