



8/27/2024 9:30:00 AM / RGL / DRYER BUILDING

Autodesk Docs://406493 - Rogers PCF Solids Phase 2/406493-Solids Building-BV.rvt

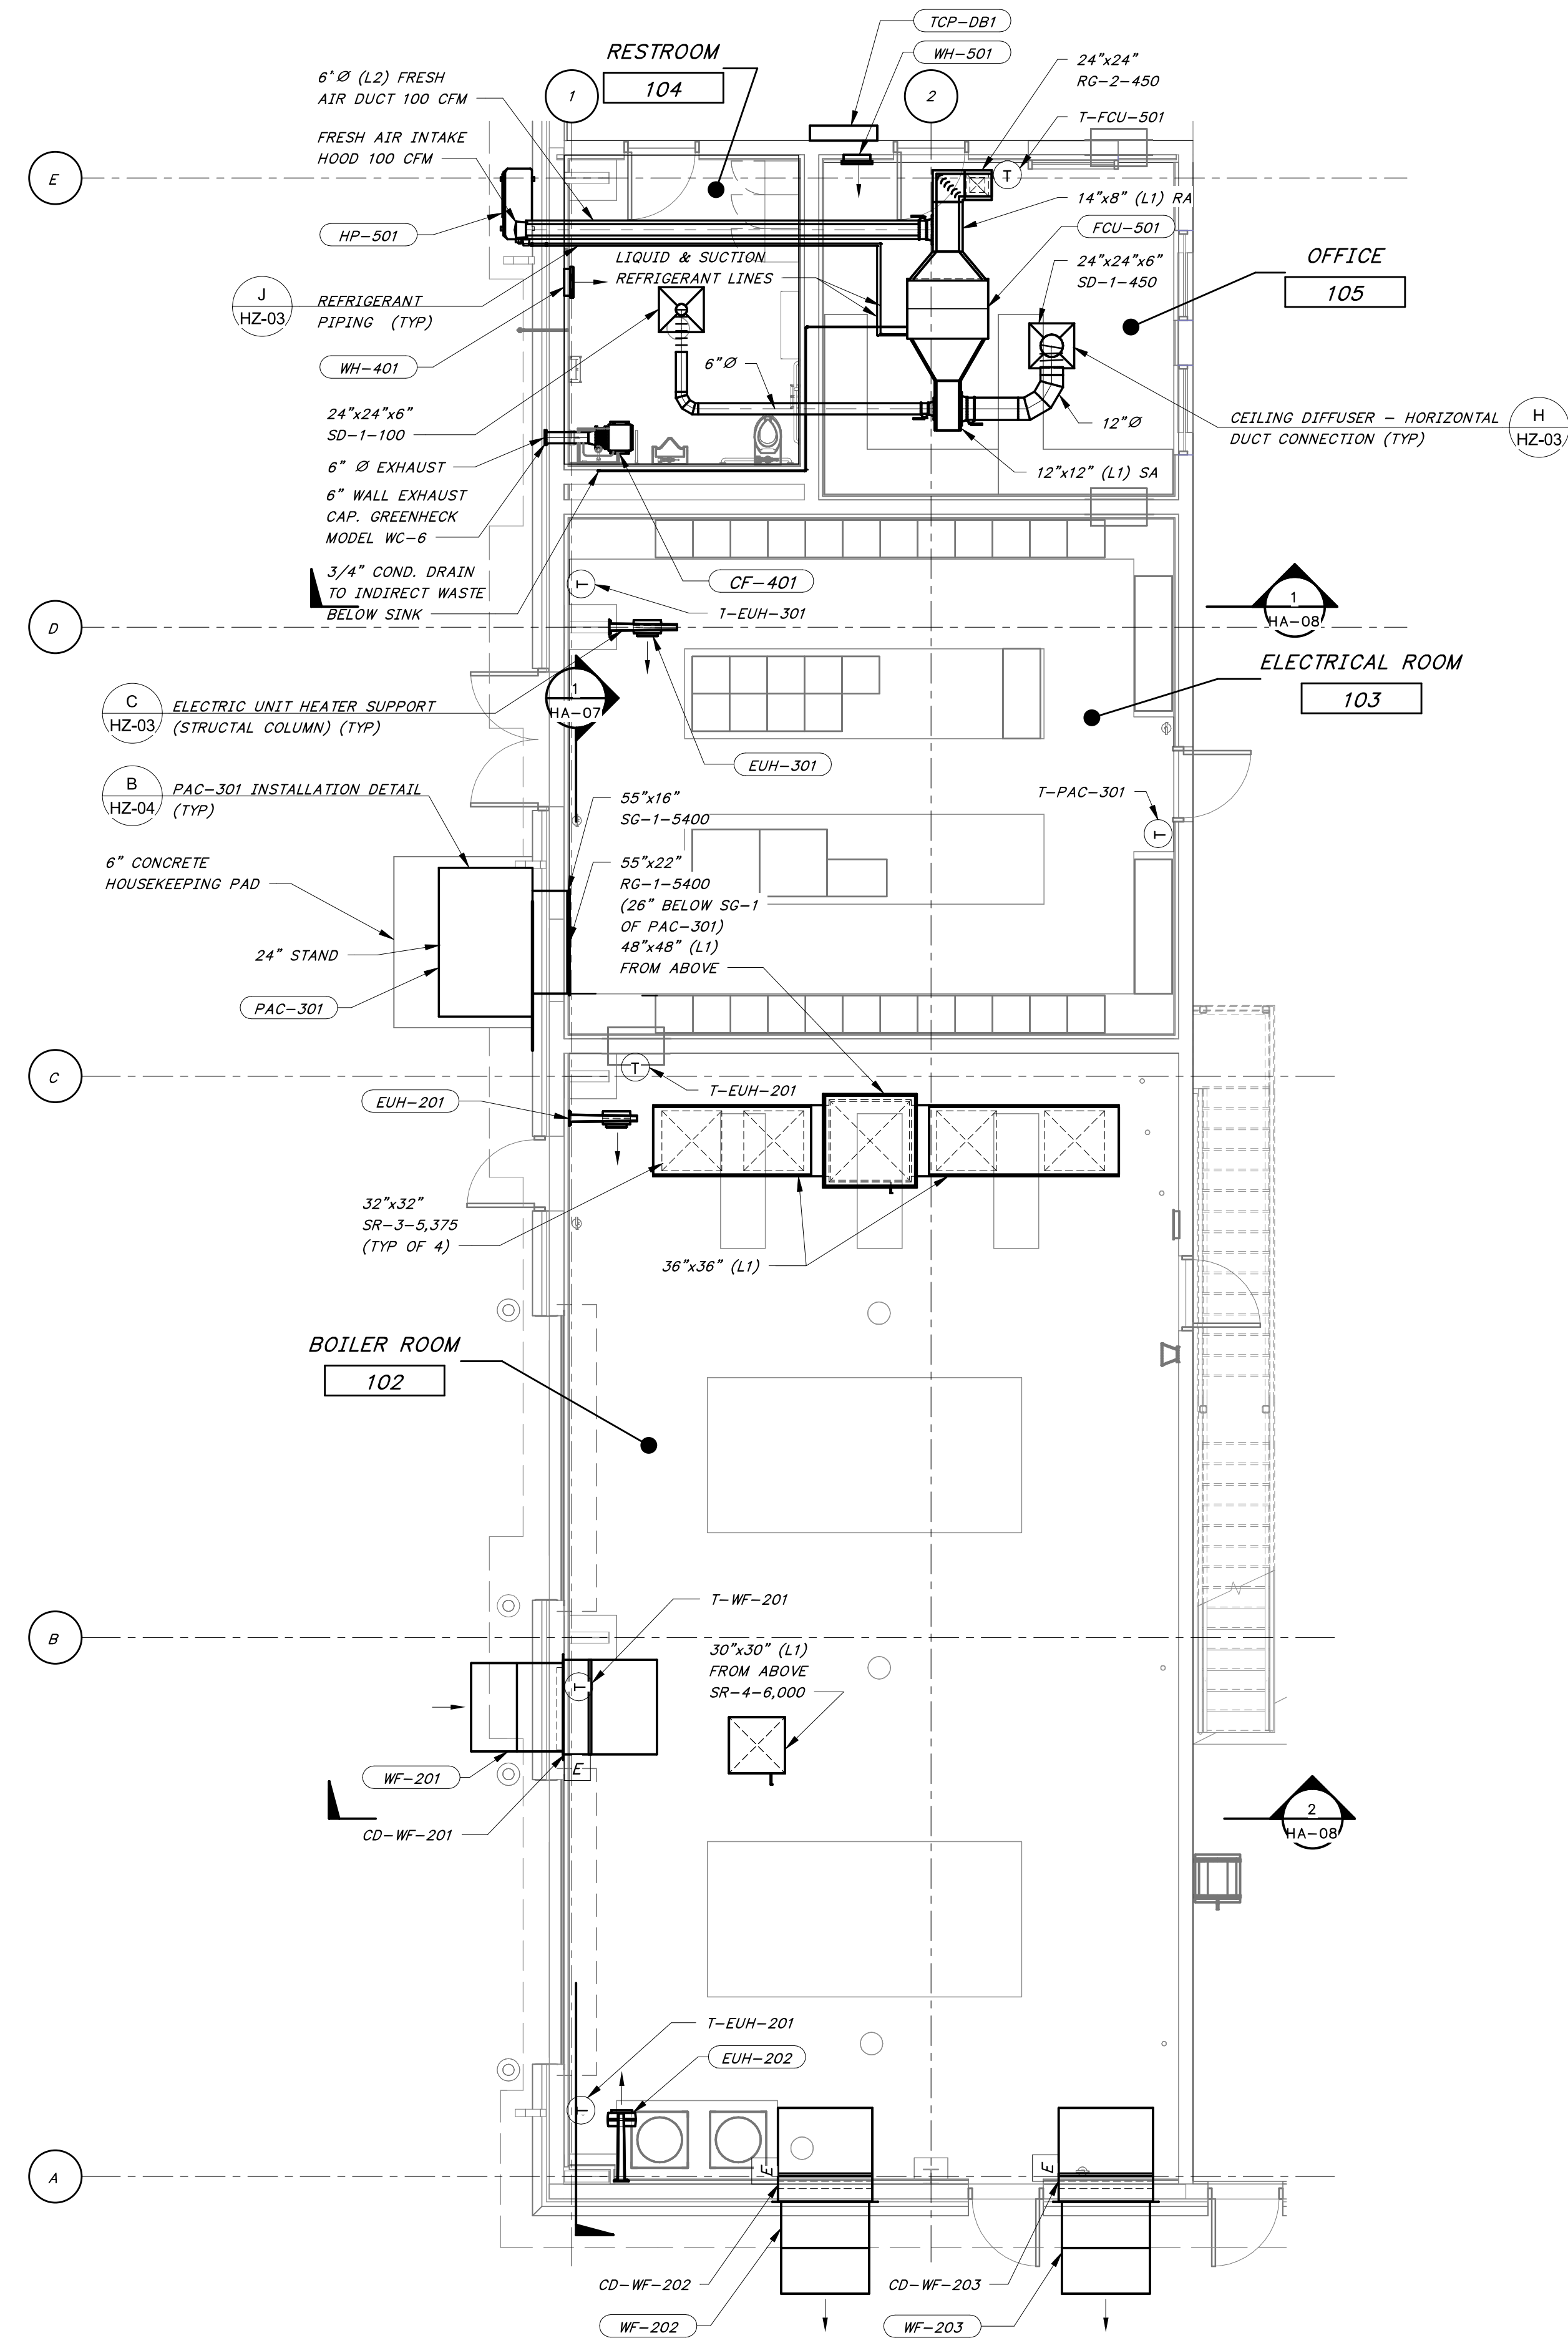

LOWER LEVEL- ENLARGED PLAN
 3/16" = 1'-0"

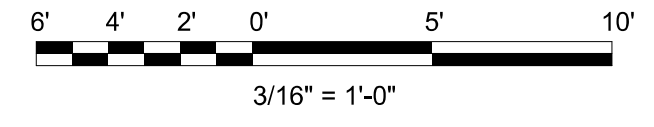

1"
 ONE INCH
 AT FULL SIZE
 IF NOT ONE INCH
 SCALE ACCORDINGLY

DATE	REVISION



HAWKINS-WEIR ENGINEERS, INC.
BLACK & VEATCH

ROGERS, ARKANSAS
 ROGERS POLLUTION CONTROL FACILITY (PCF)
 SOLIDS HANDLING IMPROVEMENTS, PHASE II
 DRYER BUILDING
 ENLARGED HVAC FLOOR PLAN
 LOWER LEVEL PLAN
 FOR: ROGERS WATER UTILITIES

DATE: AUGUST 2024
 SCALE: 3/16" = 1'-0"
 DESIGNED BY: APC
 DRAWN BY: RGL
 HWEI NO.: 2020043
 FILENAME:

SHEET NO.
HA-05

© HAWKINS-WEIR ENGINEERS, INC. 2023