
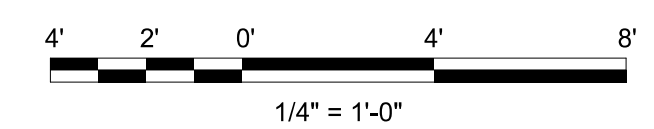
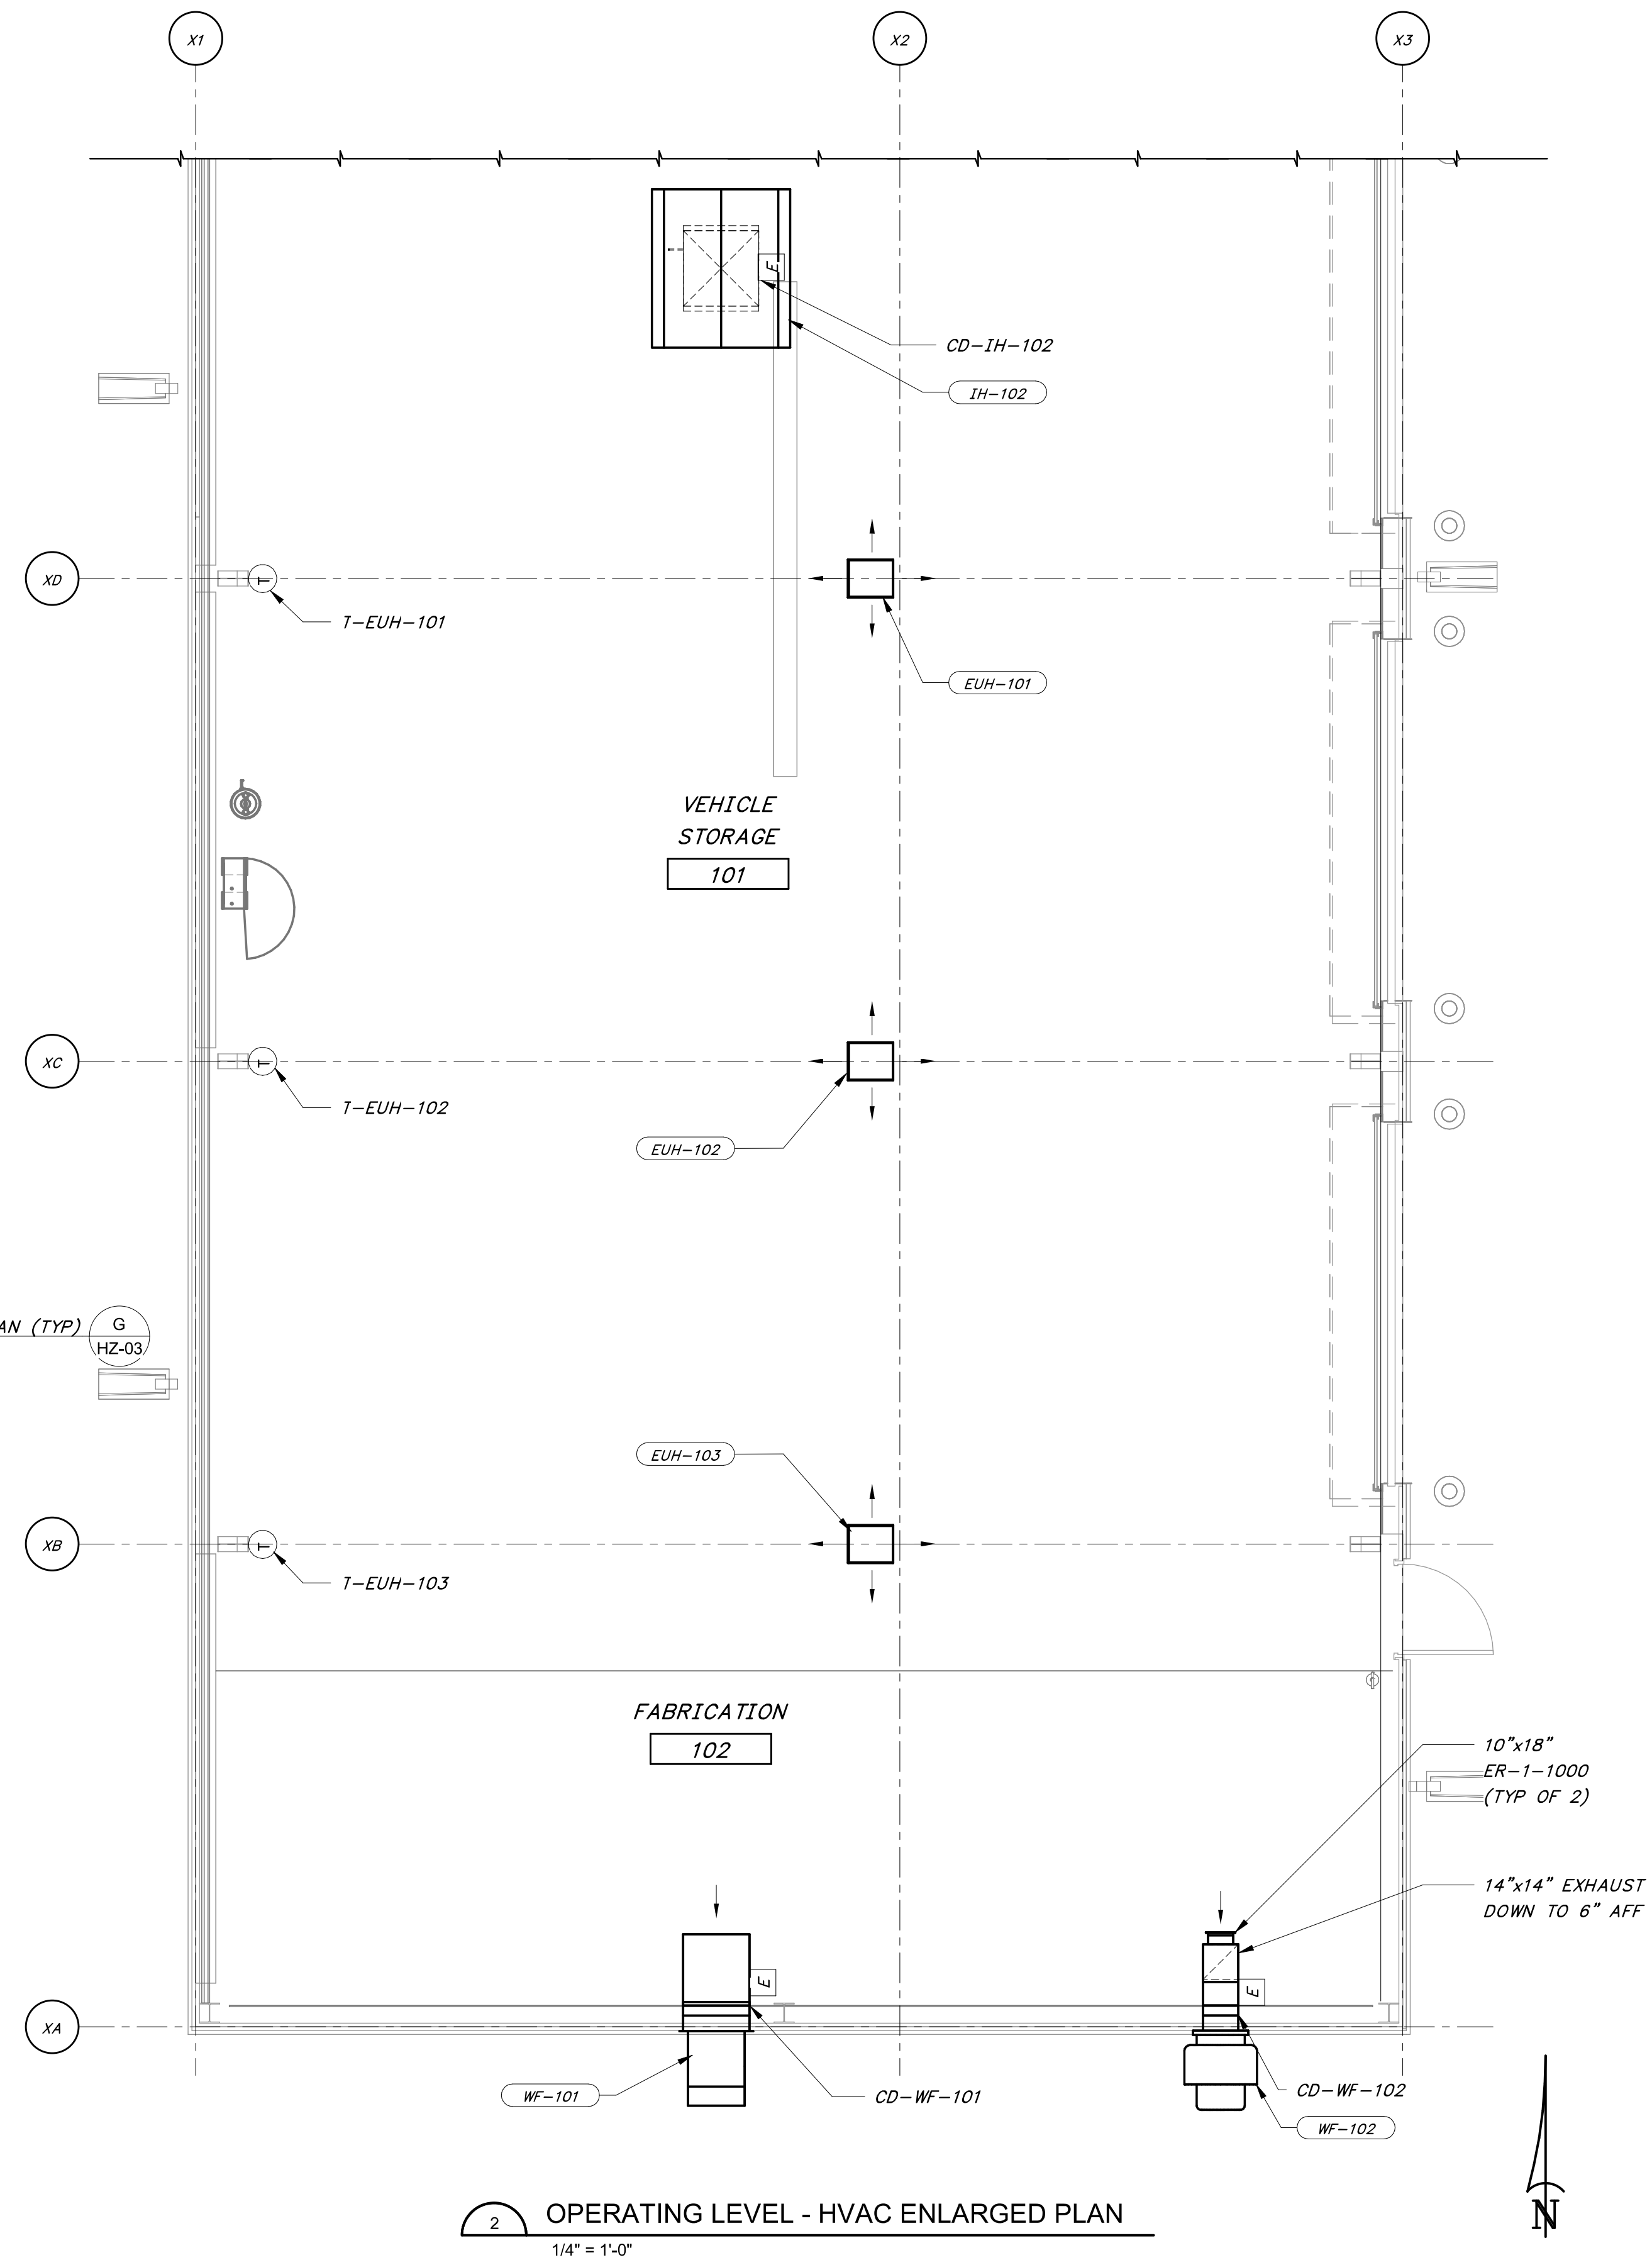


8/27/2024 9:11:44 AM / RLG / MAINTENANCE BUILDING

Autodesk Docs: //406493 - Rogers PCF Solids Phase 2/406493 - Maintenance Building - BVRrvt

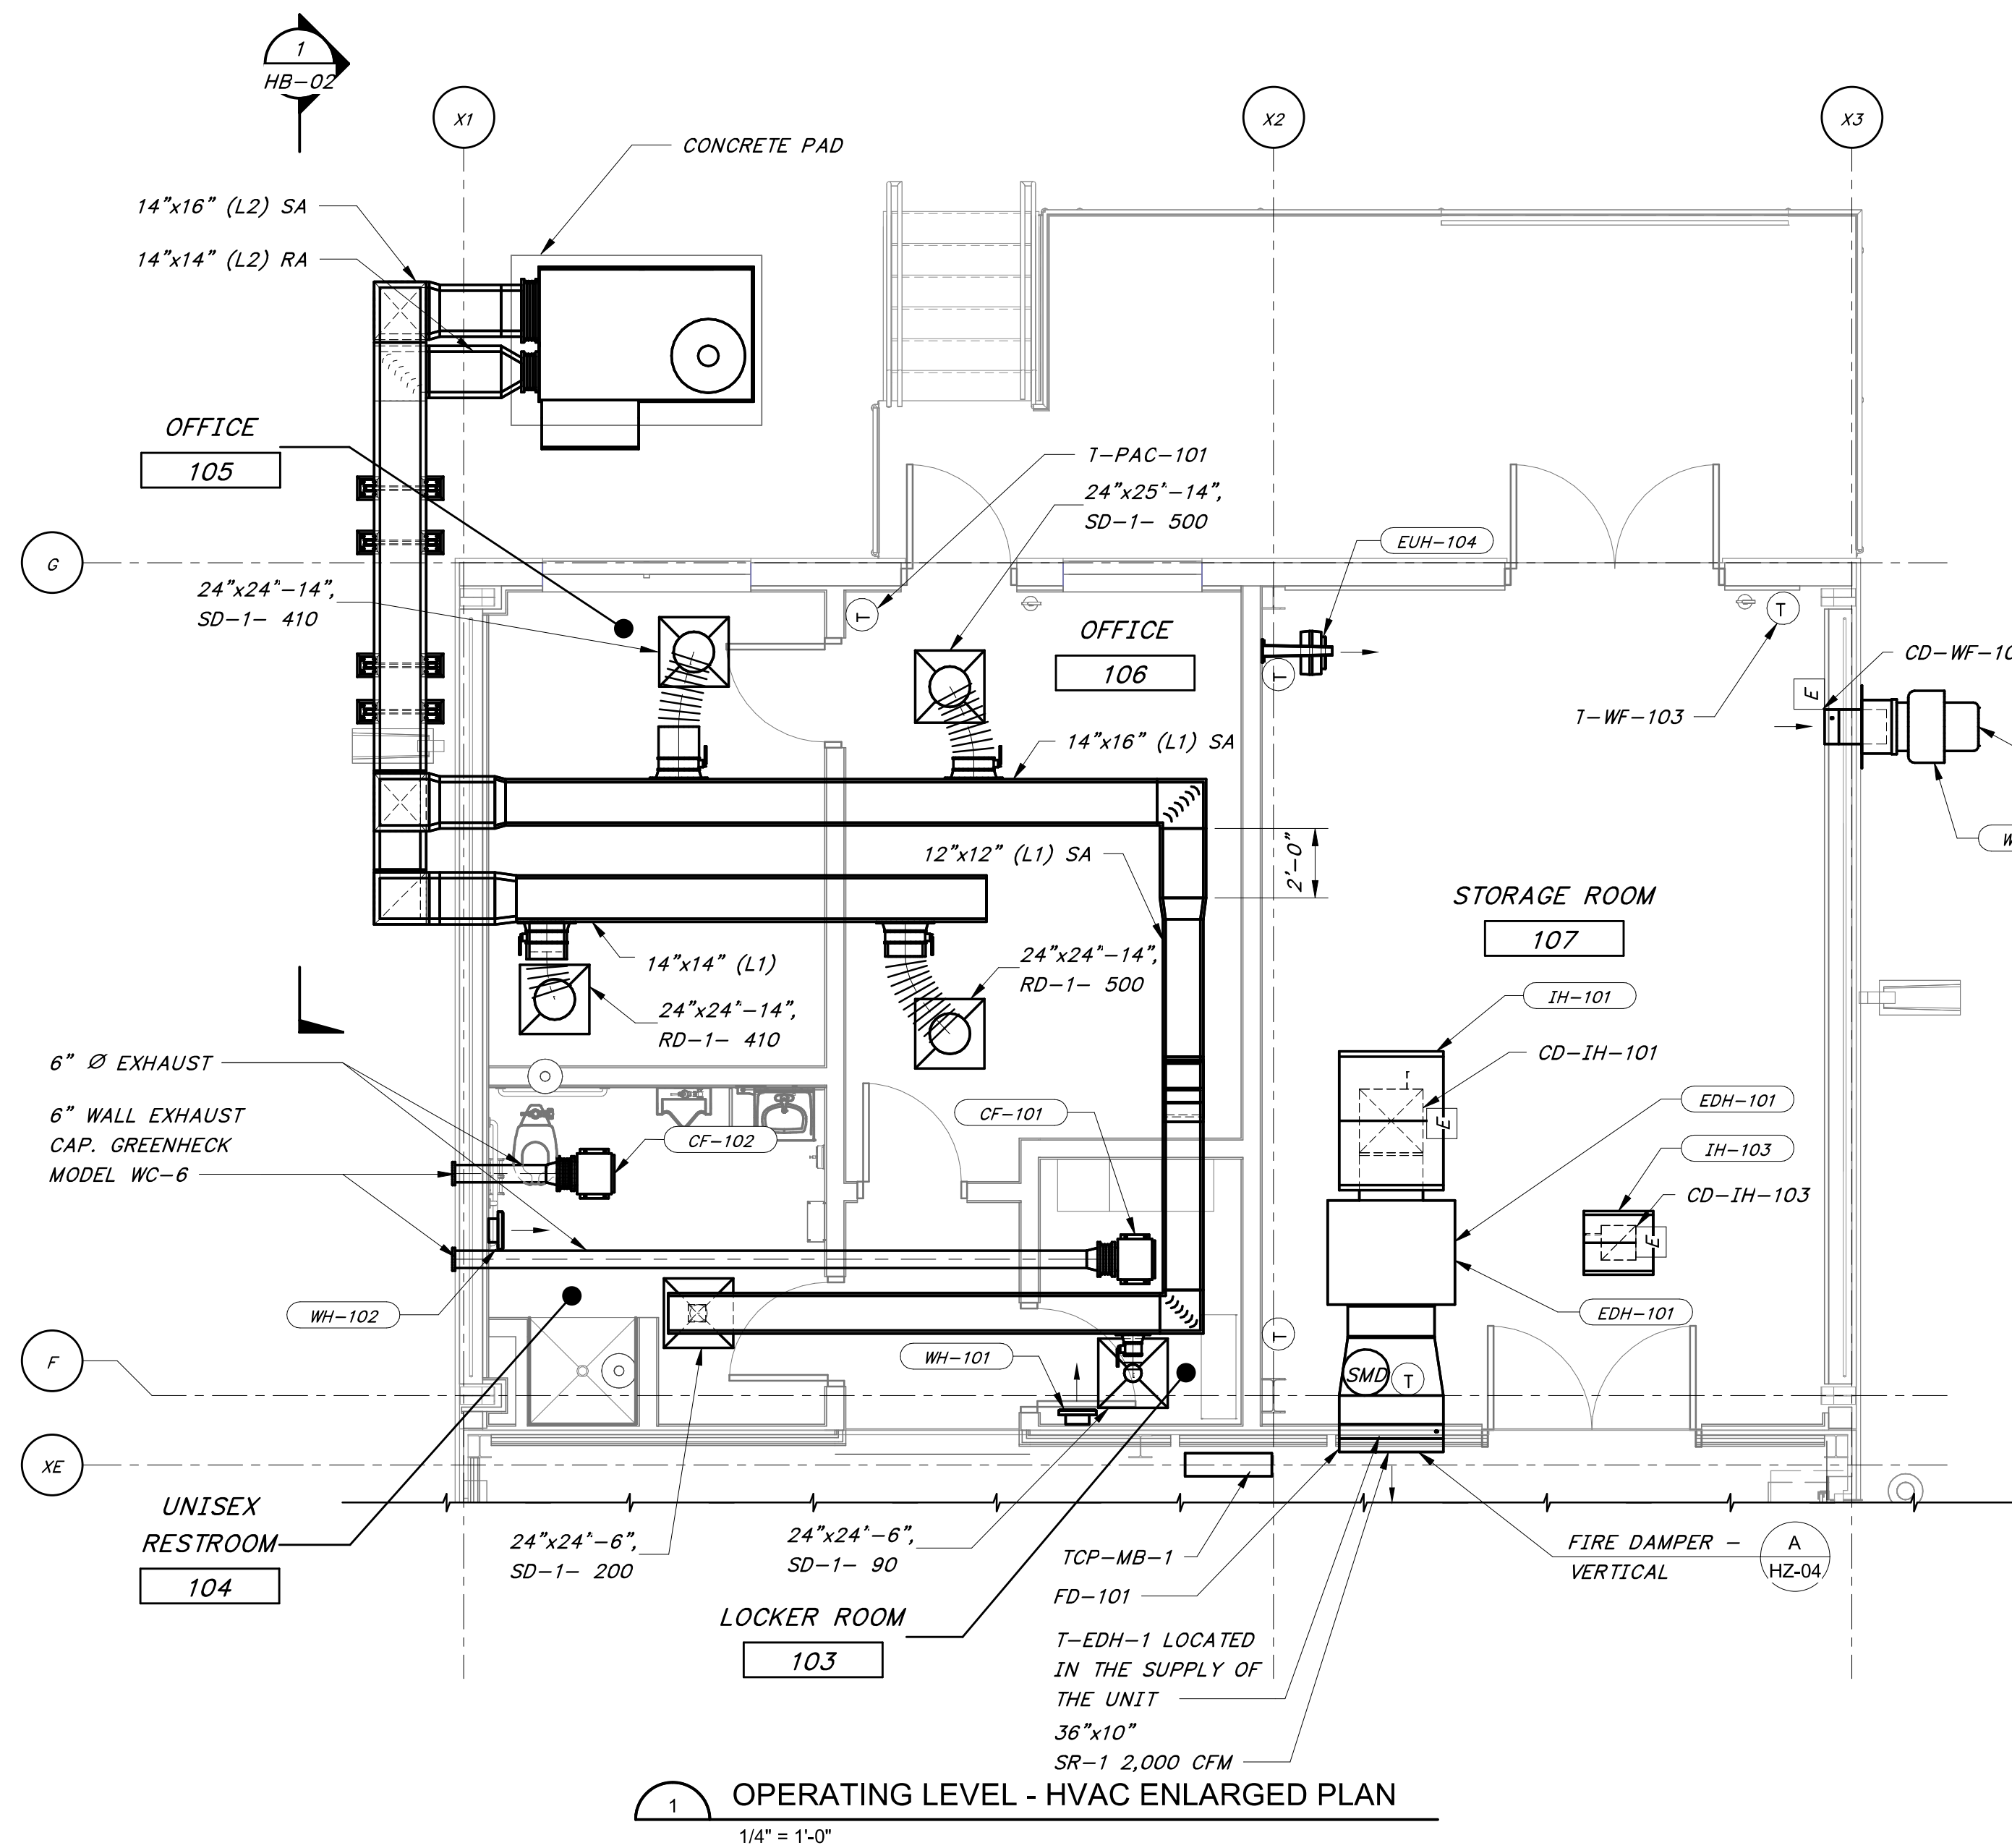

1"
ONE INCH
AT FULL SIZE
IF NOT ONE INCH
SCALE ACCORDINGLY

DATE	REVISION



HAWKINS WEIR ENGINEERS, INC.
BLACK & VEATCH

ROGERS, ARKANSAS
 ROGERS POLLUTION CONTROL FACILITY (PCF)
 SOLIDS HANDLING IMPROVEMENTS, PHASE II
**MAINTENANCE BUILDING
 ENLARGED HVAC FLOOR PLAN**
 FOR: ROGERS WATER UTILITIES

DATE: AUGUST 2024
 SCALE: 1/4" = 1'-0"
 DESIGNED BY: APC
 DRAWN BY: RLG
 HWEI NO.: 2020043
 FILENAME:

SHEET NO.
HB-03