



8/26/2024 4:40:18 PM / RLG / PLUMBING

Autodesk Docs://406493 - Rogers PCF Solids Phase 2/406493-Solids Building-BV.rvt

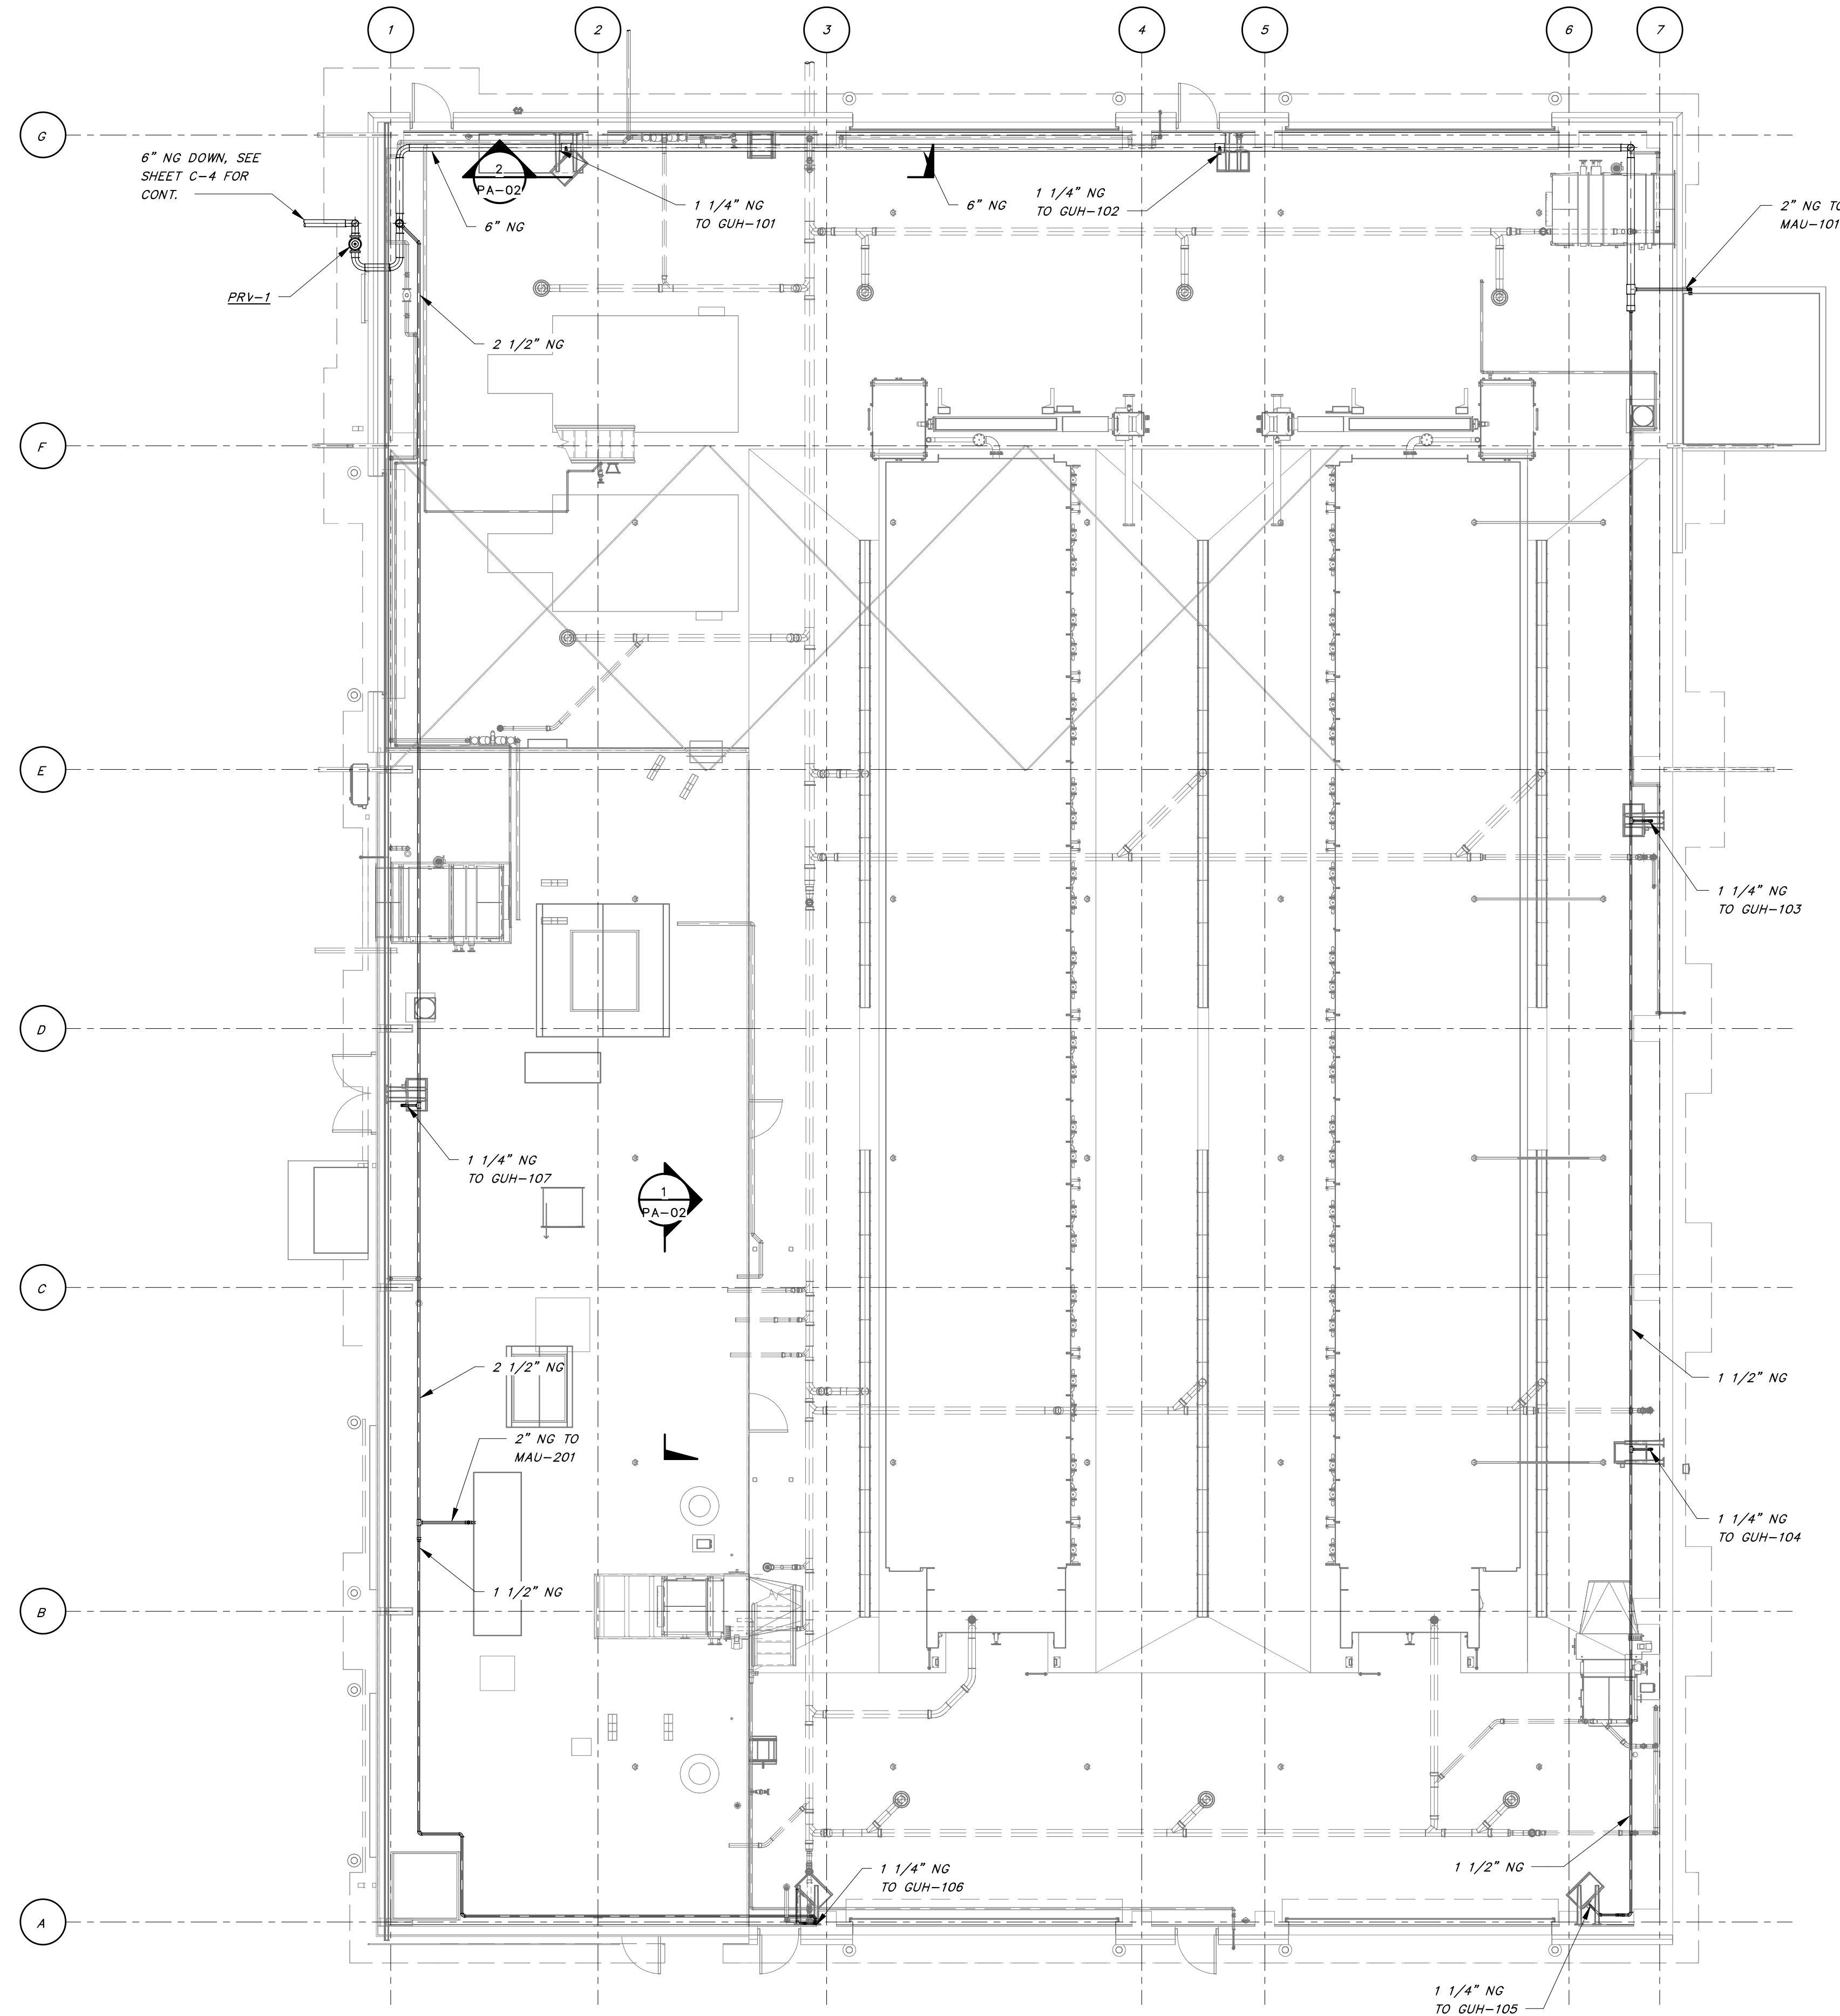

OPERATING LEVEL - PLUMBING PLAN - GAS


1/8" = 1'-0"

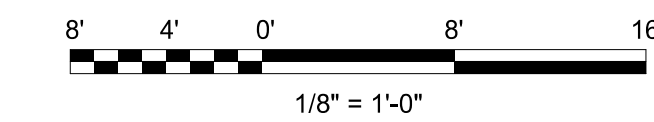

ONE INCH AT FULL SIZE IF NOT ONE INCH SCALE ACCORDINGLY

DATE

REVISION

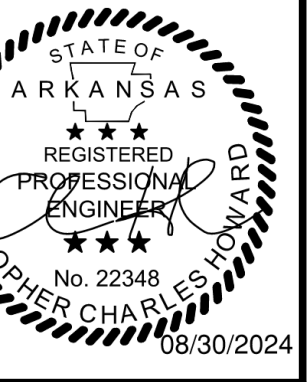

HAWKINS WEIR ENGINEERS, INC.
BLACK & VEATCH

ROGERS, ARKANSAS
ROGERS POLLUTION CONTROL FACILITY (PCF)
SOLIDS HANDLING IMPROVEMENTS, PHASE II

PLUMBING
NATURAL GAS PLAN
SOLIDS BUILDING
FOR: ROGERS WATER UTILITIES

DATE: AUGUST 2024
SCALE: 1/8" = 1'-0"
DESIGNED BY: DBR
DRAWN BY: RLG
HWEI NO.: 2020043
FILENAME:

SHEET NO.
PA-03