

CALVARY CHURCH
CALVARY CHURCH FACILITY ADDITION
BENTONVILLE, AR



Revisions
No. Description Date

Project Number
21010

Date
08/12/25

FIRST FLOOR
LIGHTING PLAN -
EAST

E2.02

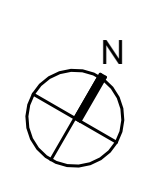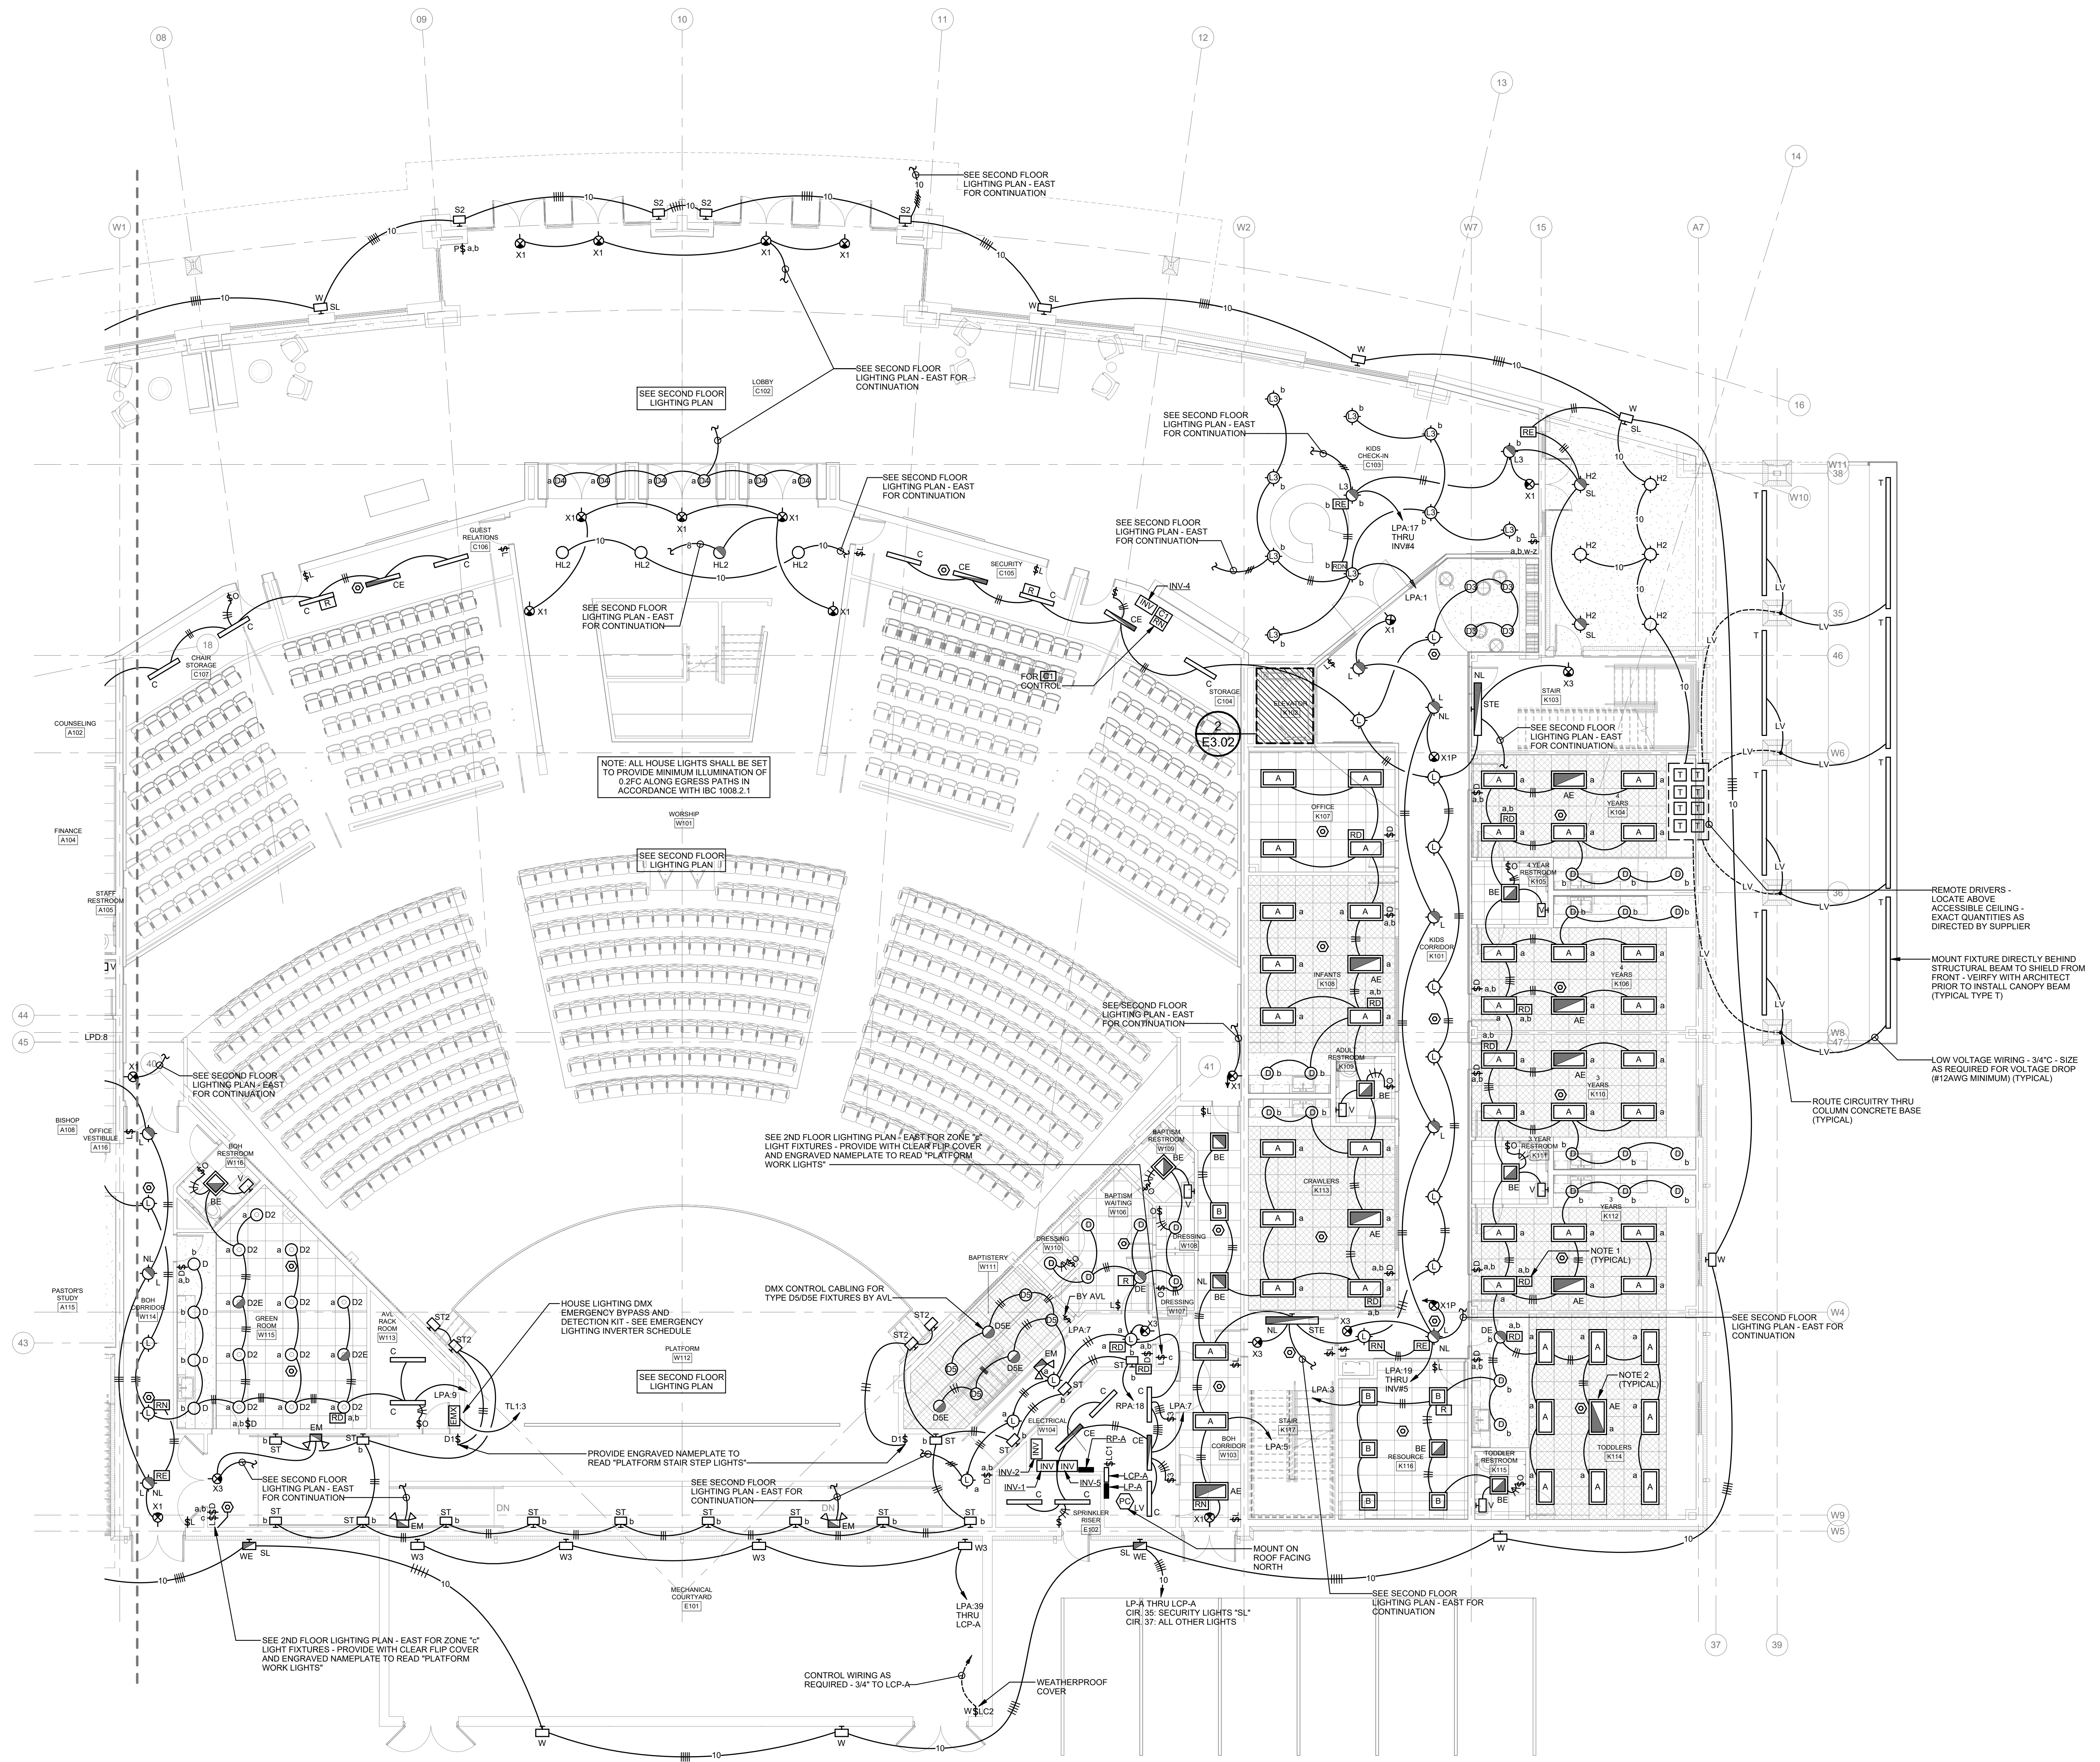

FIRST FLOOR LIGHTING PLAN -
EAST
SCALE: 1/8" = 1'-0"

PLAN NOTES

1. PROVIDE 0-10V DIMMING CABLE TO ALL FIXTURES WITH DIMMING CONTROLS.
2. DO NOT SWITCH EXIT SIGNS, NIGHT LIGHTS OR EMERGENCY BATTERY PACKS.
3. LOCATE ROOM CONTROLLERS AND EMERGENCY RELAY DEVICES CONCEALED ABOVE ACCESSIBLE CEILING OR IN BACK OF HOUSE ROOMS.

JACKSON,
RENFRO
& ASSOCIATES, INC.
ELECTRICAL ENGINEERING & DESIGN
1105 CENTER POINT DRIVE, SUITE 300, BIRMINGHAM, AL 35233
ROBERT RENFRO, PE
bobby@jraee.com
(205) 336-7114
(P) 205.995.1078
IRA FOR NO. 234172