


**SECOND FLOOR LIGHTING PLAN
- EAST**
SCALE: 1/8" = 1'-0"

PLAN NOTES

1. PROVIDE 0-10V DIMMING CABLE TO ALL FIXTURES WITH DIMMING CONTROLS.
2. DO NOT SWITCH EXIT SIGNS, NIGHT LIGHTS OR EMERGENCY BATTERY PACKS.
3. LOCATE ROOM CONTROLLERS AND EMERGENCY RELAY DEVICES CONCEALED ABOVE ACCESSIBLE CEILING OR IN BACK OF HOUSE ROOMS.

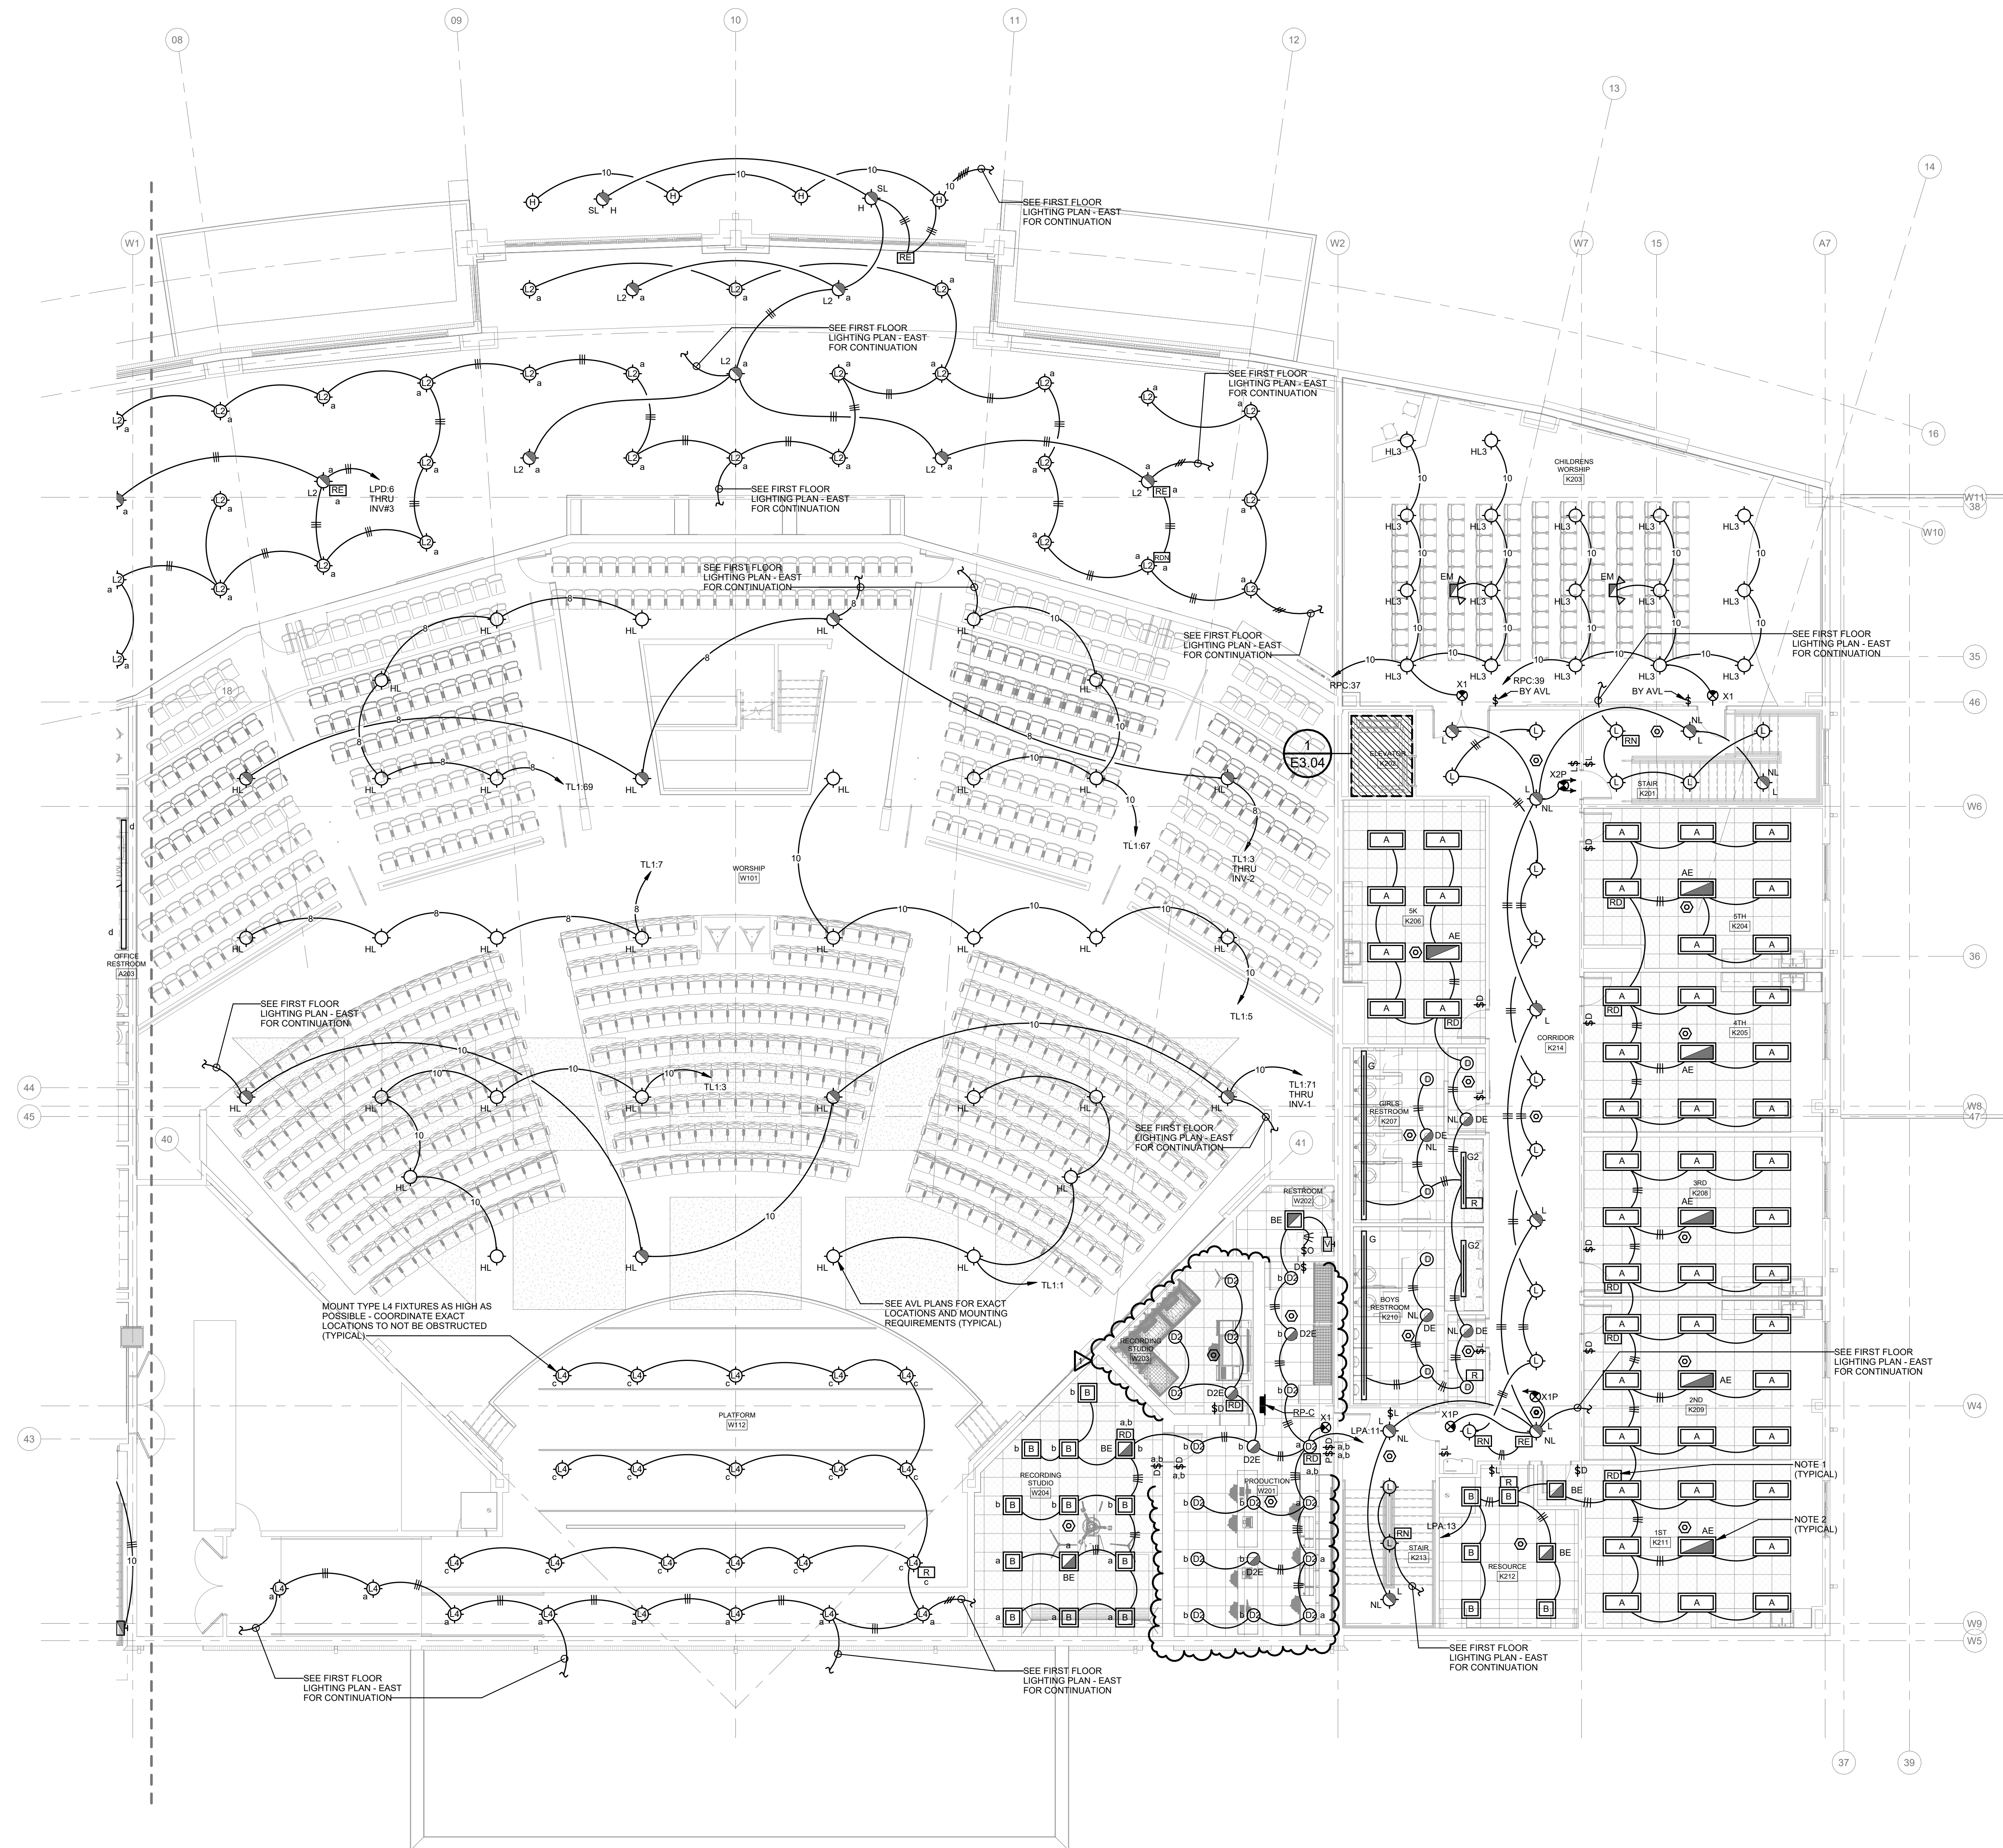

JACKSON,
RENFRO
& ASSOCIATES, INC.
ELECTRICAL ENGINEERING & DESIGN
1105 SOUTH CENTRAL AVENUE • SUITE 300 • BIRMINGHAM, AL 35202
bobby@jrae.com
(205) 336-7134
(P) 205-995-1078
FAX FOR NO. 234752

ROBERT RENFRO, PE
bobby@jrae.com
(205) 336-7134
(P) 205-995-1078
FAX FOR NO. 234752

**SECOND FLOOR
LIGHTING PLAN - EAST**

E2.04

Revisions		
No.	Description	Date
1	Addendum 01	09/12/25

Project Number
21010

Date
08/12/25

CALVARY CHURCH
CALVARY CHURCH FACILITY ADDITION
BENTONVILLE, AR

