

CALVARY CHURCH
CALVARY CHURCH FACILITY ADDITION
BENTONVILLE, AR


Revisions		
No.	Description	Date
1	Addendum 01	09/12/25

Project Number
21010

Date
08/12/25

FIRST FLOOR
POWER PLAN -
WEST



E3.01

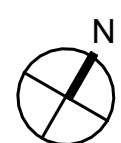

1
E3.01

ENLARGED ELEVATOR A104 PIT
POWER PLAN

SCALE: 1/4" = 1'-0"

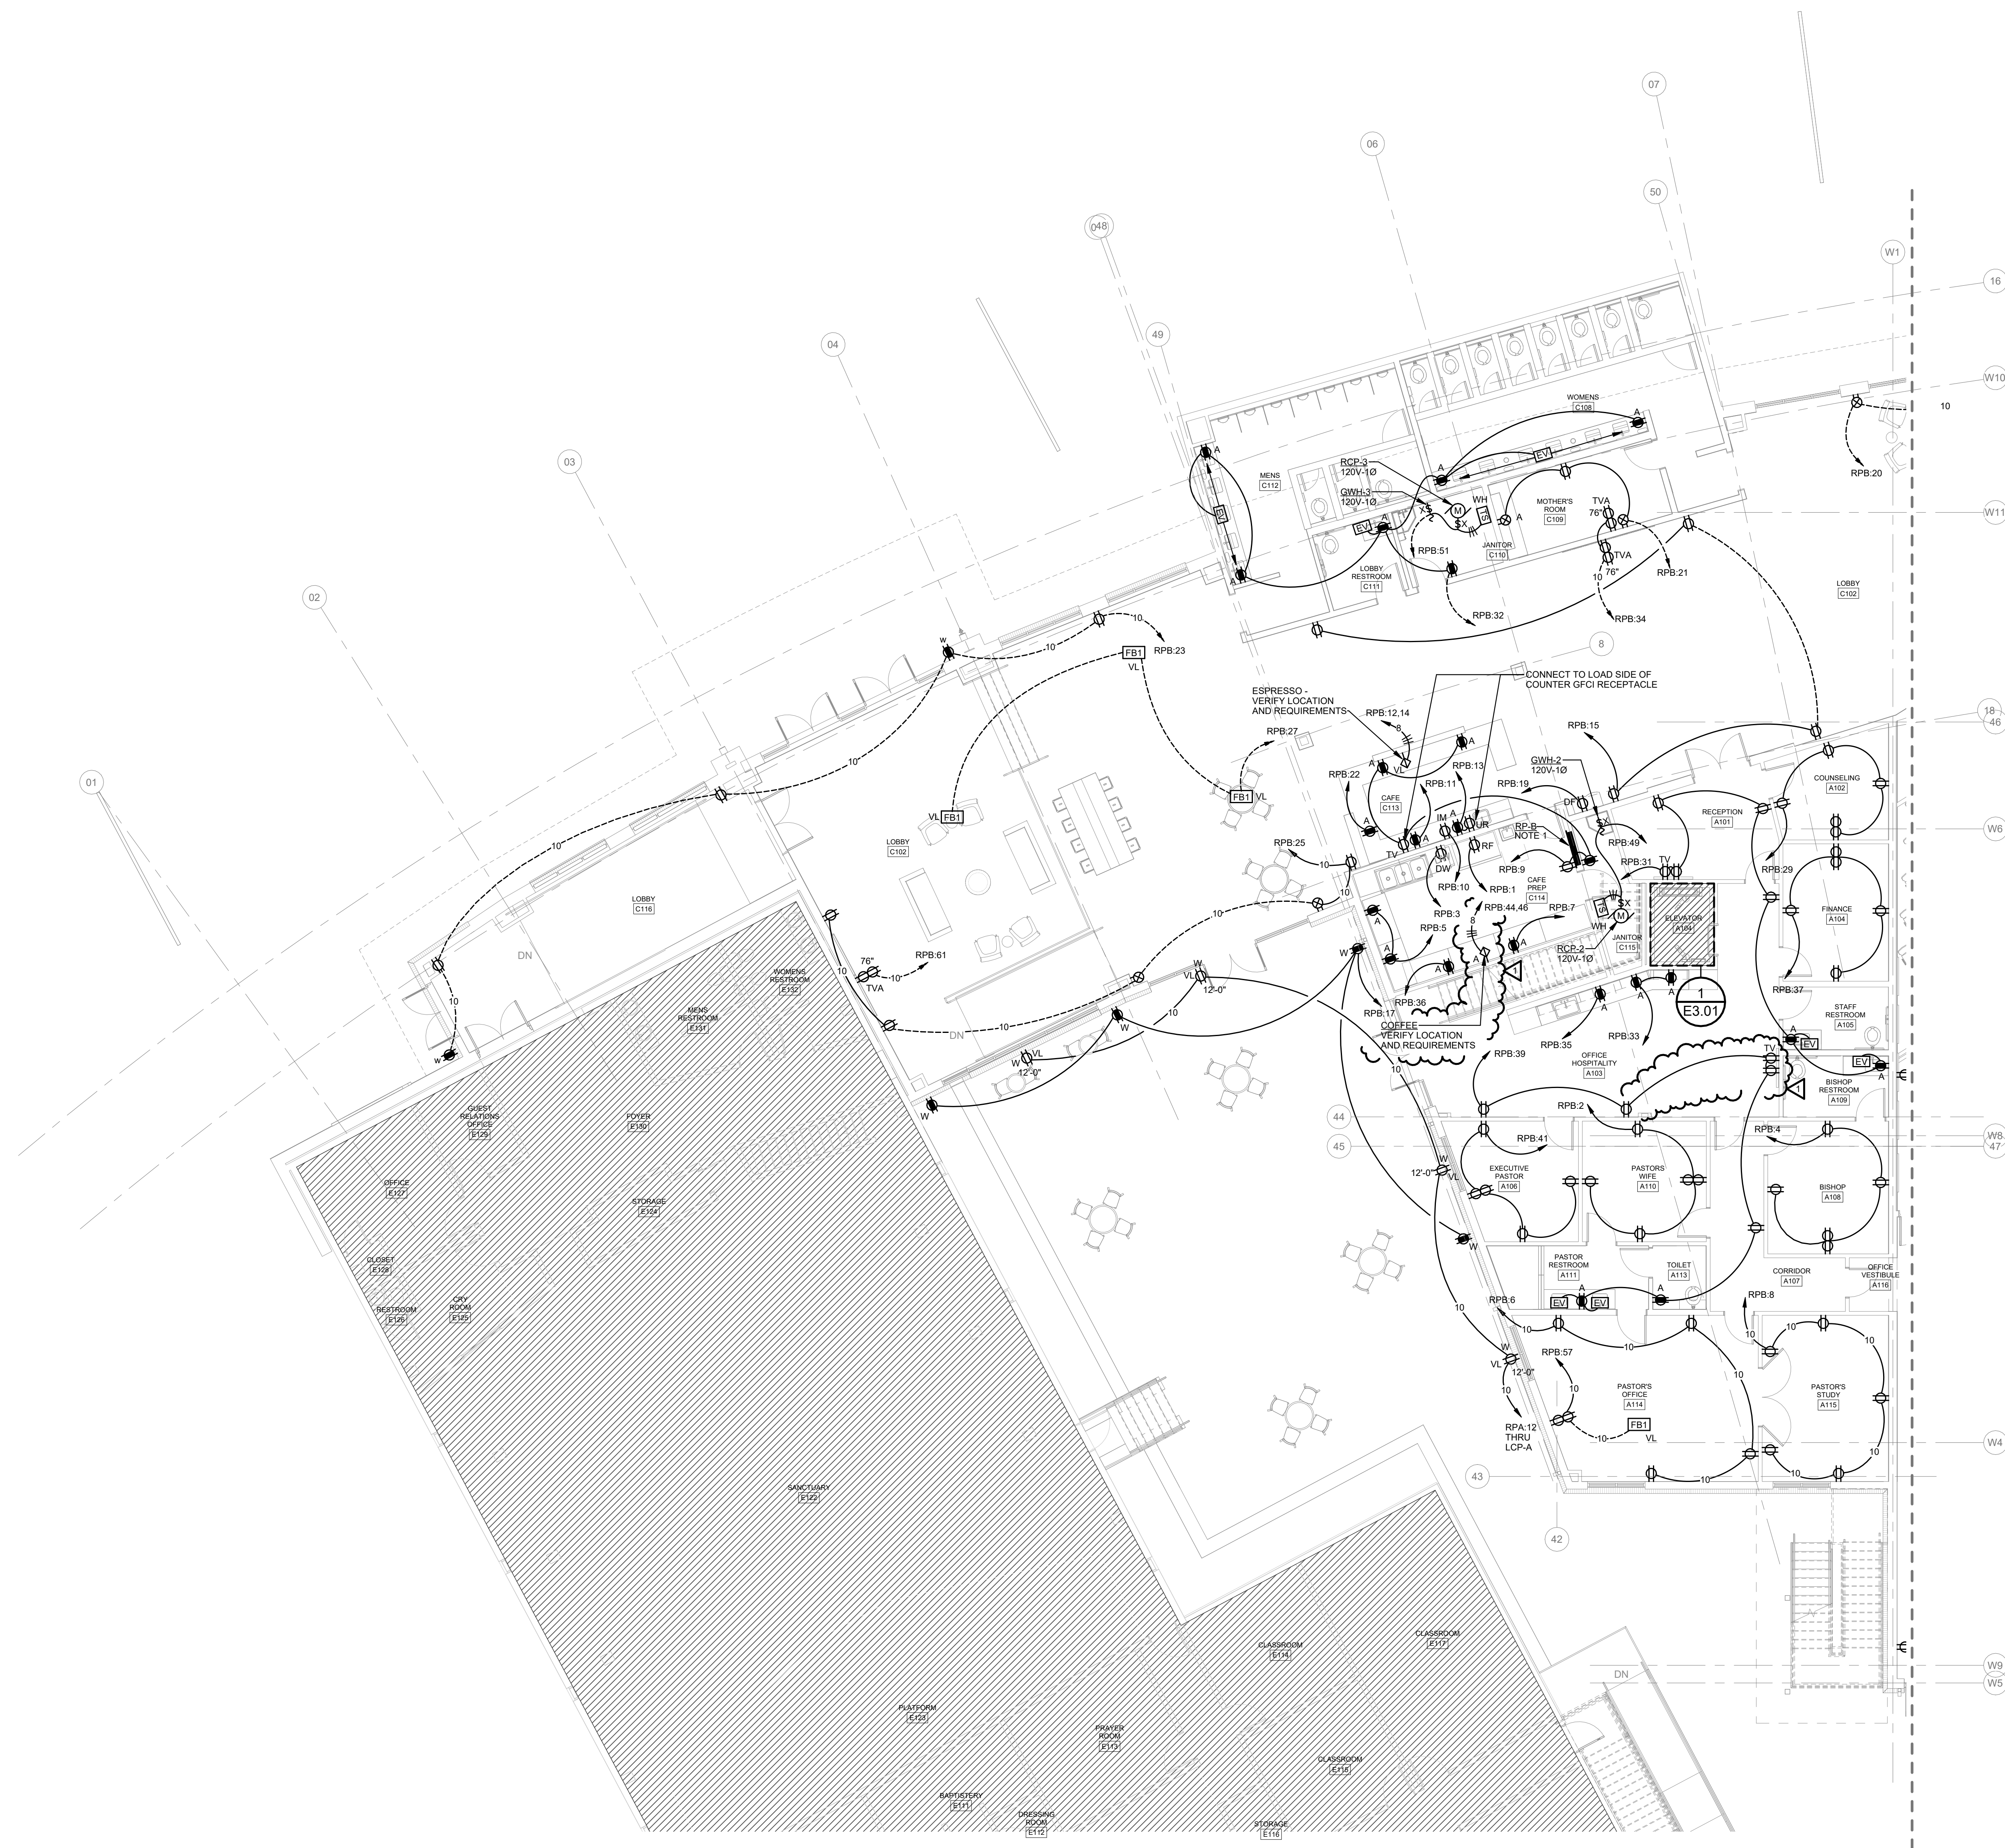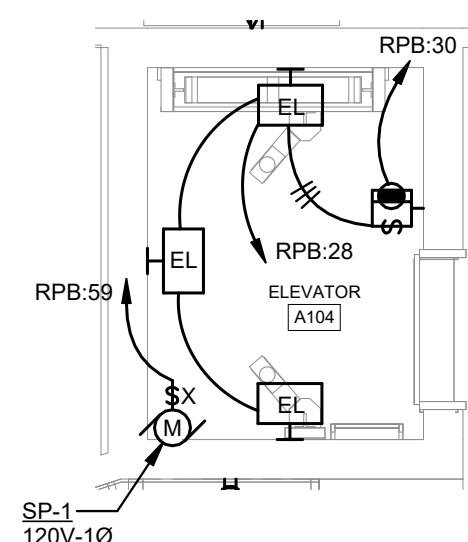

FIRST FLOOR POWER PLAN -
WEST

SCALE: 1/8" = 1'-0"

PLAN NOTES

1. PROVIDE THREE (3) 1" E.C. TO ABOVE ACCESSIBLE CEILING FOR FUTURE CIRCUITS.



JACKSON,
RENFRO
& ASSOCIATES, INC.
ELECTRICAL ENGINEERING & DESIGN
1 UNIVERSITY CENTER PARK • SUITE 300 • BIRMINGHAM, AL 35242

ROBERT RENFRO, PE
bobby@jrae.com
(D) 205.536.7114
(P) 205.995.1078
IRA FOR NO. 234172