



CALVARY CHURCH
CALVARY CHURCH FACILITY ADDITION
BENTONVILLE, AR


Revisions
No. Description Date

Project Number
21010

Date
08/12/25

FIRST FLOOR
POWER PLAN -
EAST


E3.02

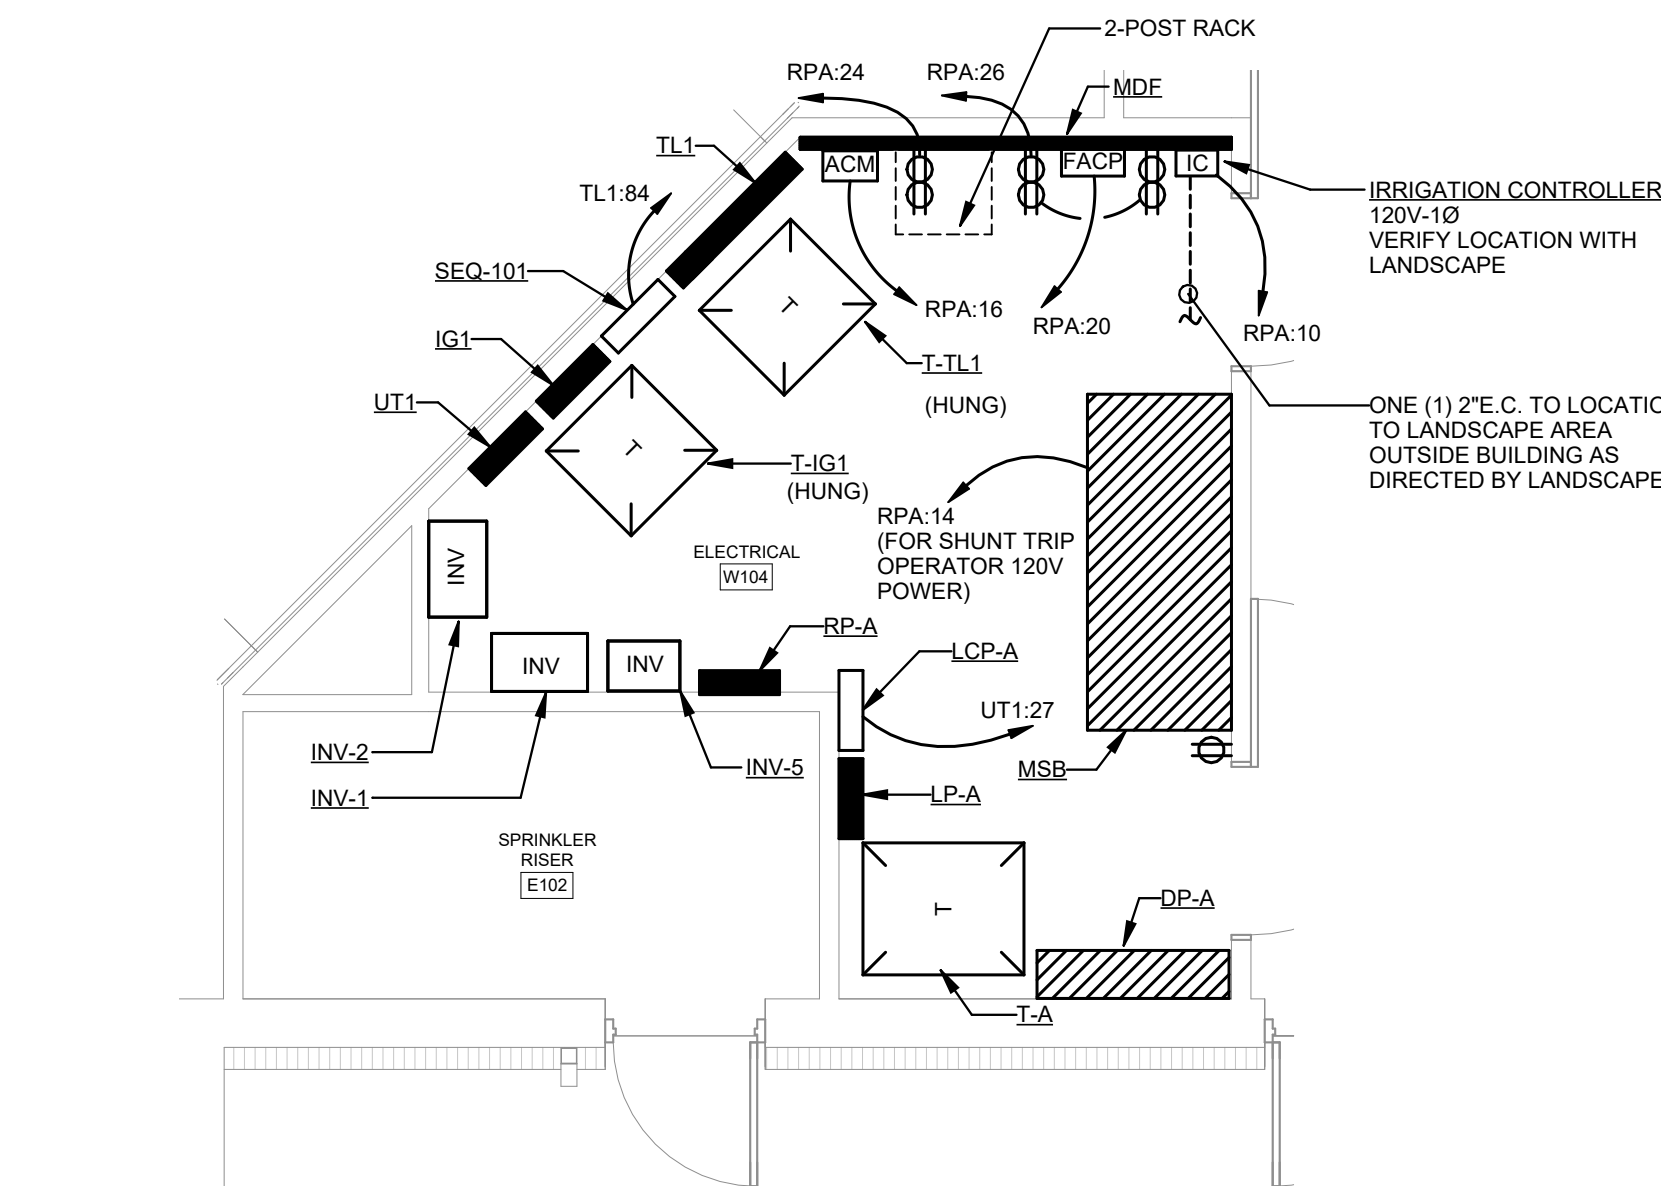


**ENLARGED ELECTRICAL W104
POWER PLAN**
SCALE: 1/4" = 1'-0"

PLAN NOTES

1. CONTRACTOR SHALL SUBMIT TO-SCALE DRAWING OF ELECTRICAL ROOMS WITH ACTUAL DIMENSIONS OF ALL PROPOSED EQUIPMENT PER SPECIFICATION REQUIREMENT PRIOR TO ORDERING EQUIPMENT.

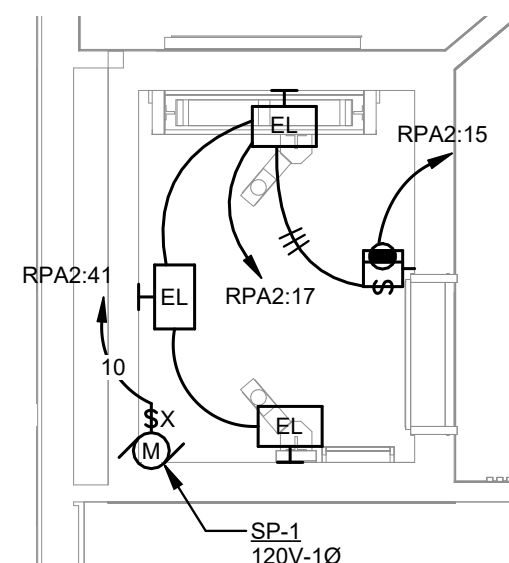

**ENLARGED ELEVATOR K102 PIT
POWER PLAN**
SCALE: 1/4" = 1'-0"

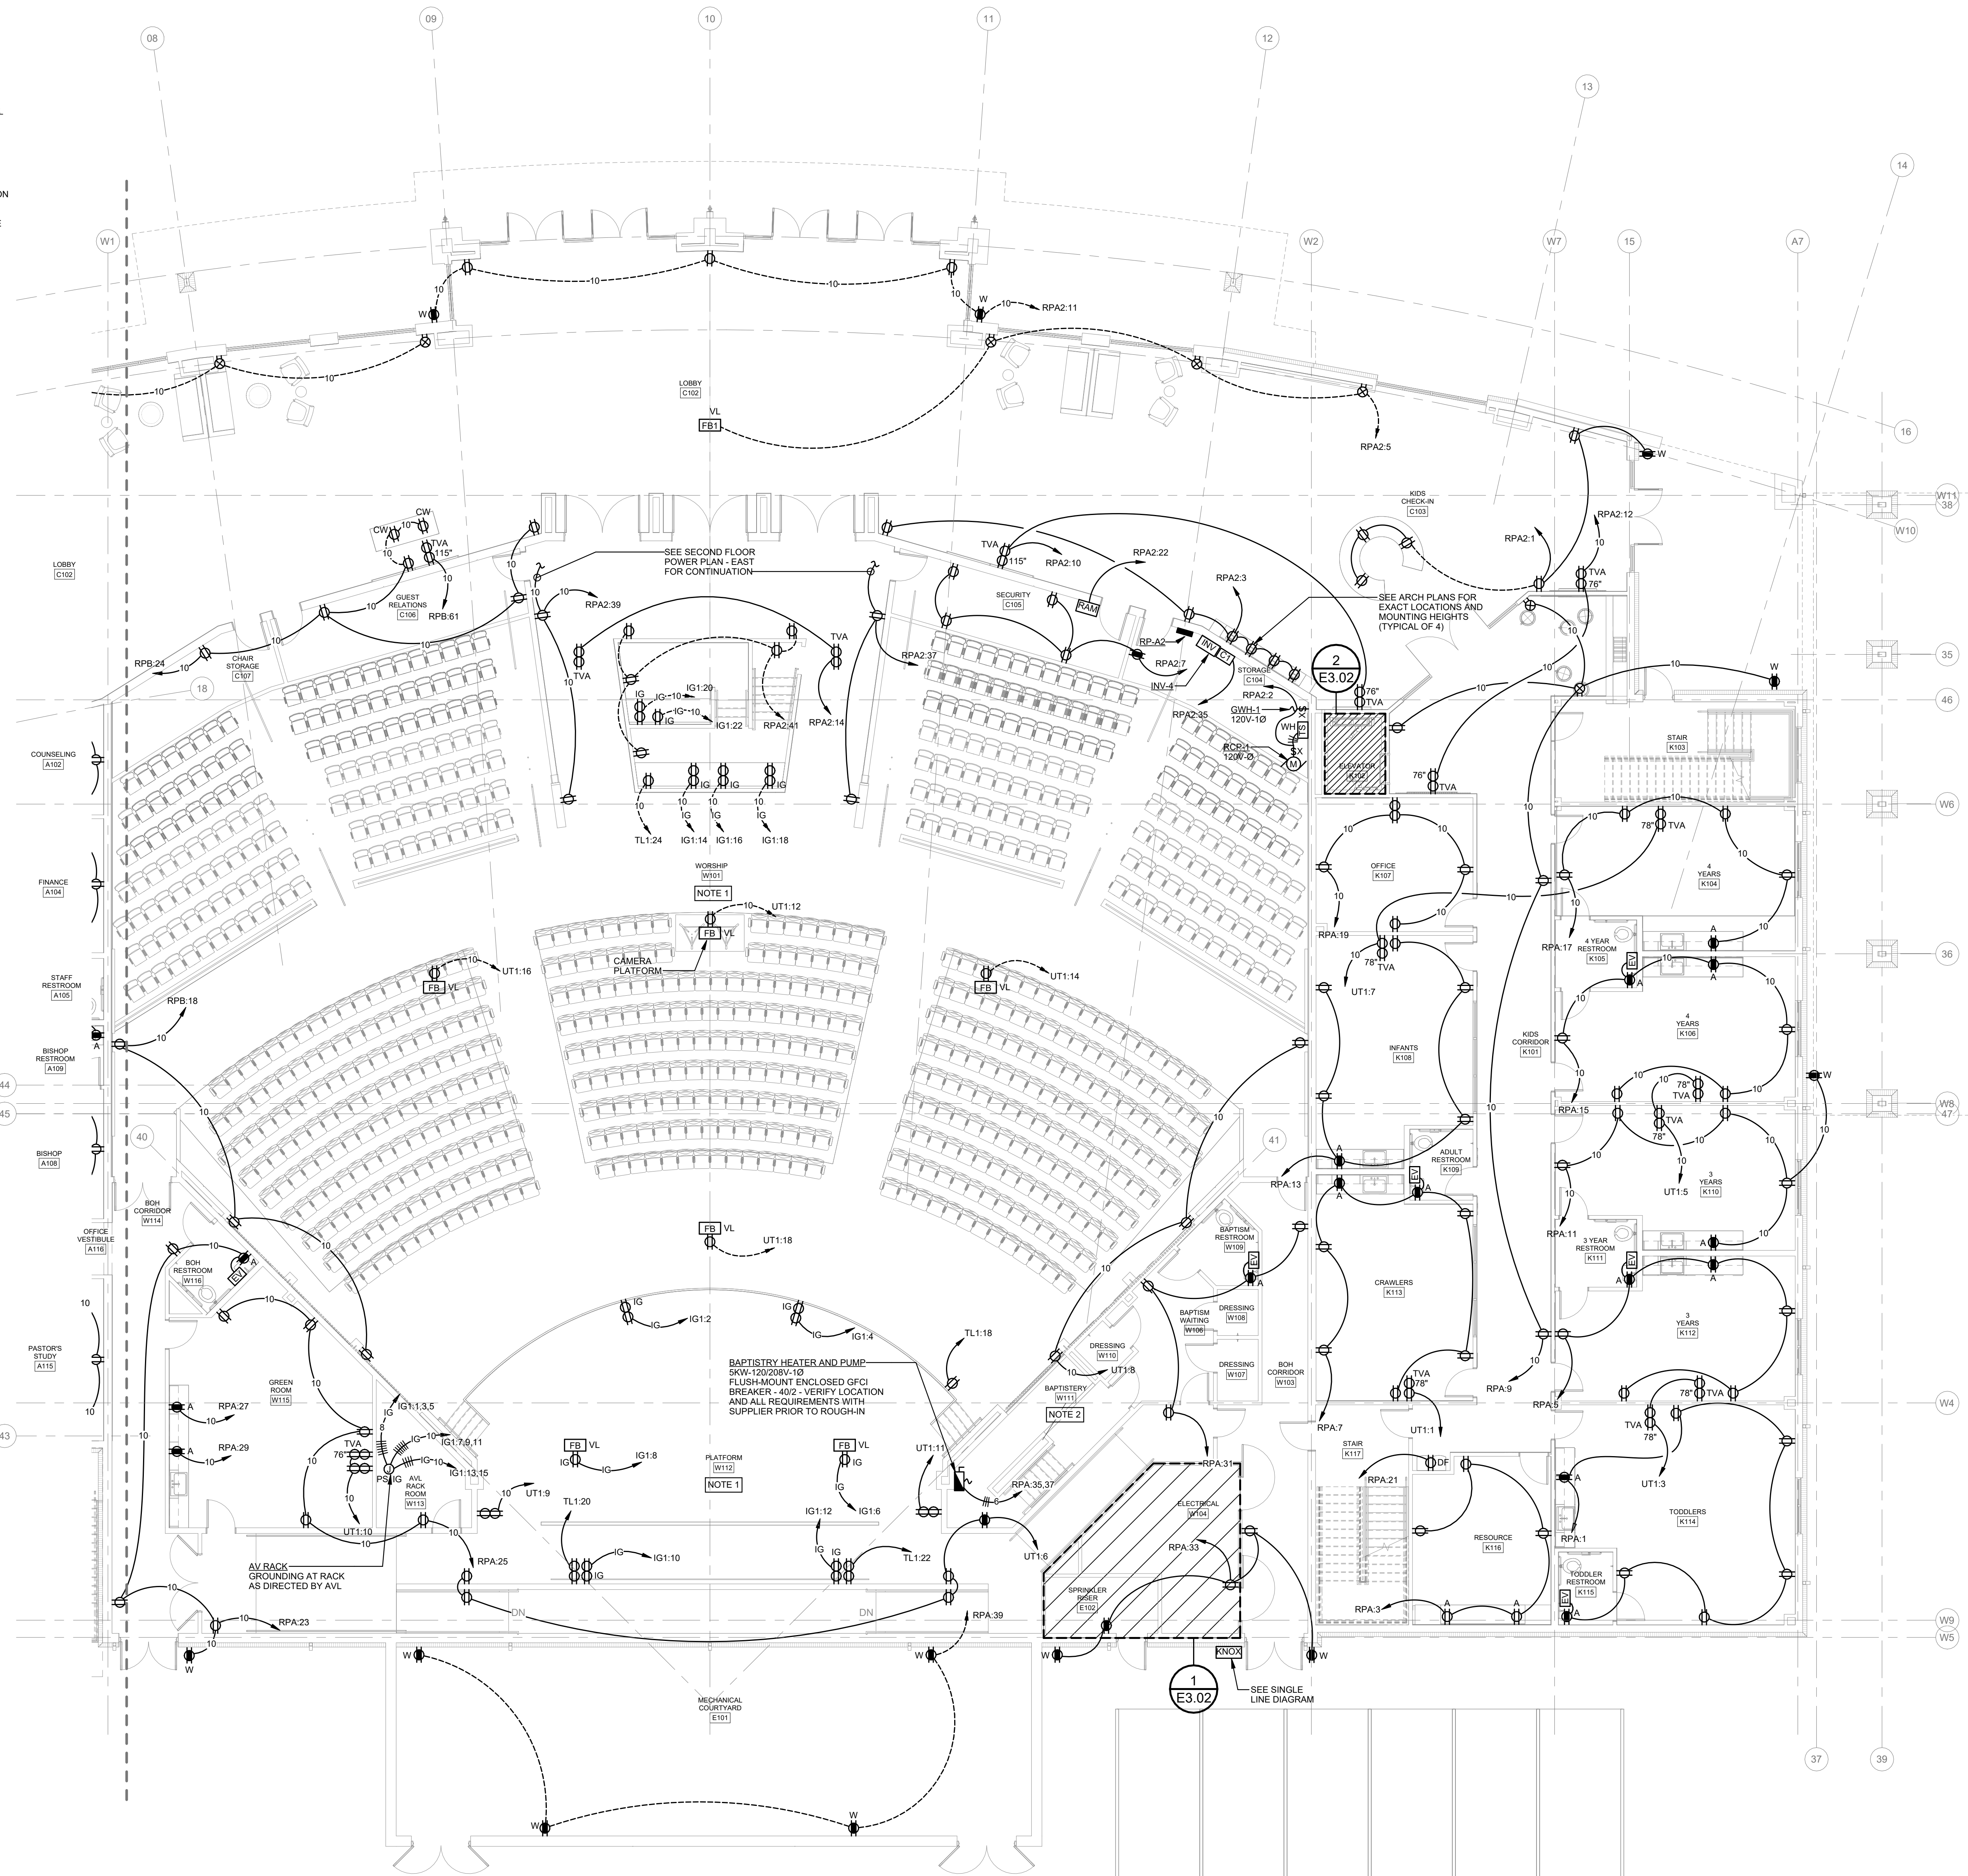

PLAN NOTES

1. THIS PLAN INDICATES POWER REQUIREMENTS ONLY FOR AVL EQUIPMENT. VERIFY LOCATIONS AND REQUIREMENTS WITH AVL CONTRACTOR PRIOR TO ROUGH-IN. REFER TO AVL PLANS FOR ADDITIONAL REQUIREMENTS INCLUDING RACEWAY, OUTLETS, CABLE TRAY, FLOOR POCKETS, ETC. FOR ALL LOW VOLTAGE CONNECTIONS.
2. BAPTISTRY ELECTRICAL INSTALLATION SHALL COMPLY WITH ALL APPLICABLE REQUIREMENTS ON N.E.C. ARTICLE 680. BOND ALL METAL COMPONENTS IN AREA.



JACKSON,
RENFRO
& ASSOCIATES, INC.
ELECTRICAL ENGINEERING & DESIGN
2117 2ND AVENUE SOUTH BIRMINGHAM, AL 35203

ROBERT RENFRO, PE
bobby@jraee.com
(D) 205.536.7134
(P) 205.995.3078
IRA FOR NO. 234172