
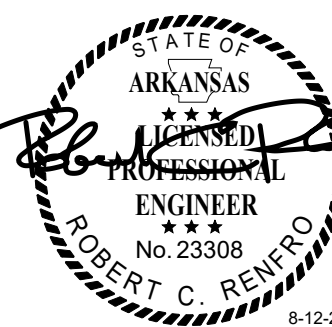


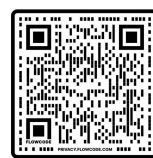

CALVARY CHURCH
CALVARY CHURCH FACILITY ADDITION
BENTONVILLE, AR


Revisions		
No.	Description	Date

Project Number
21010

Date
08/12/25

SECOND FLOOR
POWER PLAN -
WEST

E3.03

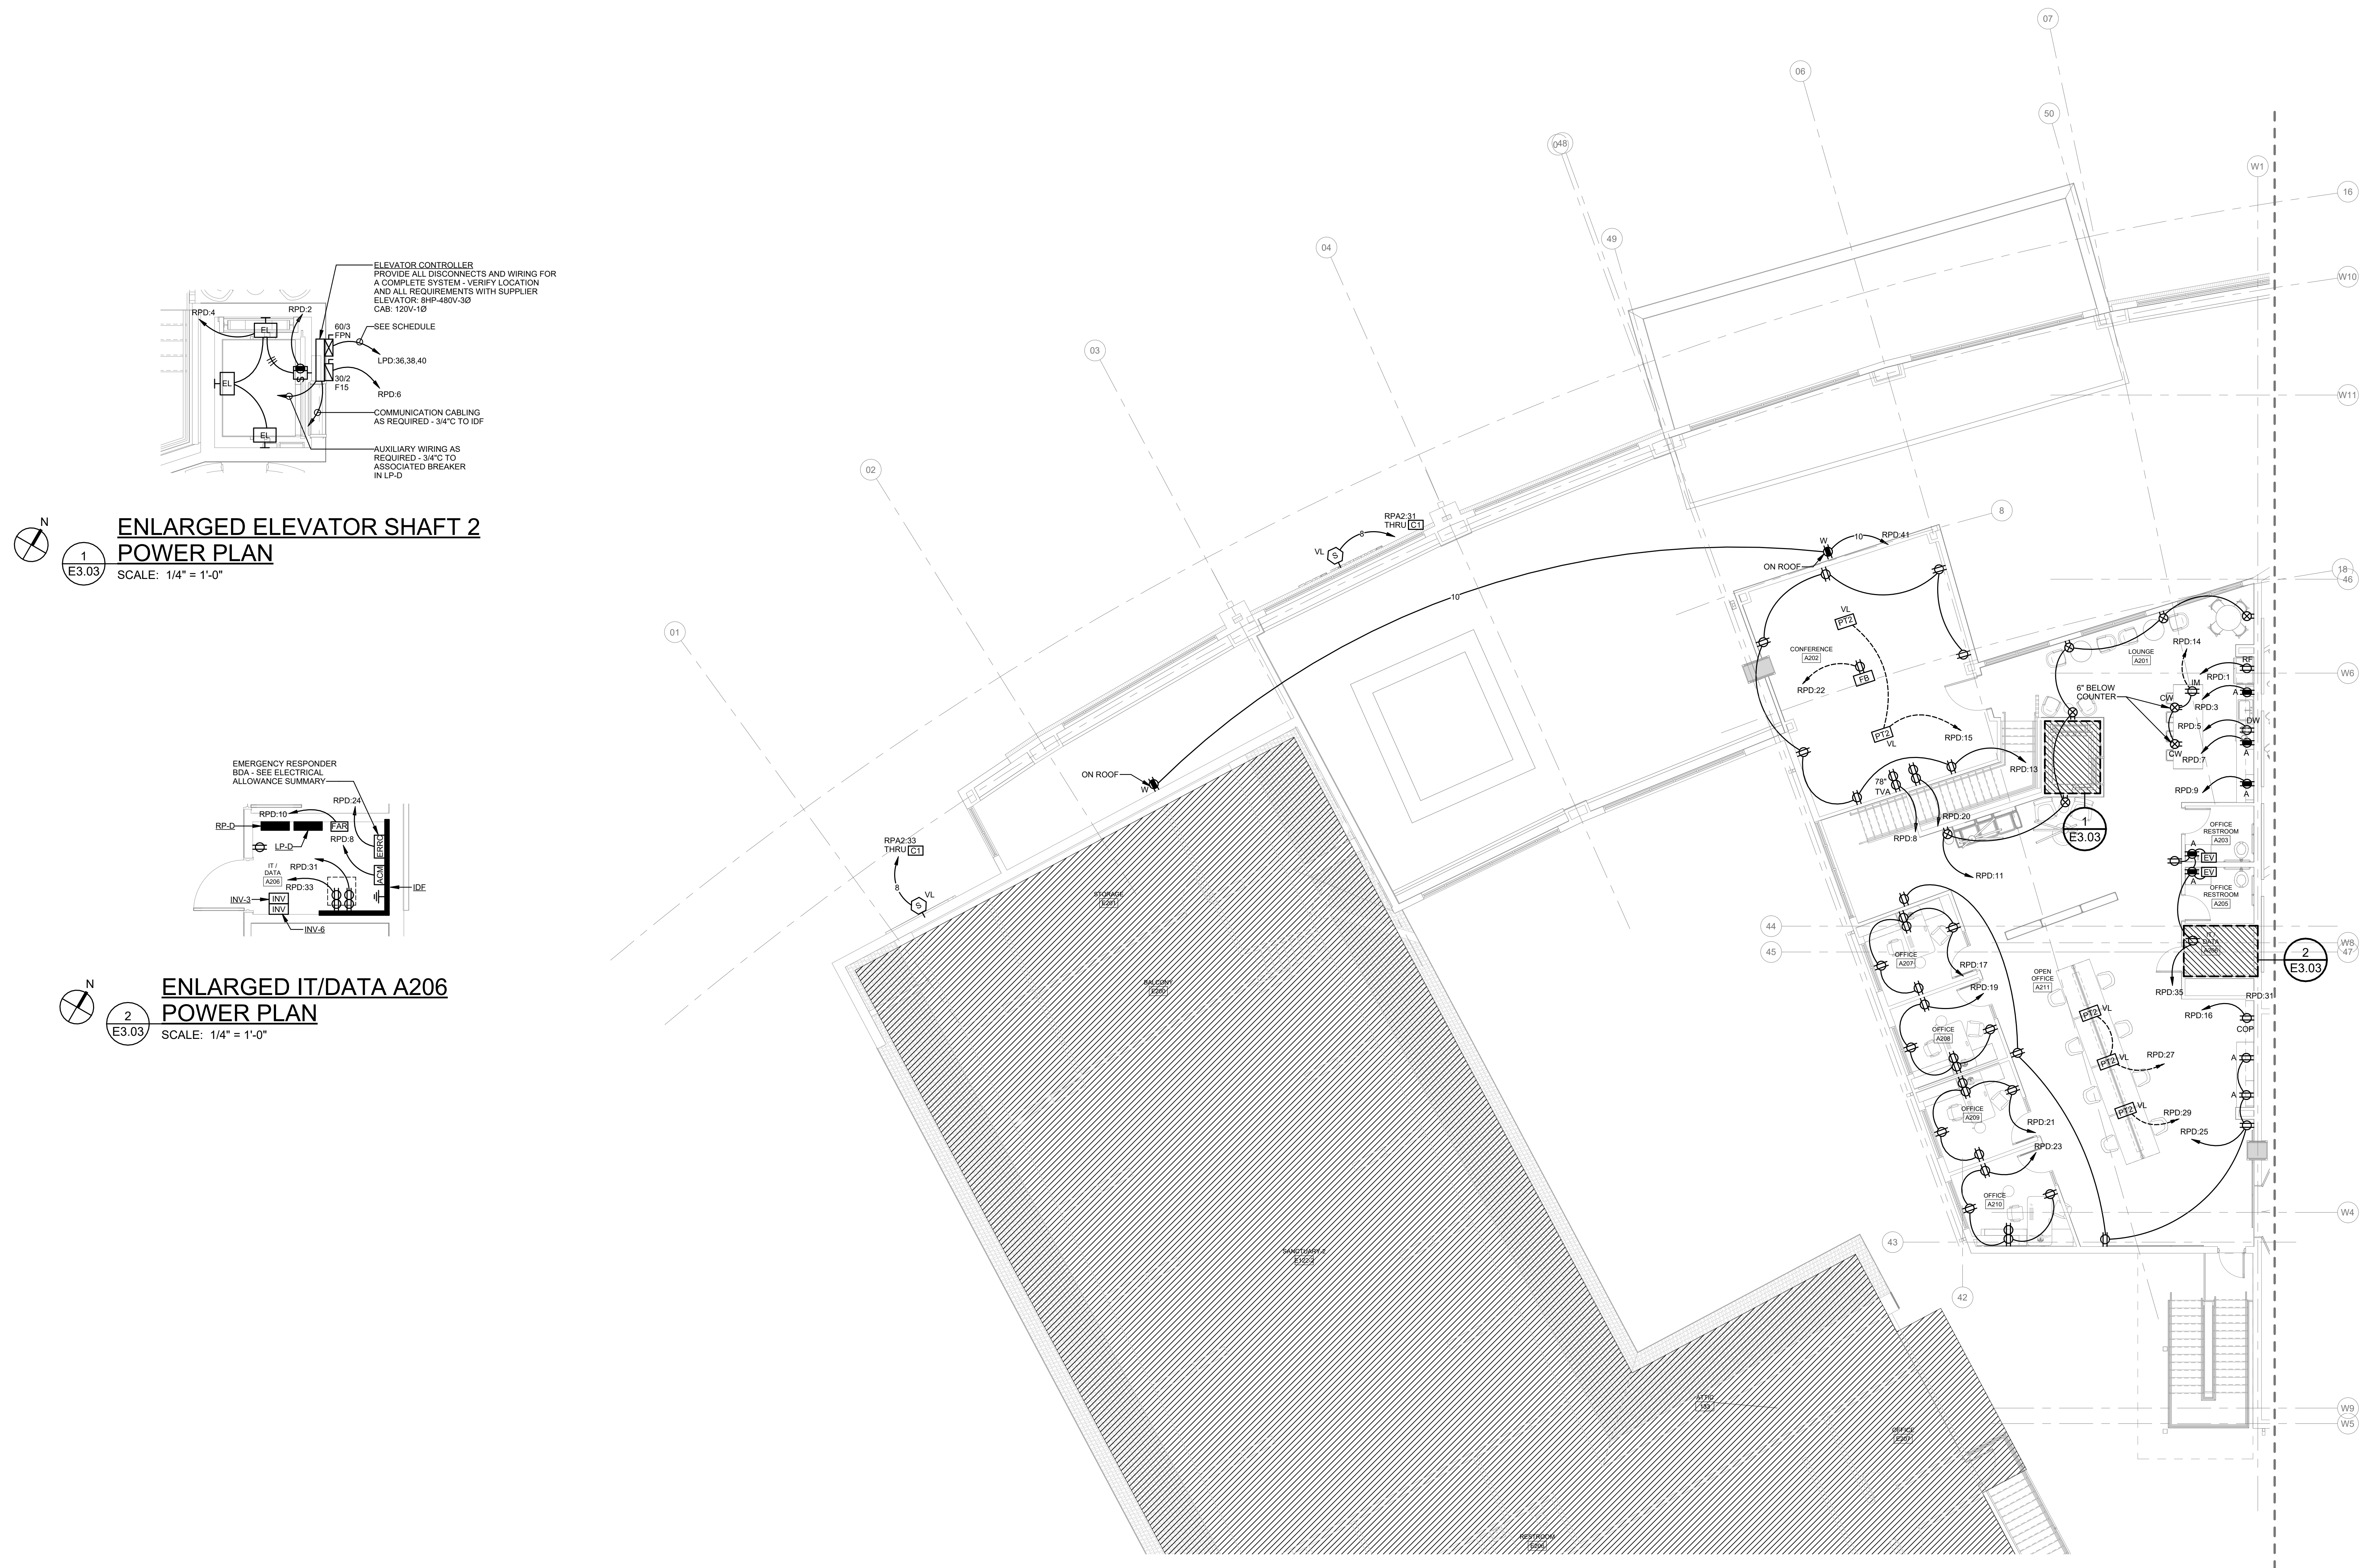

 **SECOND FLOOR POWER PLAN - WEST**
SCALE: 1/8" = 1'-0"



JACKSON,
RENFRO
& ASSOCIATES, INC.
ELECTRICAL ENGINEERS
31 INVERNESS CENTER PKWY • SUITE 200
DALLAS, TEXAS 75243
214.343.8800
www.jra-inc.com

ROBERT RENFRO, PE
bobby@jraee.com
(D) 205.536.7114
(P) 205.995.1078
JRA JOB NO. 224172
RING & DESIGN
O • BIRMINGHAM, AL • 35242