



CALVARY CHURCH
CALVARY CHURCH FACILITY ADDITION
BENTONVILLE, AR

Revisions
No. Description Date

Project Number
21010

Date
08/12/25


SECOND FLOOR
POWER PLAN -
EAST

E3.04




JACKSON,
RENFRO
& ASSOCIATES, INC.
ELECTRICAL ENGINEERING & DESIGN
2117 2ND AVENUE SOUTH BIRMINGHAM, AL 35203

ROBERT RENFRO, PE
bobby@jrae.com
(D) 205.536.7114
(P) 205.995.1078
IDA FOR NO. 234172
2117 2ND AVENUE SOUTH BIRMINGHAM, AL 35203

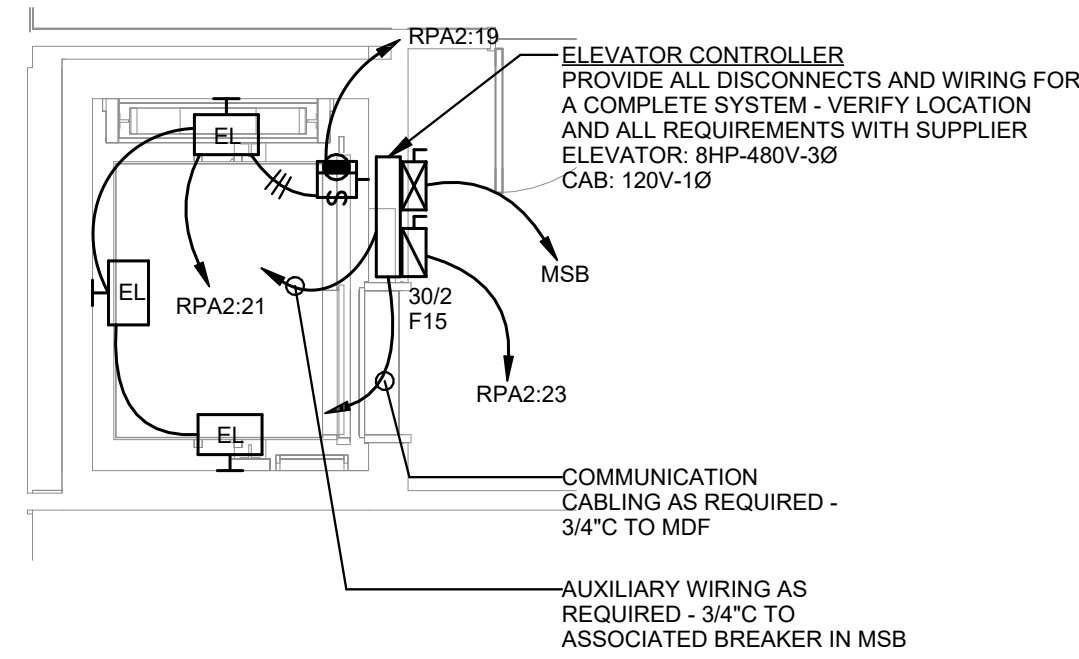

**ENLARGED ELEVATOR SHAFT 1
POWER PLAN**
SCALE: 1/4" = 1'-0"

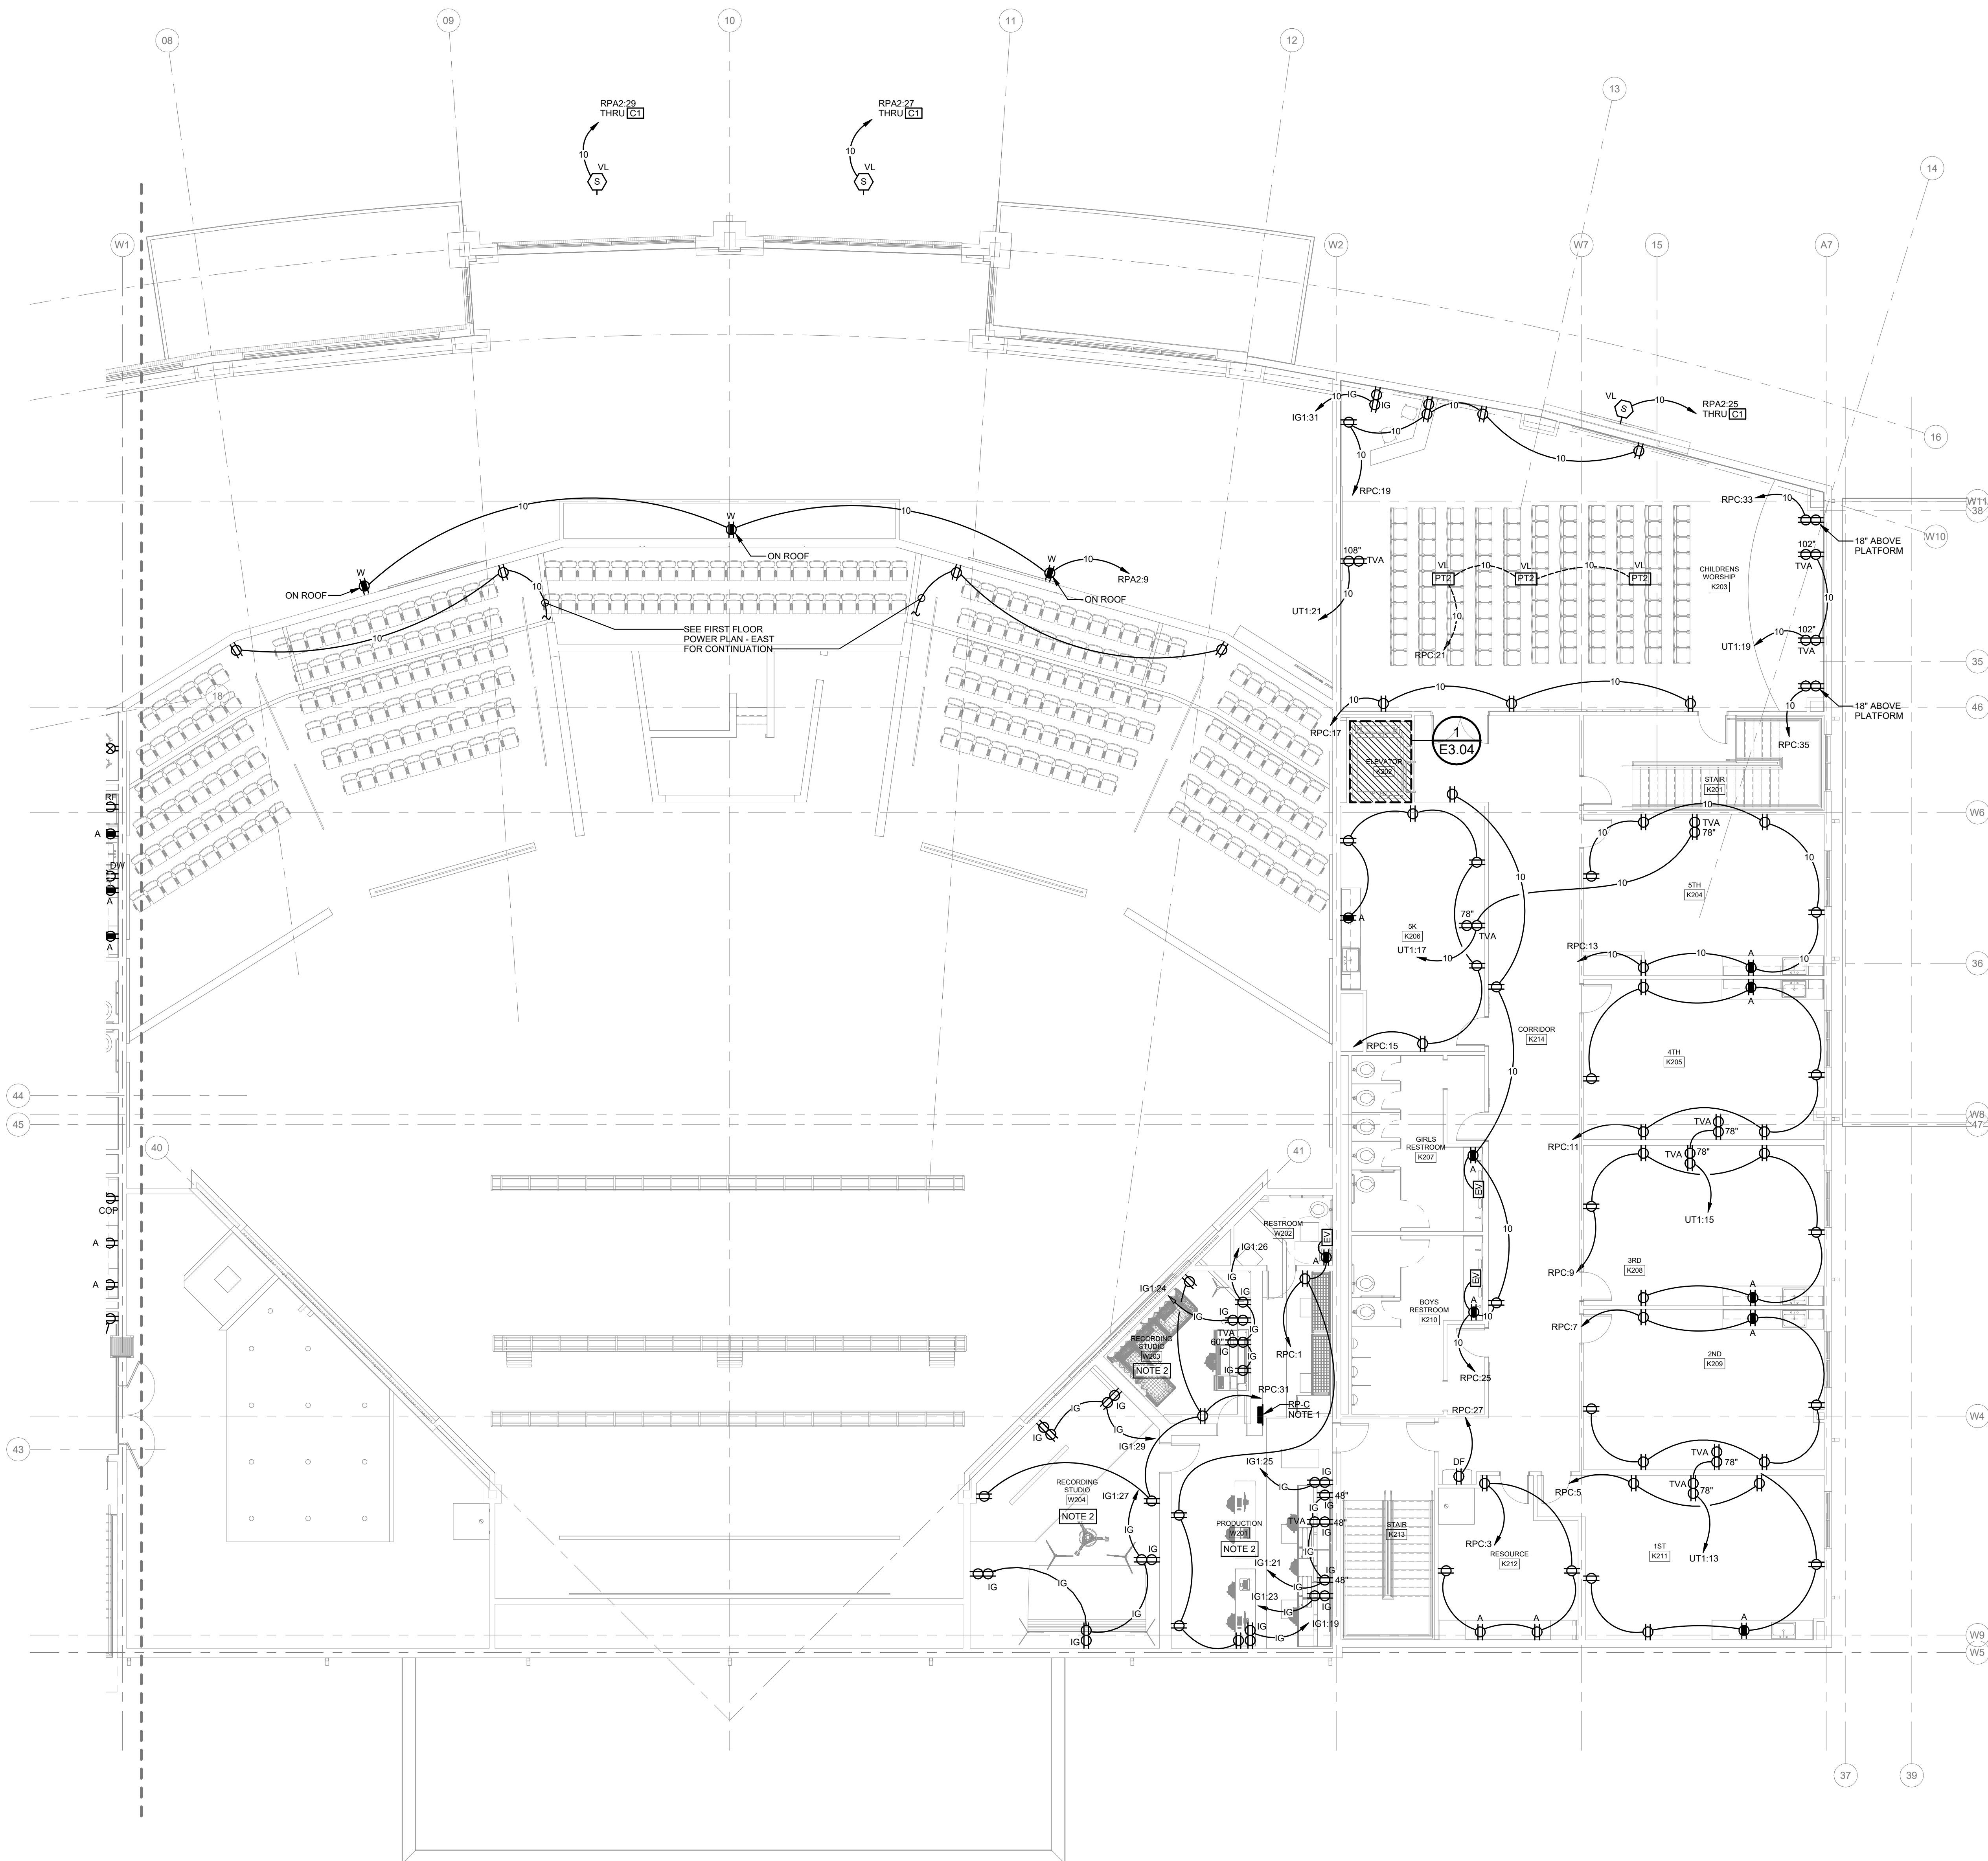

**SECOND FLOOR POWER PLAN -
EAST**
SCALE: 1/8" = 1'-0"

PLAN NOTES

1. PROVIDE THREE (3) 1"E.C. TO ABOVE ACCESSIBLE CEILING FOR FUTURE CIRCUITS.
2. THIS PLAN INDICATES POWER REQUIREMENTS ONLY FOR AVL EQUIPMENT. VERIFY LOCATIONS AND REQUIREMENTS WITH AVL CONTRACTOR PRIOR TO ROUGH-IN. REFER TO AVL PLANS FOR ADDITIONAL REQUIREMENTS INCLUDING RACEWAY, OUTLETS, CABLE TRAY, FLOOR POCKETS, ETC. FOR ALL LOW VOLTAGE CONNECTIONS.