

CALVARY CHURCH
CALVARY CHURCH FACILITY ADDITION
BENTONVILLE, AR


Revisions		
No.	Description	Date

Project Number
21010


Date
/12/25

AVL RCP POWER PLANS


E3.05

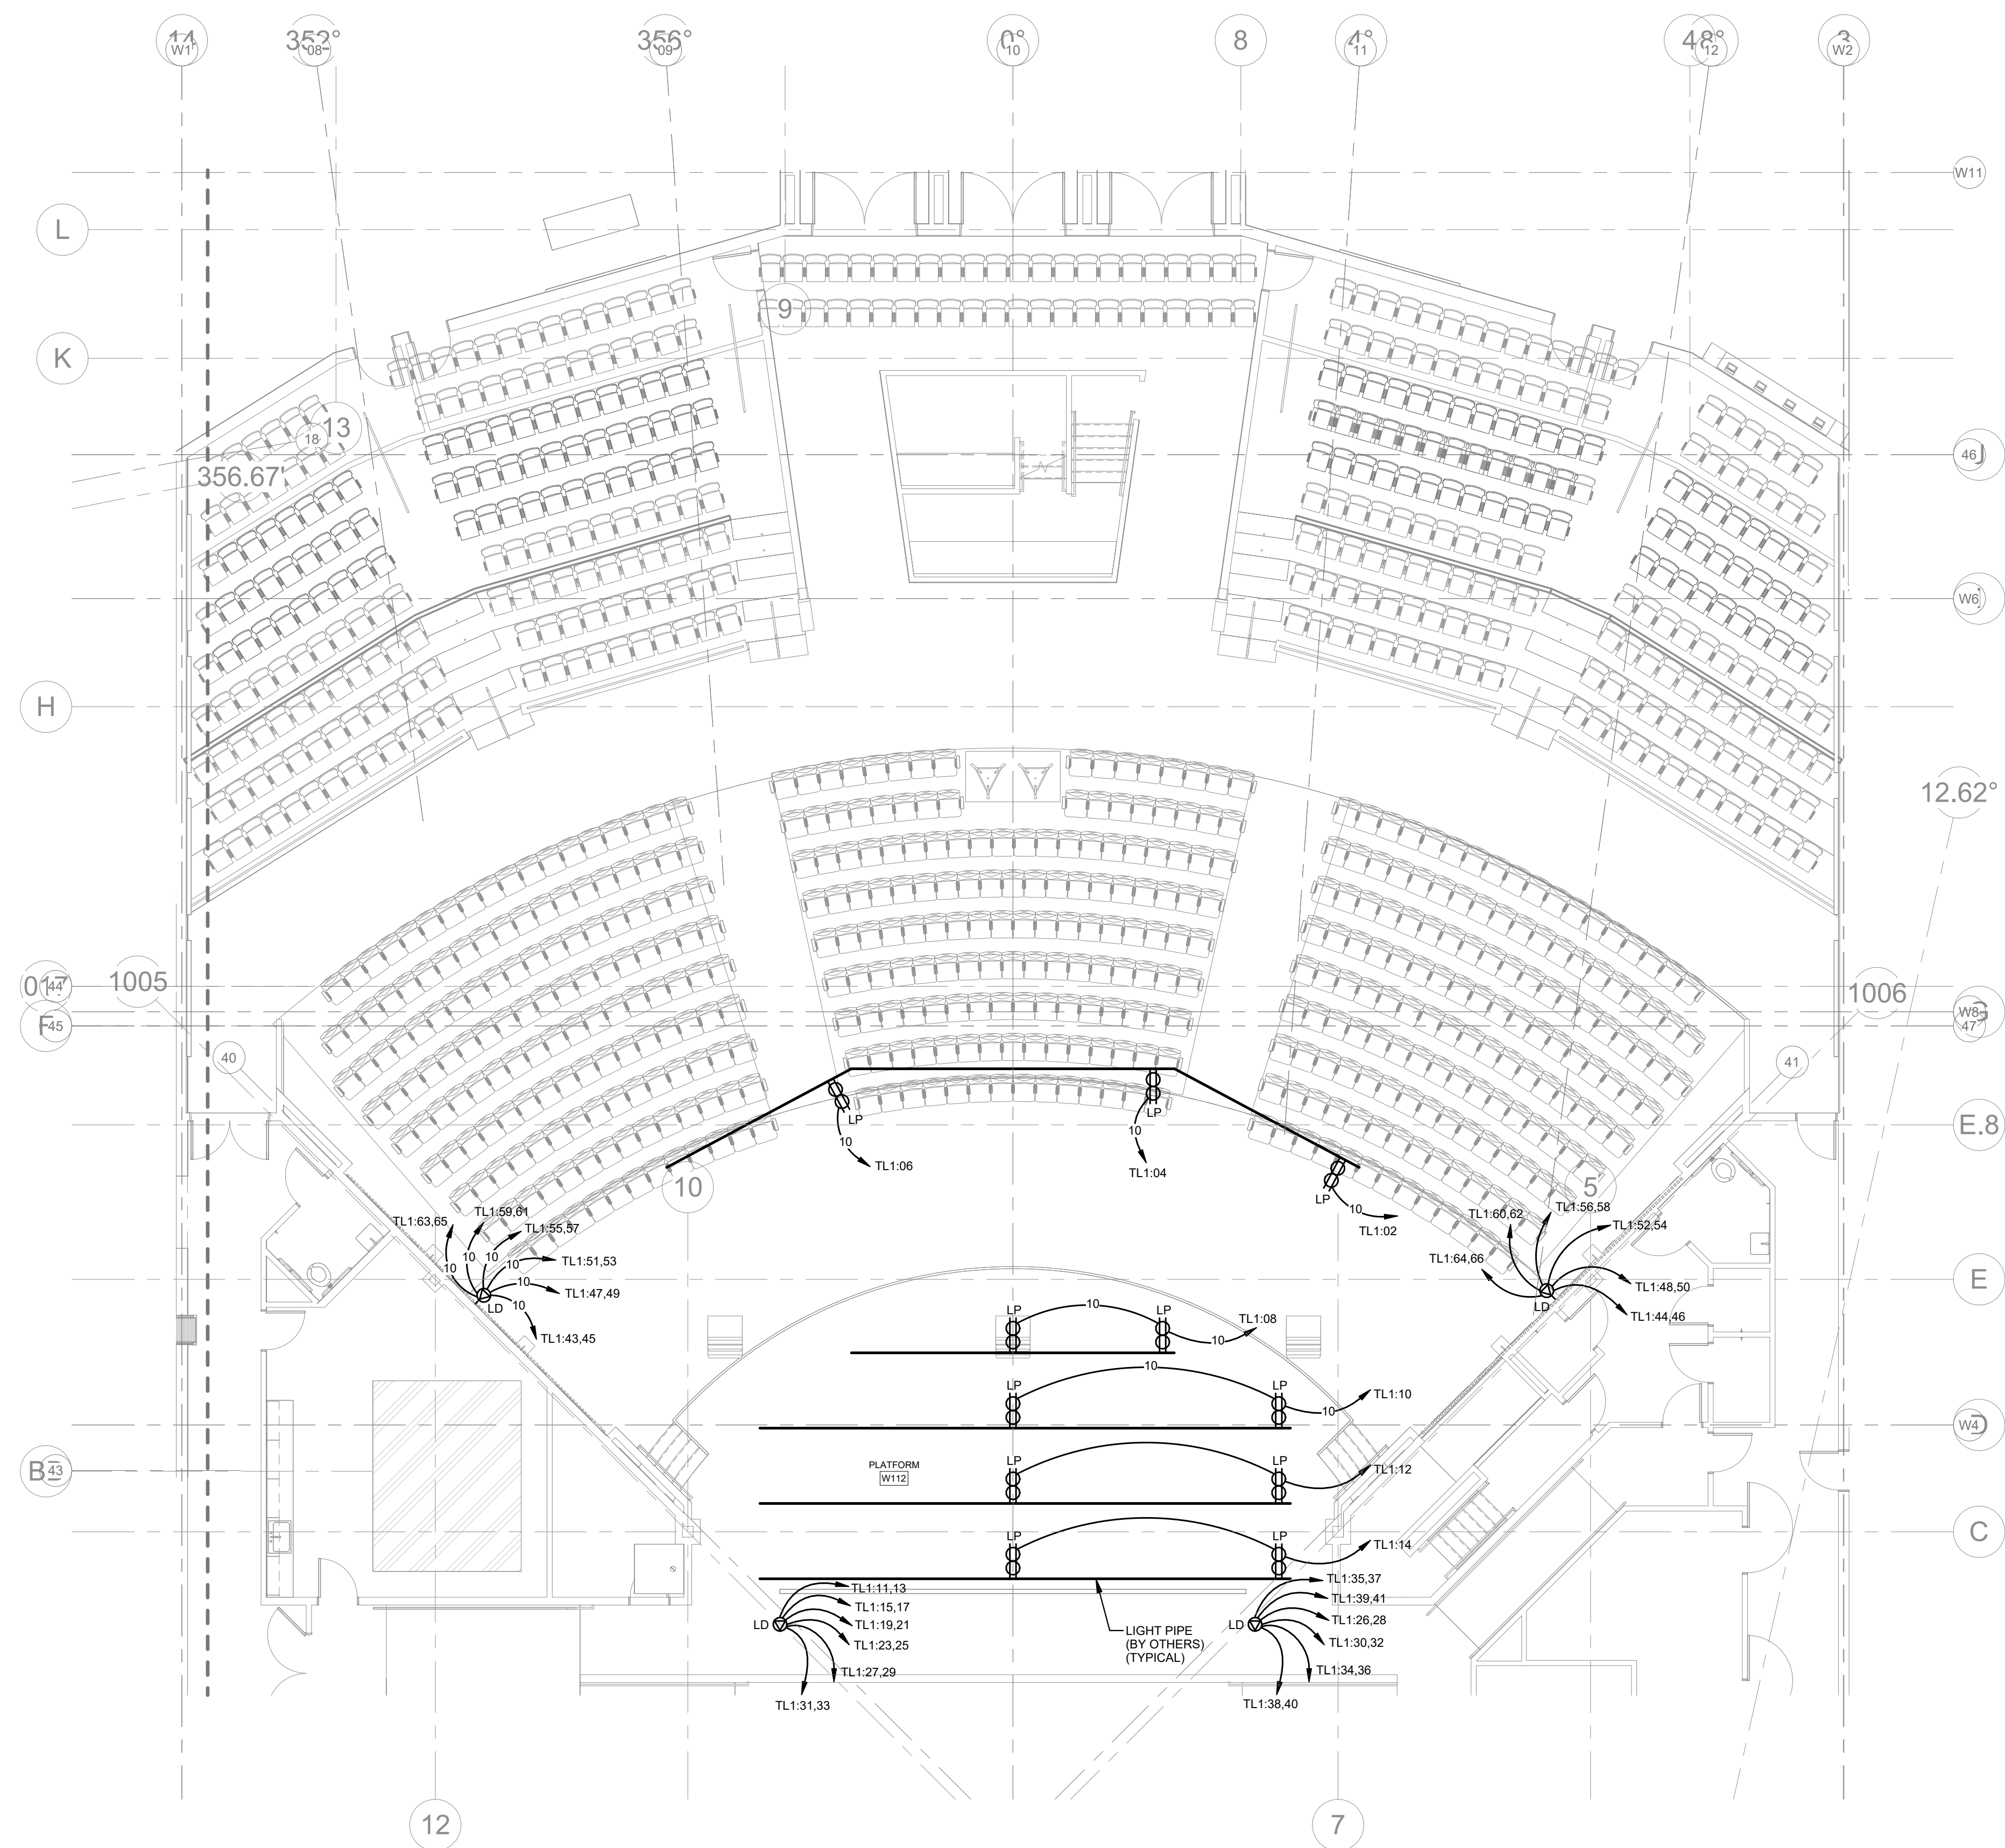

 AVL RCP POWER PLAN -
WORSHIP
SCALE: 1/8" = 1'-0"

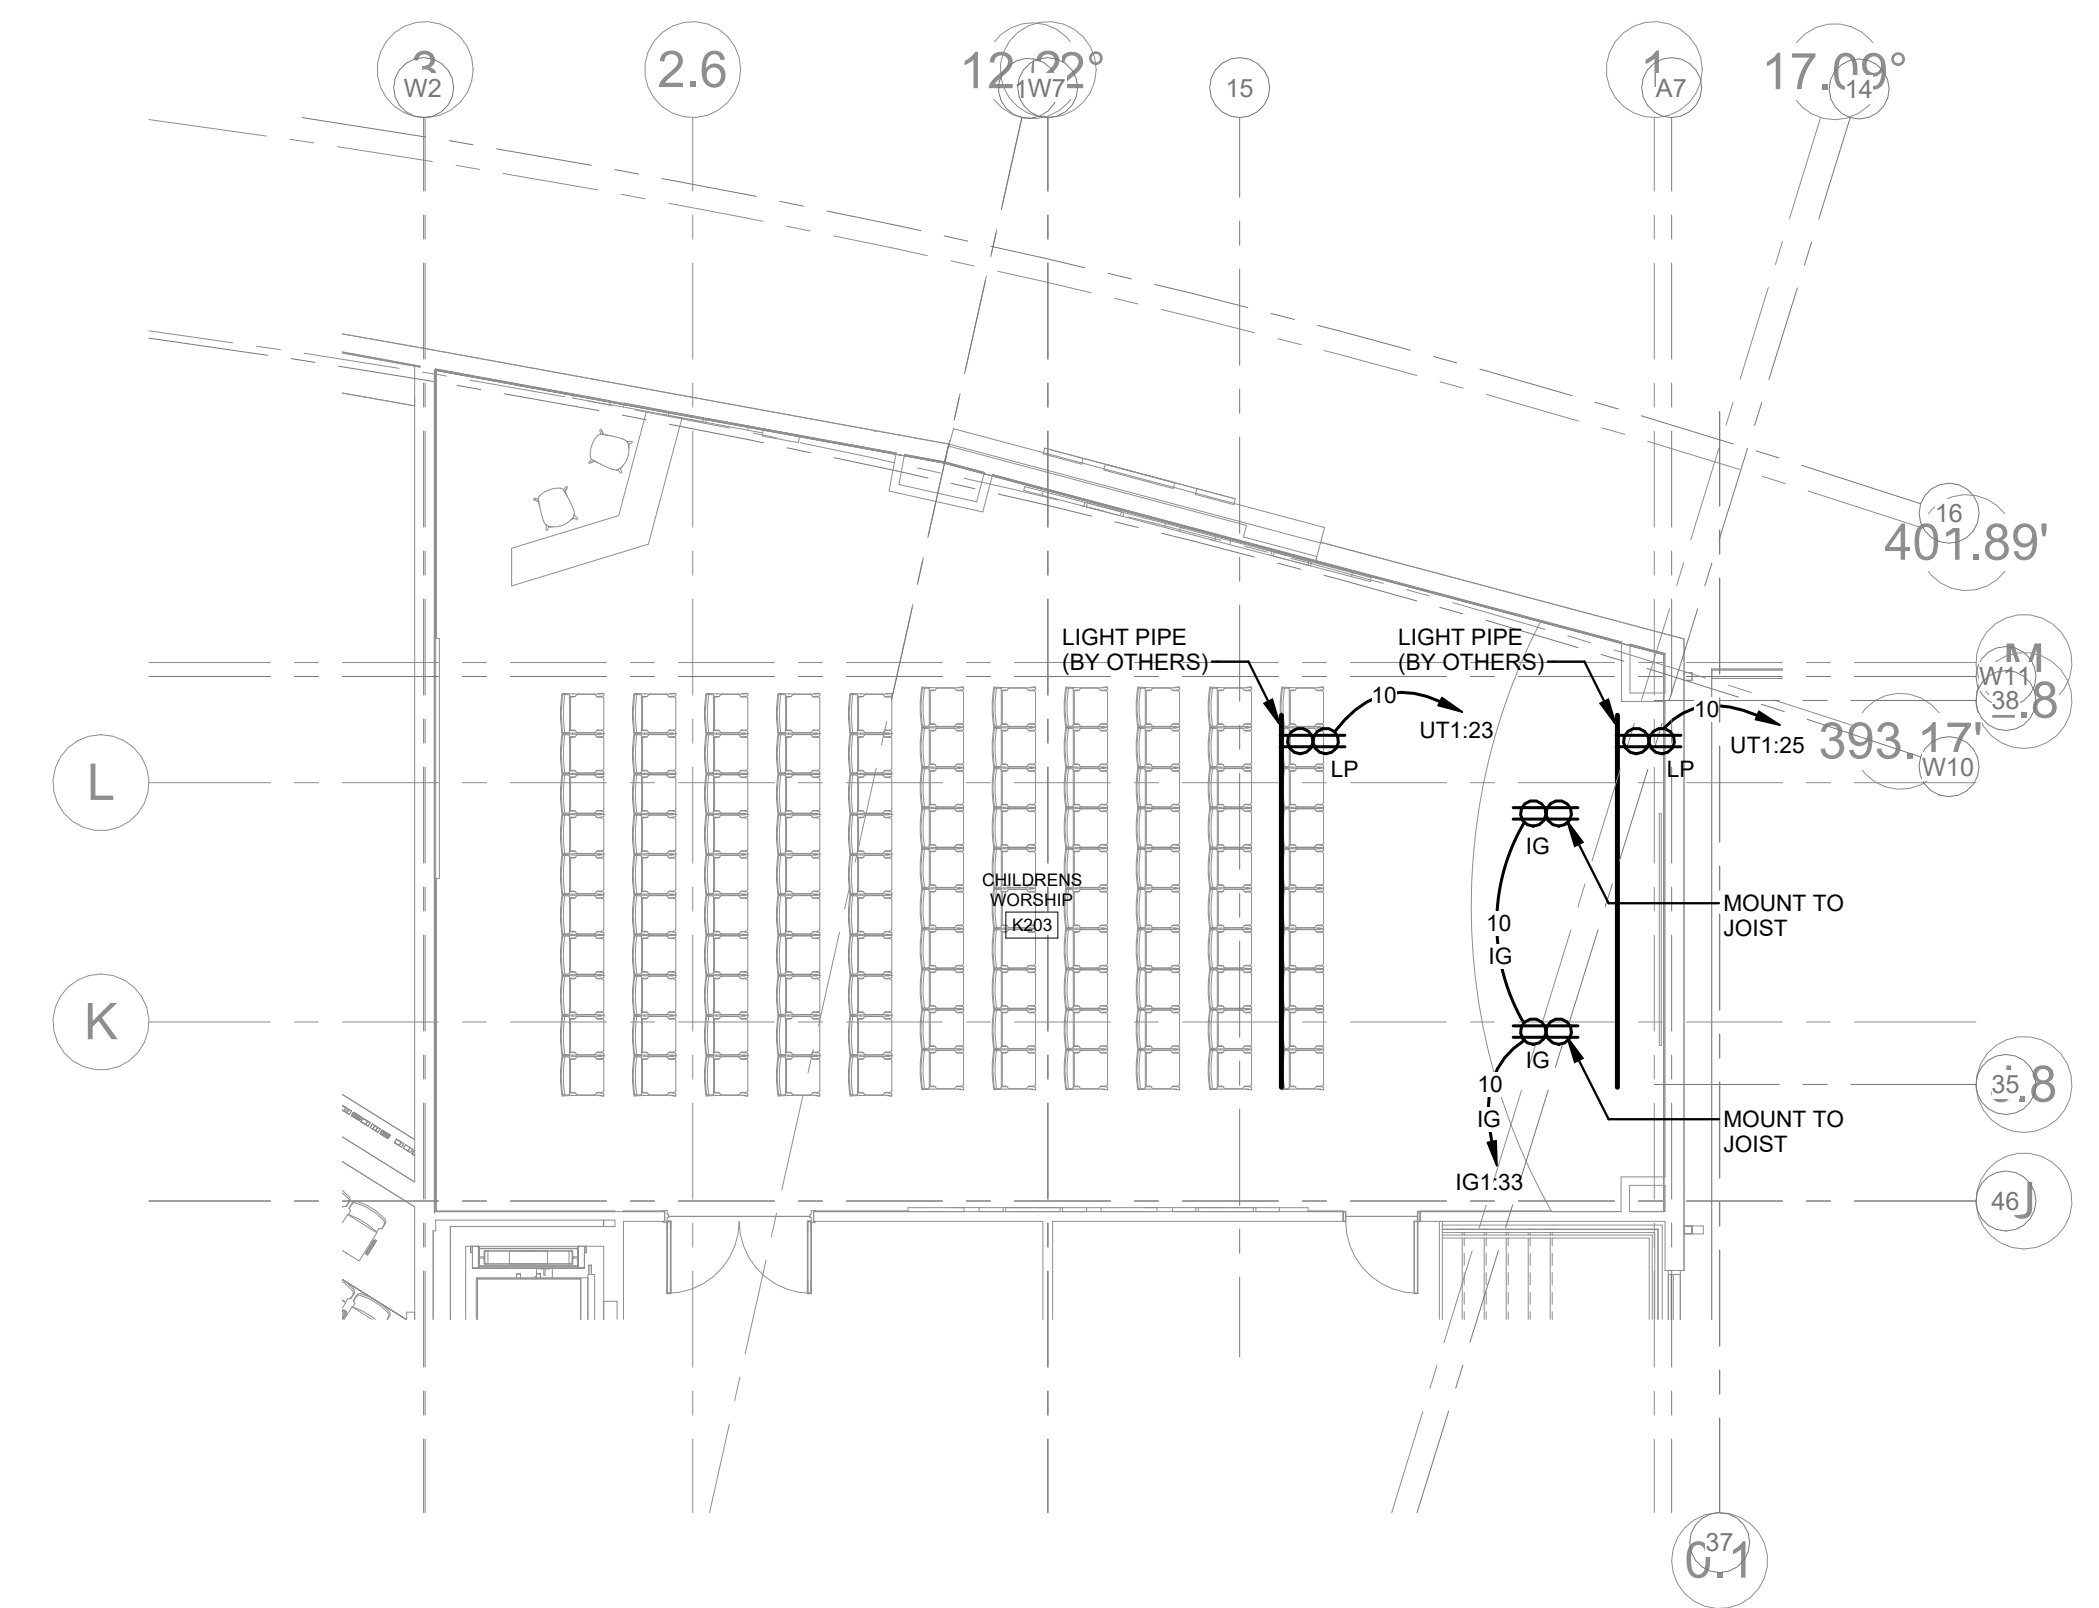

 AVL RCP POWER PLAN -
CHILDREN'S WORSHIP
SCALE: 1/8" = 1'-0"

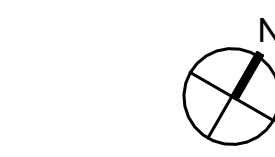

AVL RCP POWER PLAN - CHILDREN'S WORSHIP

SCALE: 1/8" = 1'-0"

SHEET NOTES

1. THIS PLAN INDICATES POWER REQUIREMENTS ONLY FOR AVL EQUIPMENT. VERIFY LOCATIONS AND REQUIREMENTS WITH AVL CONTRACTOR PRIOR TO ROUGH-IN. REFER TO AVL PLANS FOR ADDITIONAL REQUIREMENTS INCLUDING RACEWAY, OUTLETS, CABLE TRAY, FLOOR POCKETS, ETC. FOR ALL LOW VOLTAGE CONNECTIONS.



JACKSON,
RENFRO
& ASSOCIATES, INC.
ELECTRICAL ENGINEERS
31 INVERNESS CENTER PKWY • SUITE 300
DALLAS, TEXAS 75243
(214) 343-8800

ROBERT RENFRO, PE
bobby@jraee.com
(D) 205.536.7114
(P) 205.995.1078
JRA JOB NO. 224172
NG & DESIGN
BIRMINGHAM, AL • 35242