

CALVARY CHURCH
CALVARY CHURCH FACILITY ADDITION
BENTONVILLE, AR



Revisions		
No.	Description	Date

Project Number
21010

Date
08/12/25

FIRST FLOOR
HVAC ELECTRICAL
PLAN - WEST

E5.01

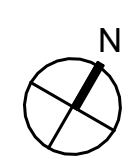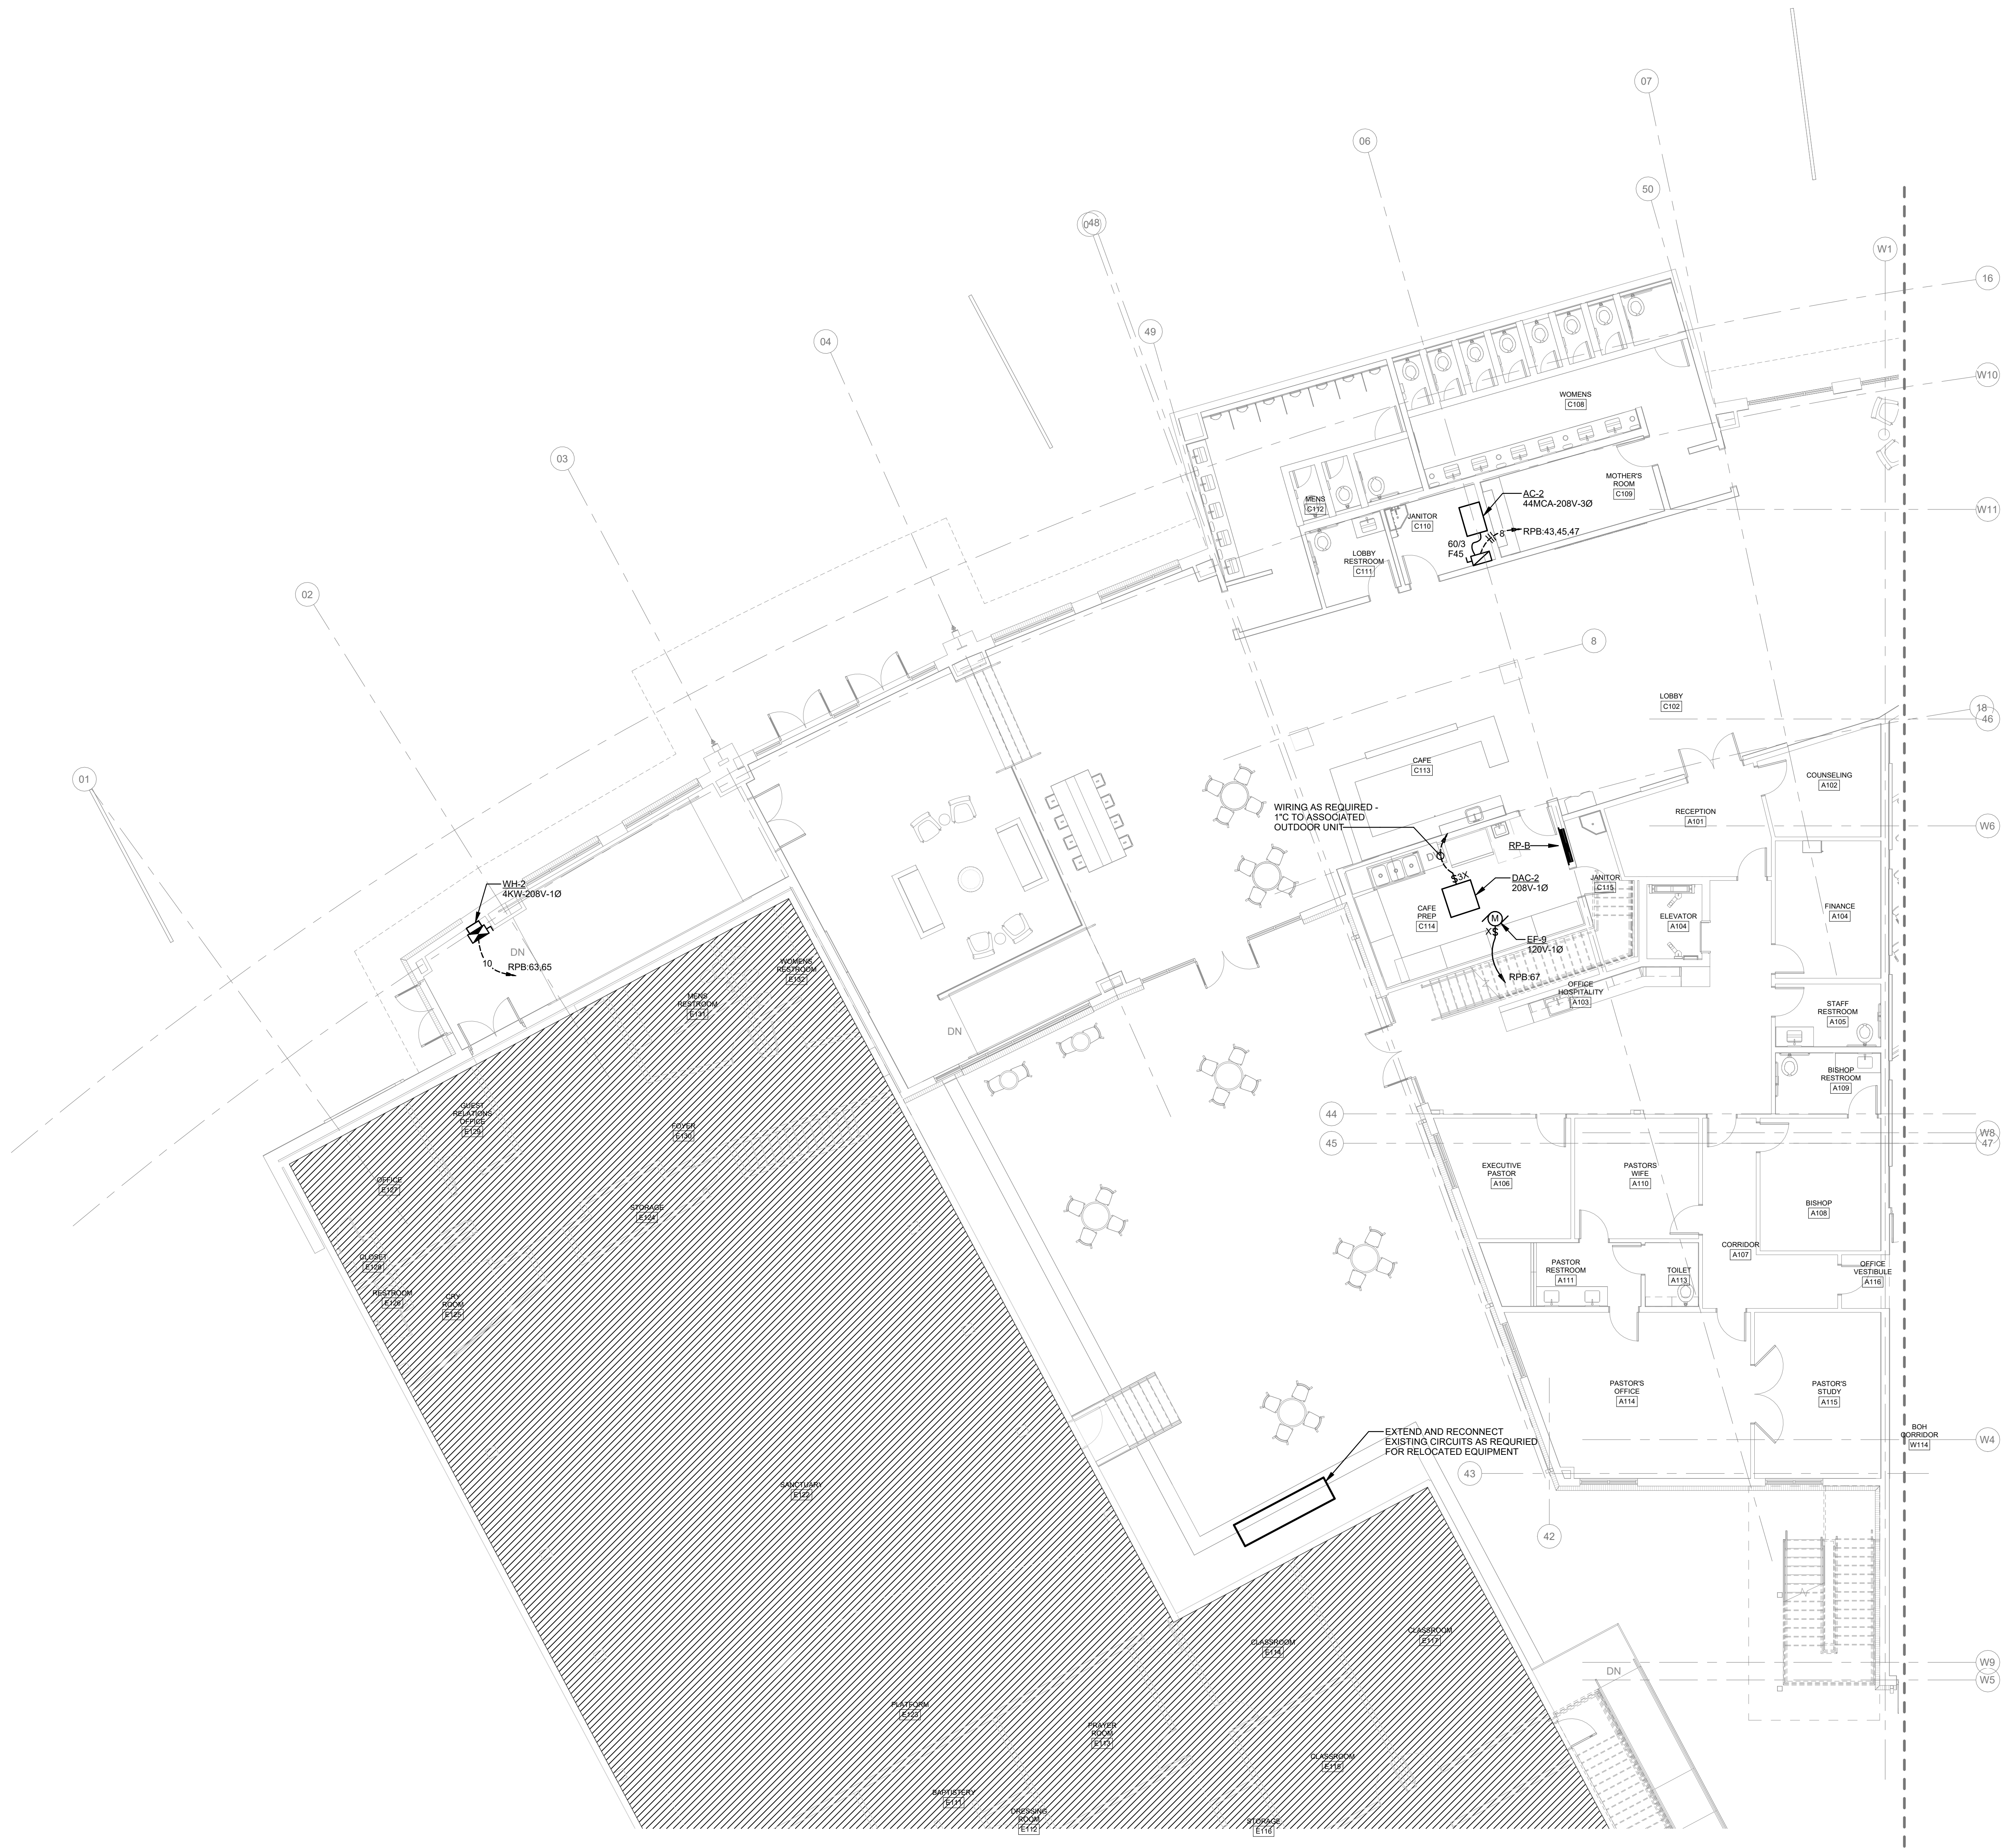

FIRST FLOOR HVAC
ELECTRICAL PLAN - WEST
SCALE: 1/8" = 1'-0"



JACKSON,
RENFRO
& ASSOCIATES, INC.
ELECTRICAL ENGINEERING & DESIGN

ROBERT RENFRO, PE
bobby@jraee.com
(D) 205-536-7114
(P) 205-995-1078
IRA FOR NO. 234172
UNIVERSITY CENTER TOWER • SUITE 300 • BIRMINGHAM, AL 35202