

CALVARY CHURCH
CALVARY CHURCH FACILITY ADDITION
BENTONVILLE, AR


Revisions		
No.	Description	Date

Project Number
21010

Date
/12/25

FIRST FLOOR
VAC ELECTRICAL
PLAN - EAST

E5.02

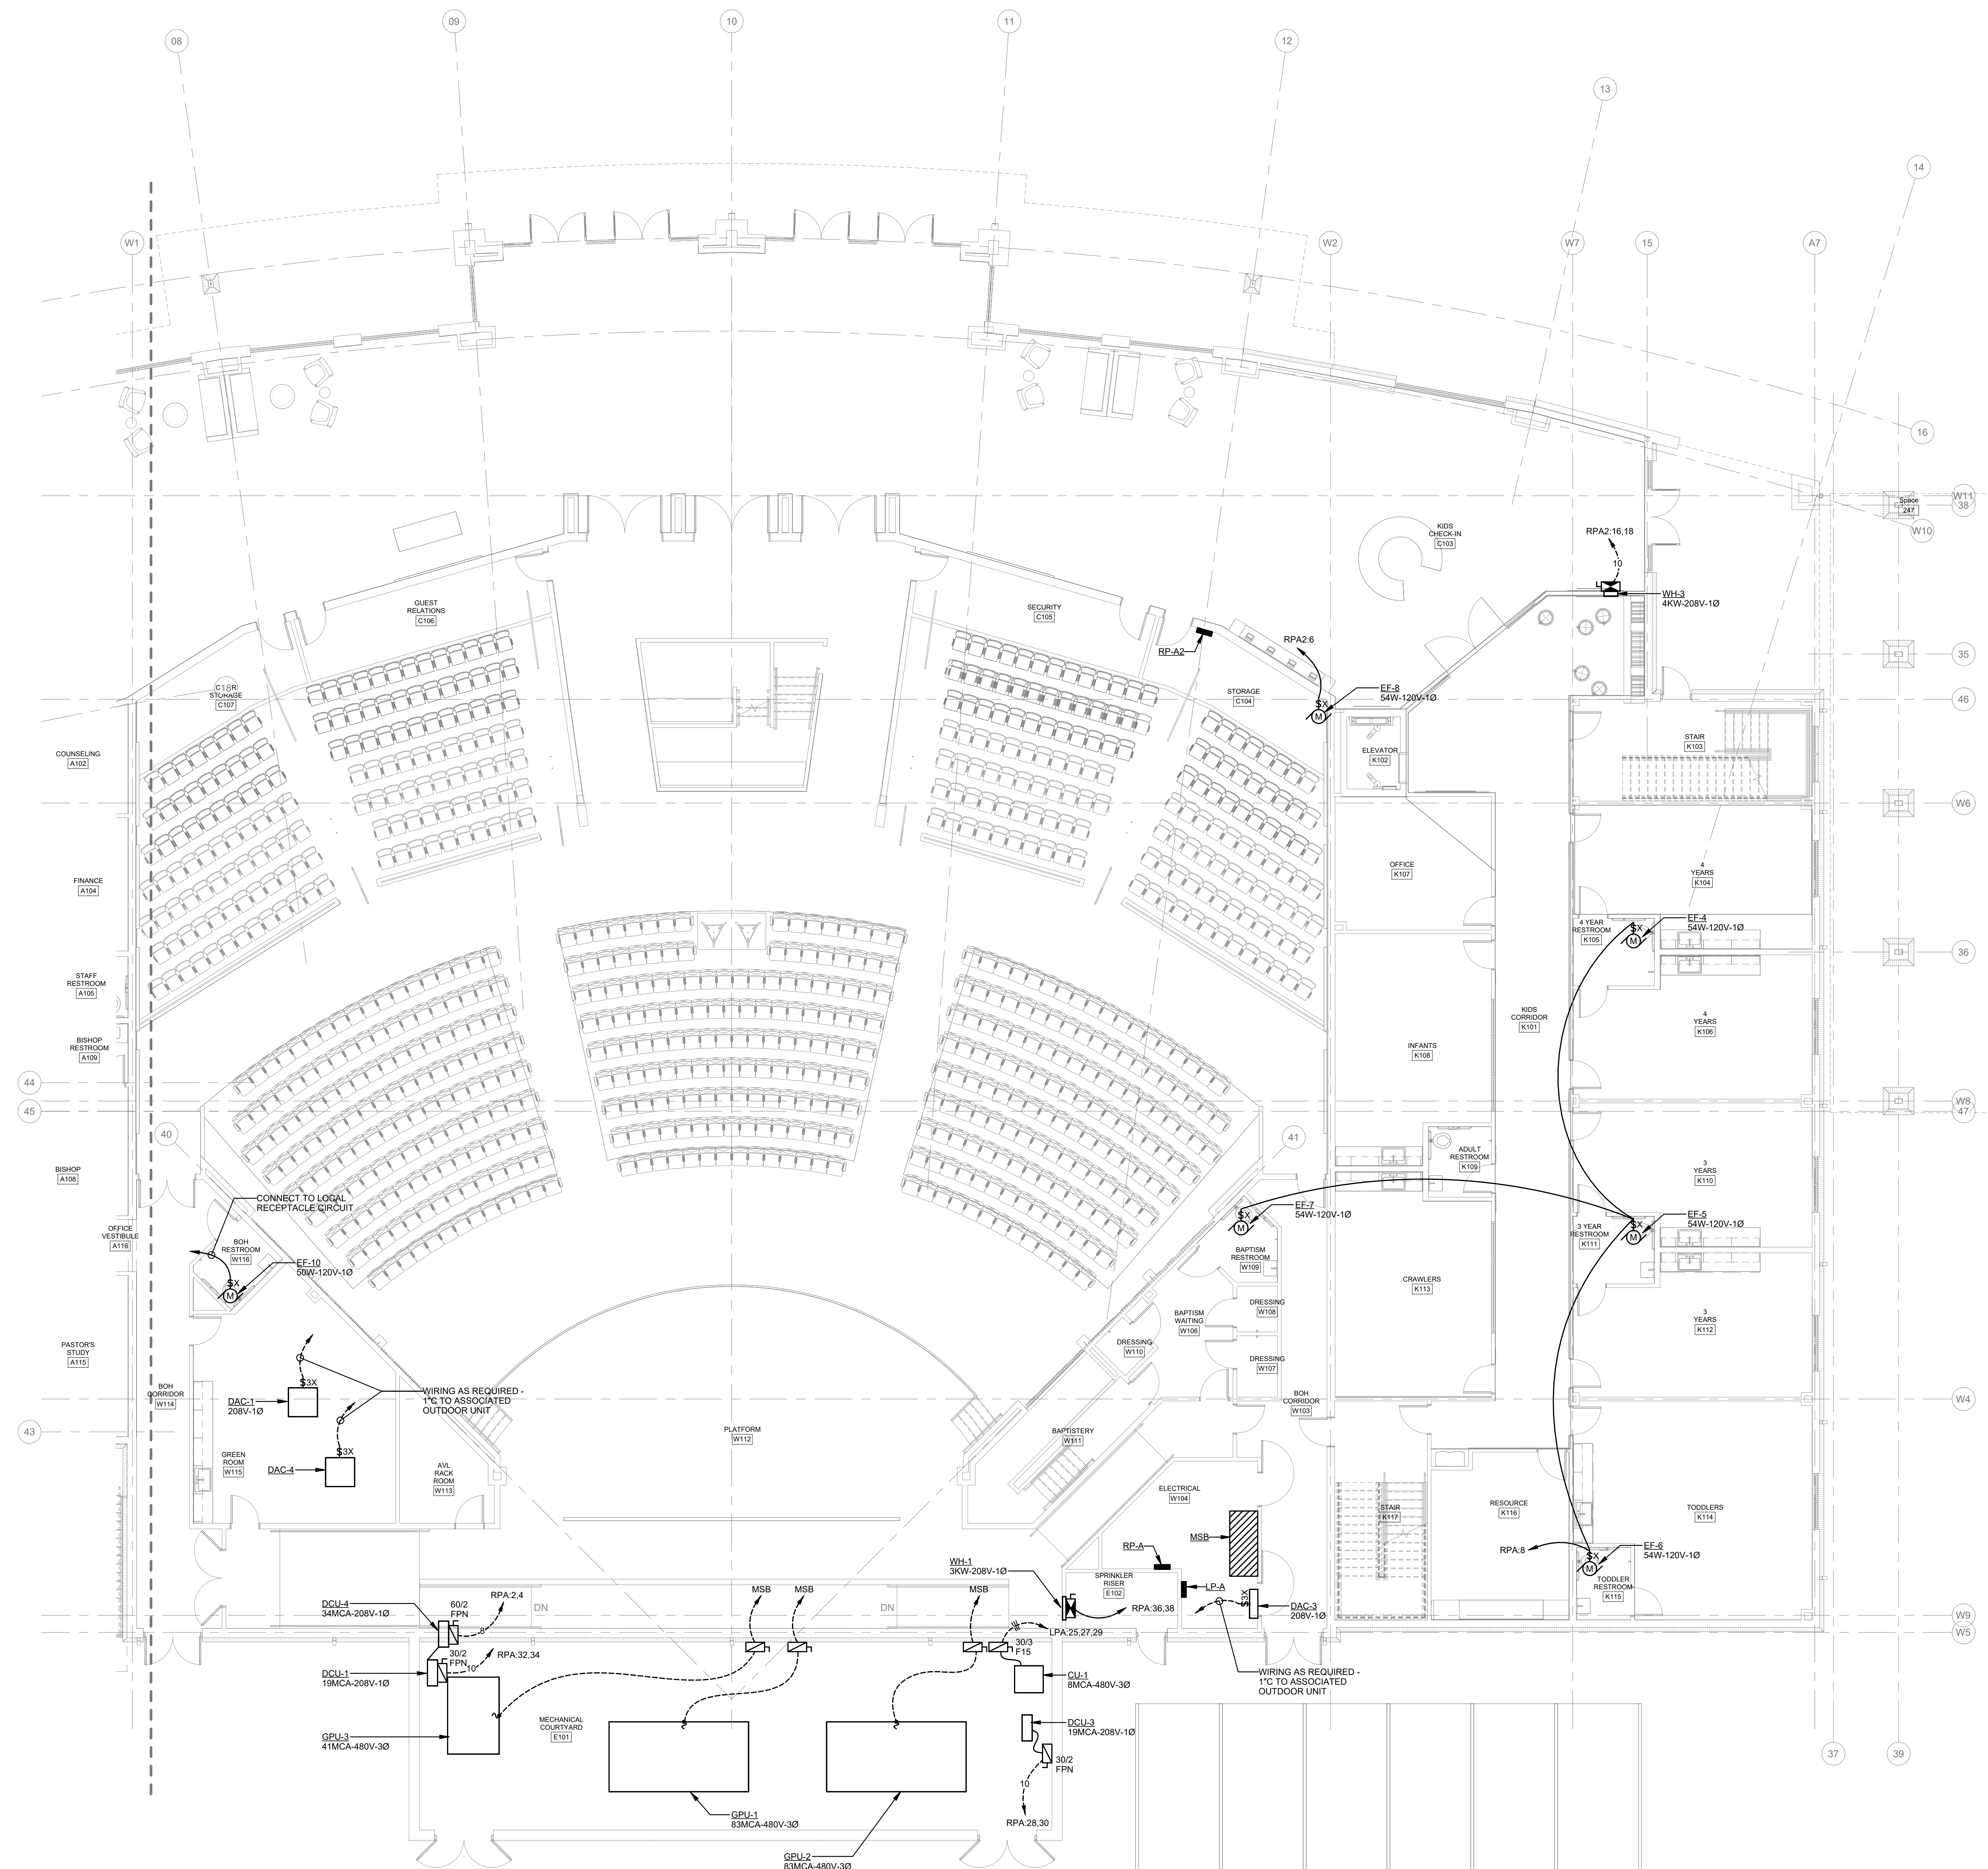

FIRST FLOOR HVAC
ELECTRICAL PLAN - EAST
SCALE: 1/8" = 1'-0"



JACKSON,
RENFRO
& ASSOCIATES, INC.
ELECTRICAL ENGINEERS
31 INVERNESS CENTER PKWY • SUITE 200
ANN ARBOR, MI 48106-1500
734/769-1100 • FAX 734/769-1101
WWW.JACKSONRENFRO.COM

ROBERT RENFRO, PE
bobby@jraee.com
(D) 205.536.7114
(P) 205.995.1078
JRA JOB NO. 224172
ING & DESIGN
BIRMINGHAM, AL • 35242