

CALVARY CHURCH
CALVARY CHURCH FACILITY ADDITION
BENTONVILLE, AR



Revisions
No. Description Date

Project Number
21010

Date
08/12/25

SECOND FLOOR
HVAC ELECTRICAL
PLAN - WEST

E5.03

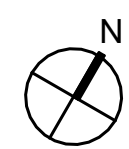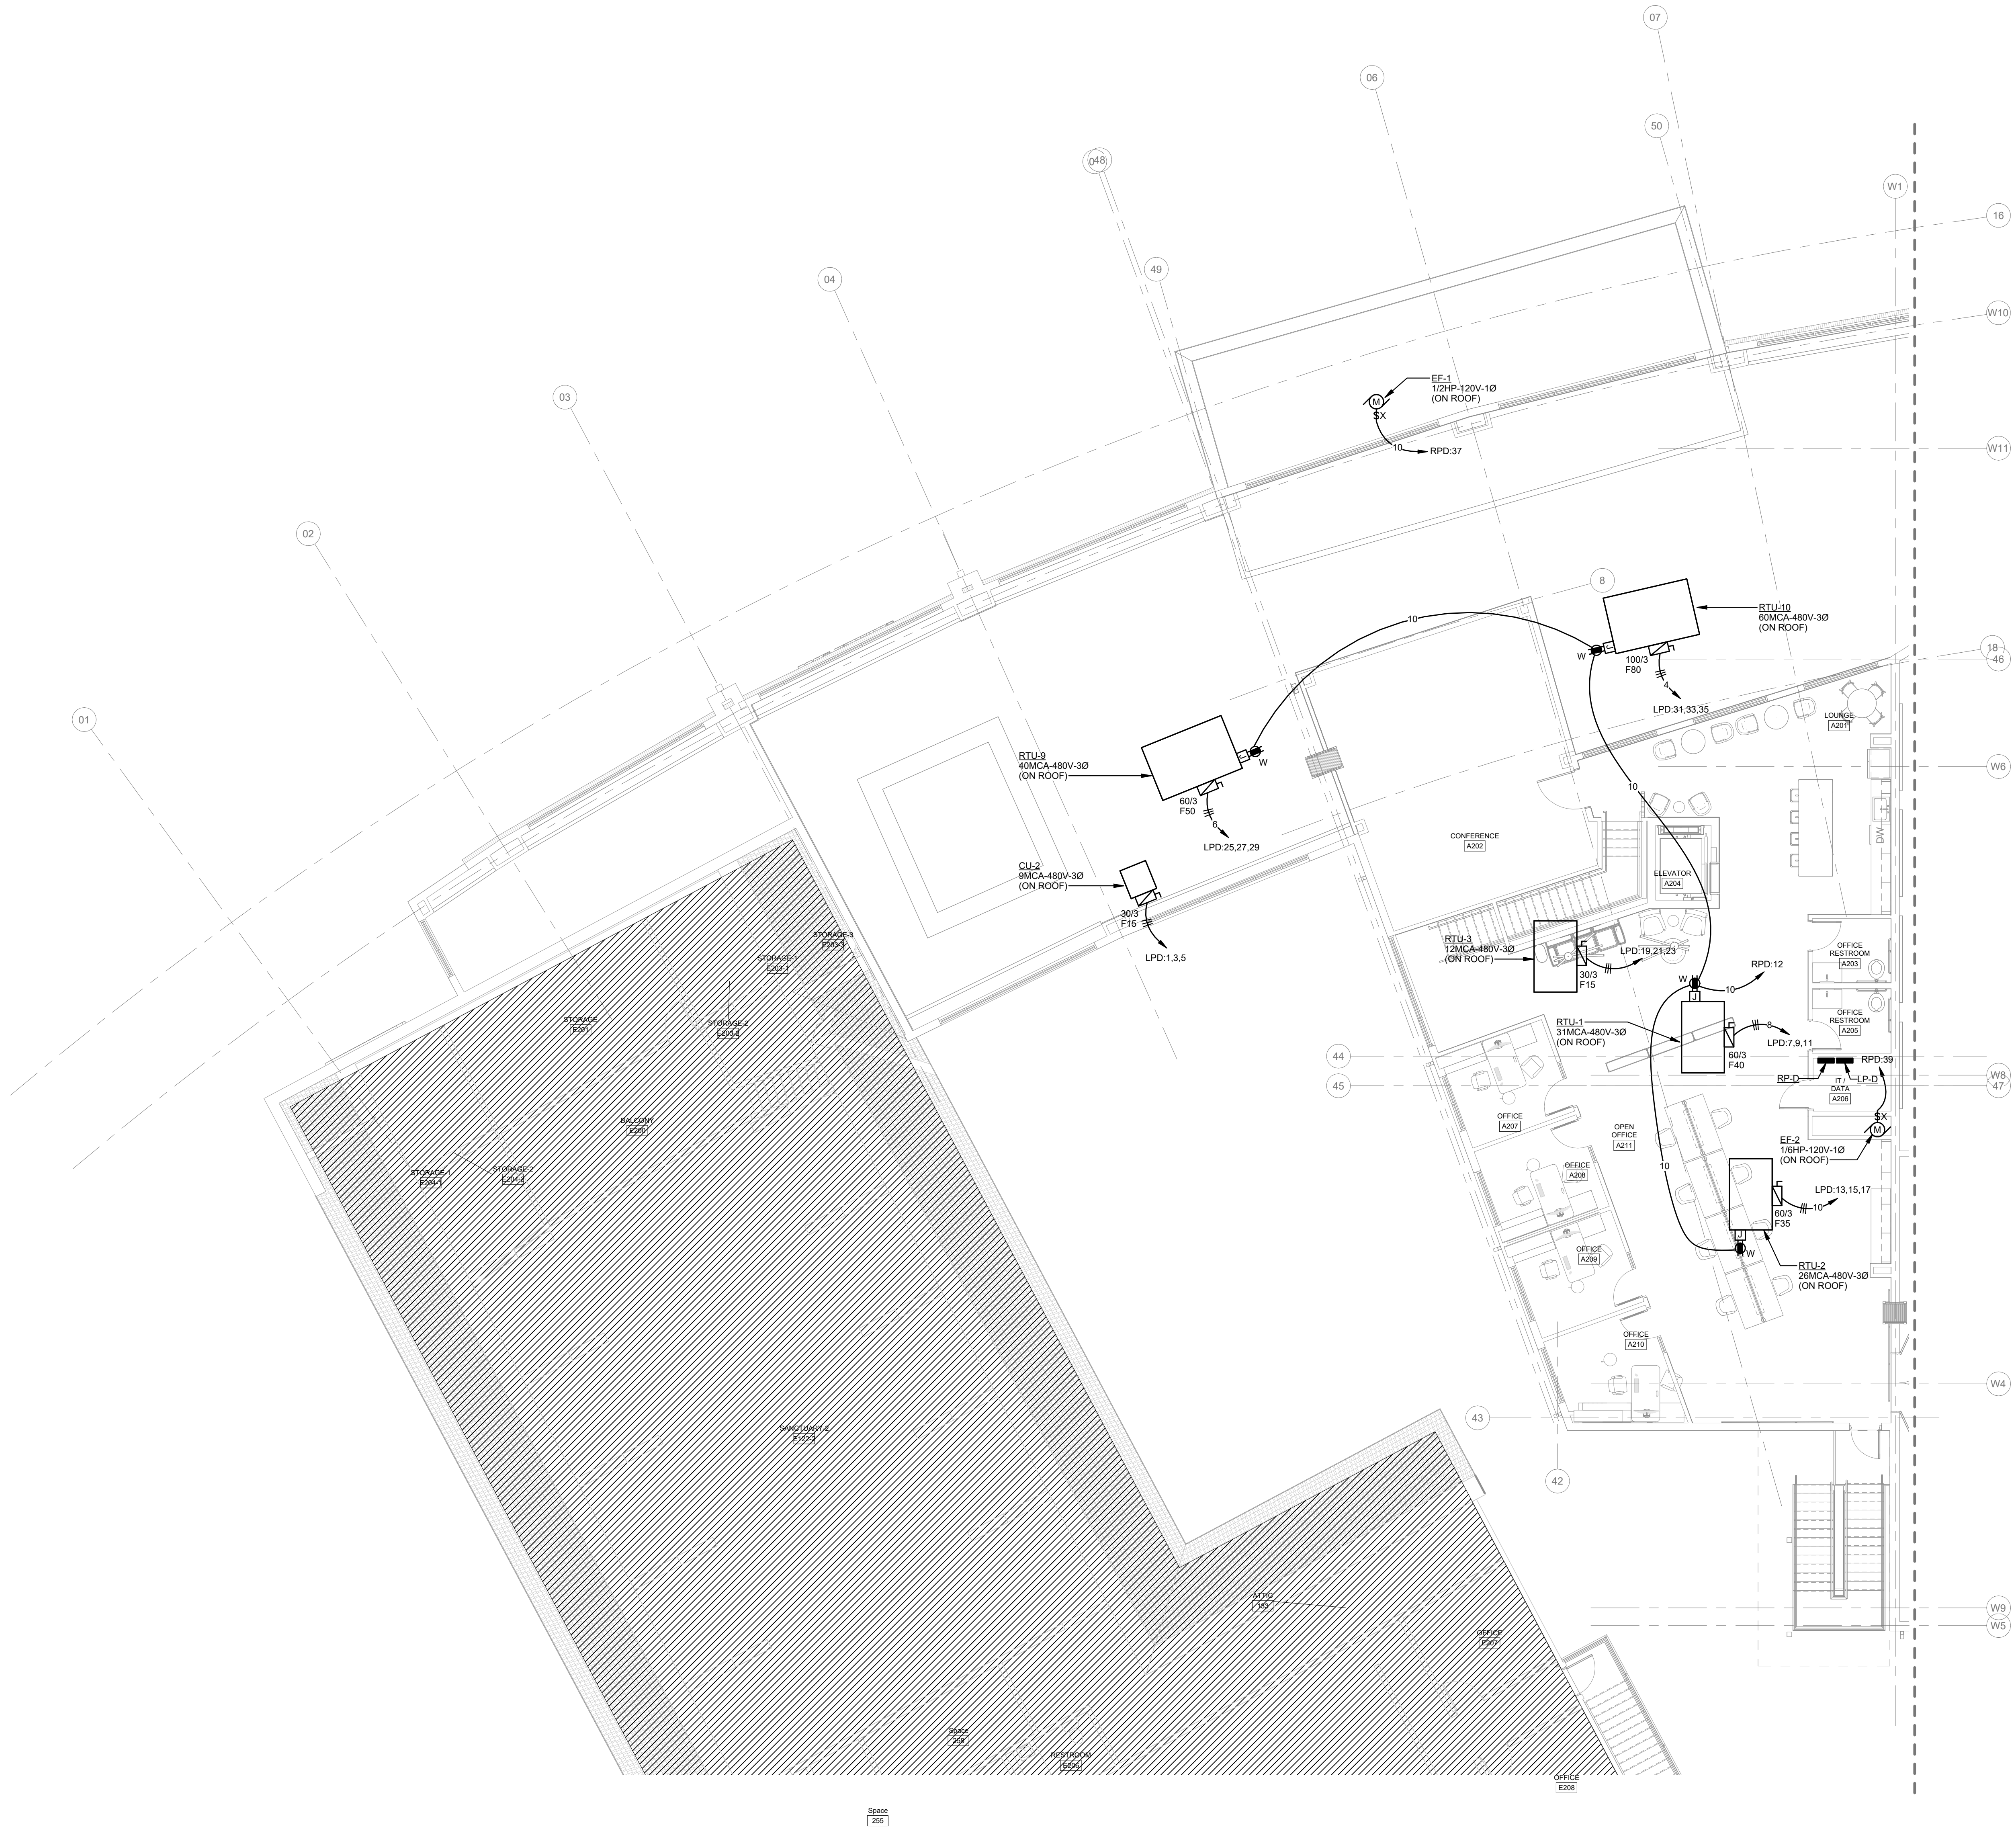

SECOND FLOOR HVAC
ELECTRICAL PLAN - WEST
SCALE: 1/8" = 1'-0"



JACKSON,
RENFRO
& ASSOCIATES, INC.
ELECTRICAL ENGINEERING & DESIGN
11 UNIVERSITY CENTER PARK • SUITE 300 • BIRMINGHAM, AL 35202

ROBERT RENFRO, PE
bobby@jrae.com
(D) 205-536-7114
(P) 205-995-1078
H&A FOR NO. 234172