

CALVARY CHURCH
CALVARY CHURCH FACILITY ADDITION
BENTONVILLE, AR



Revisions
No. Description Date

Project Number
21010

Date
08/12/25

SECOND FLOOR
HVAC ELECTRICAL
PLAN - EAST

E5.04

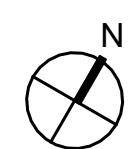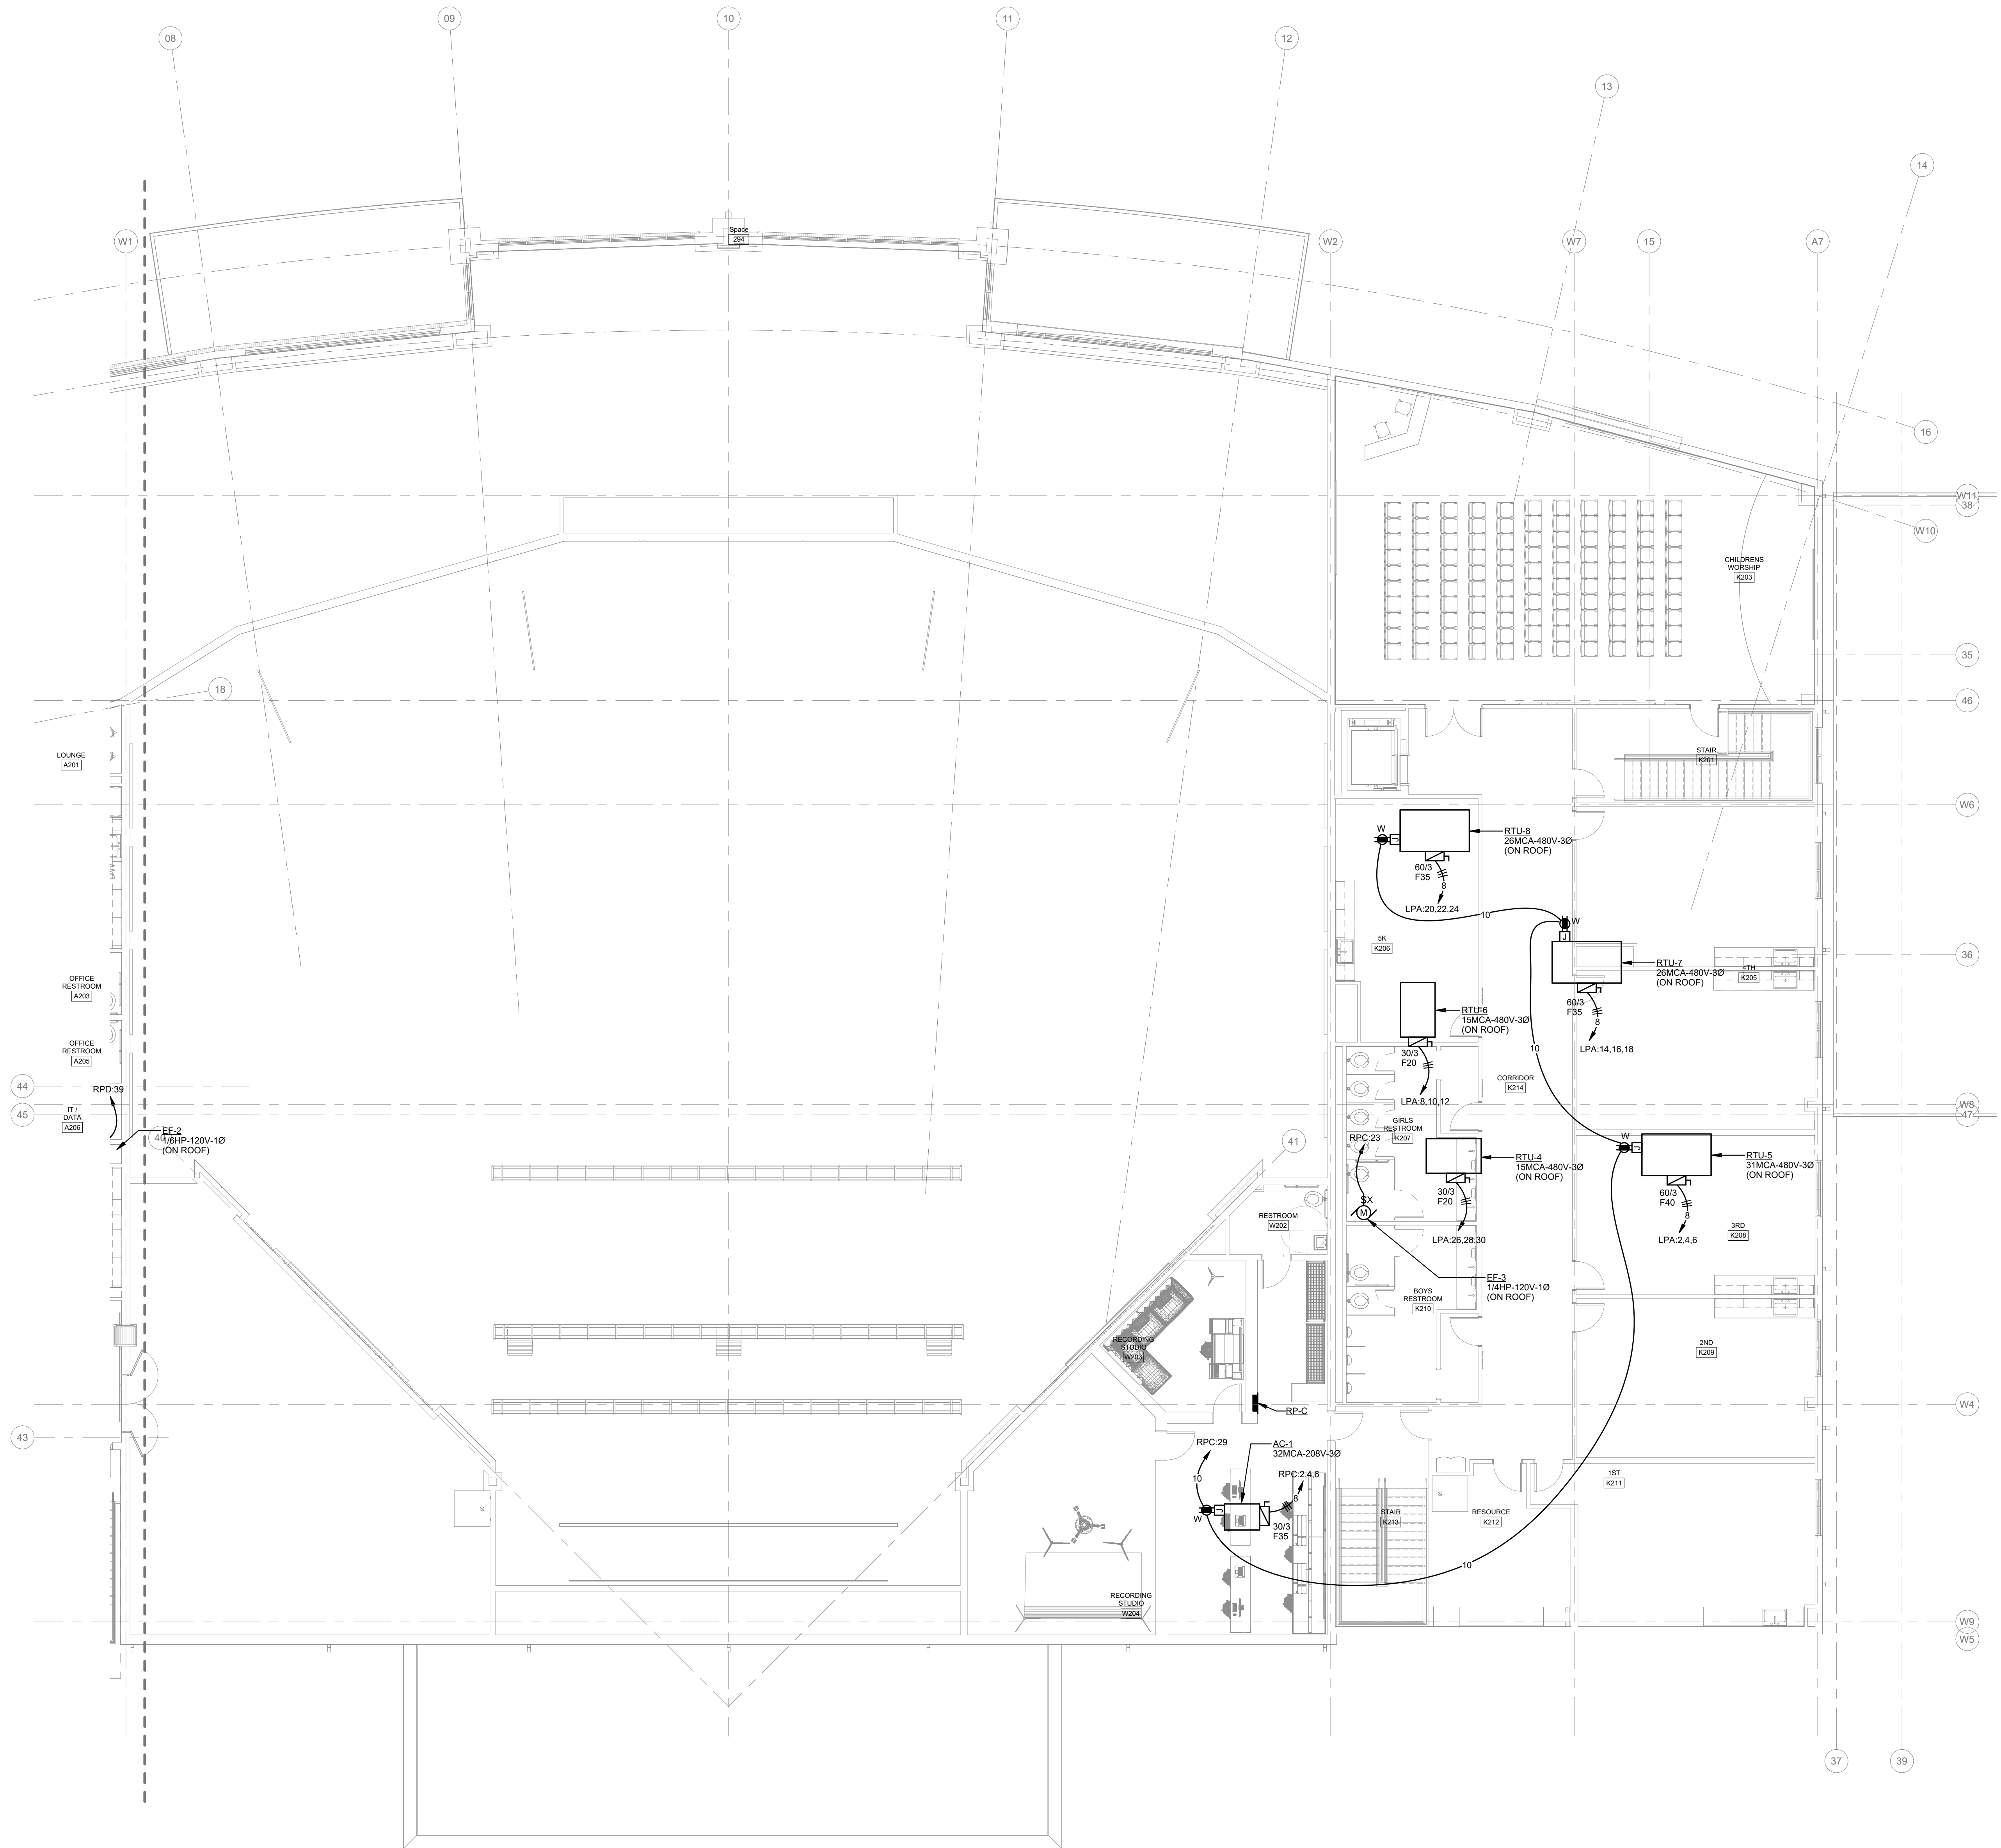

SECOND FLOOR HVAC
ELECTRICAL PLAN - EAST
SCALE: 1/8" = 1'-0"



JACKSON,
RENFRO
& ASSOCIATES, INC.
ELECTRICAL ENGINEERING & DESIGN
11000 CENTER POINT • SUITE 300 • BIRMINGHAM, AL 35242
ROBERT RENFRO, PE
bobby@jrae.com
(D) 205-536-7114
(P) 205-995-1078
IRA FOR NO. 234172