




1 TYP. PATIENT OF SIZE ROOM
1/4" = 1'-0"

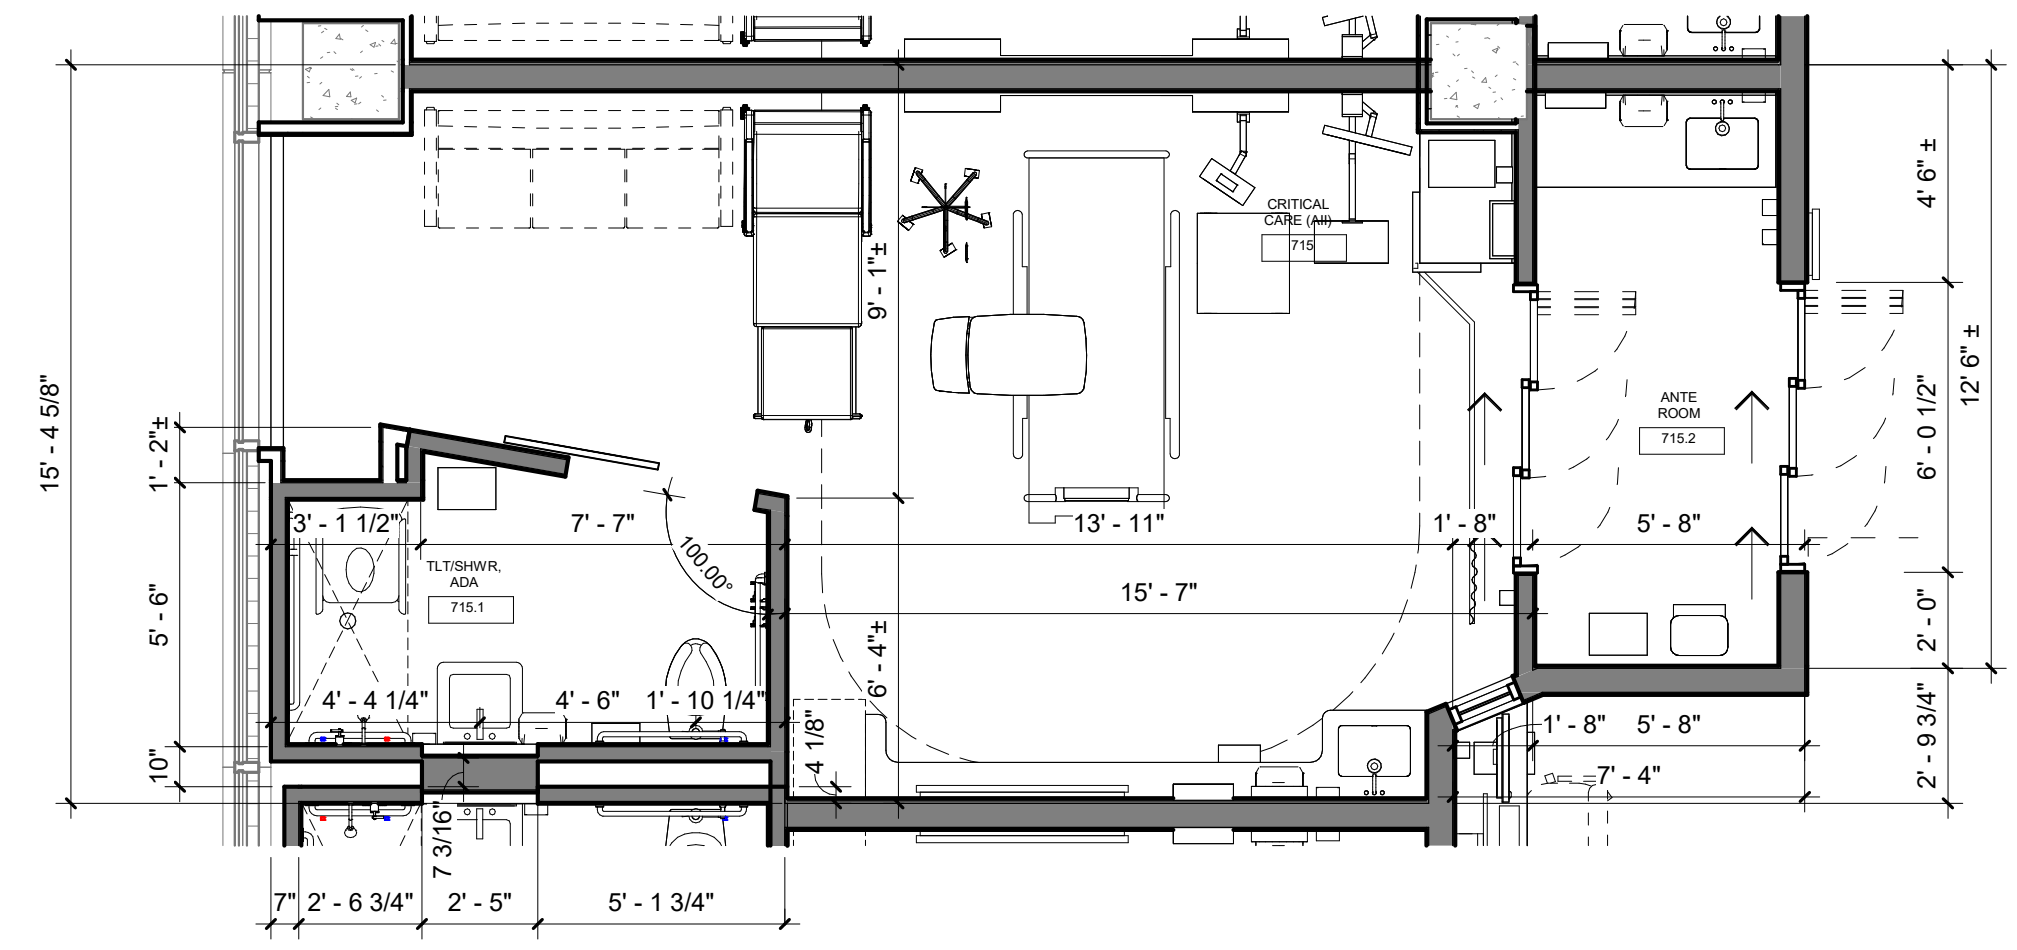


2 TYP. ISOLATION ICU ROOM
1/4" = 1'-0"

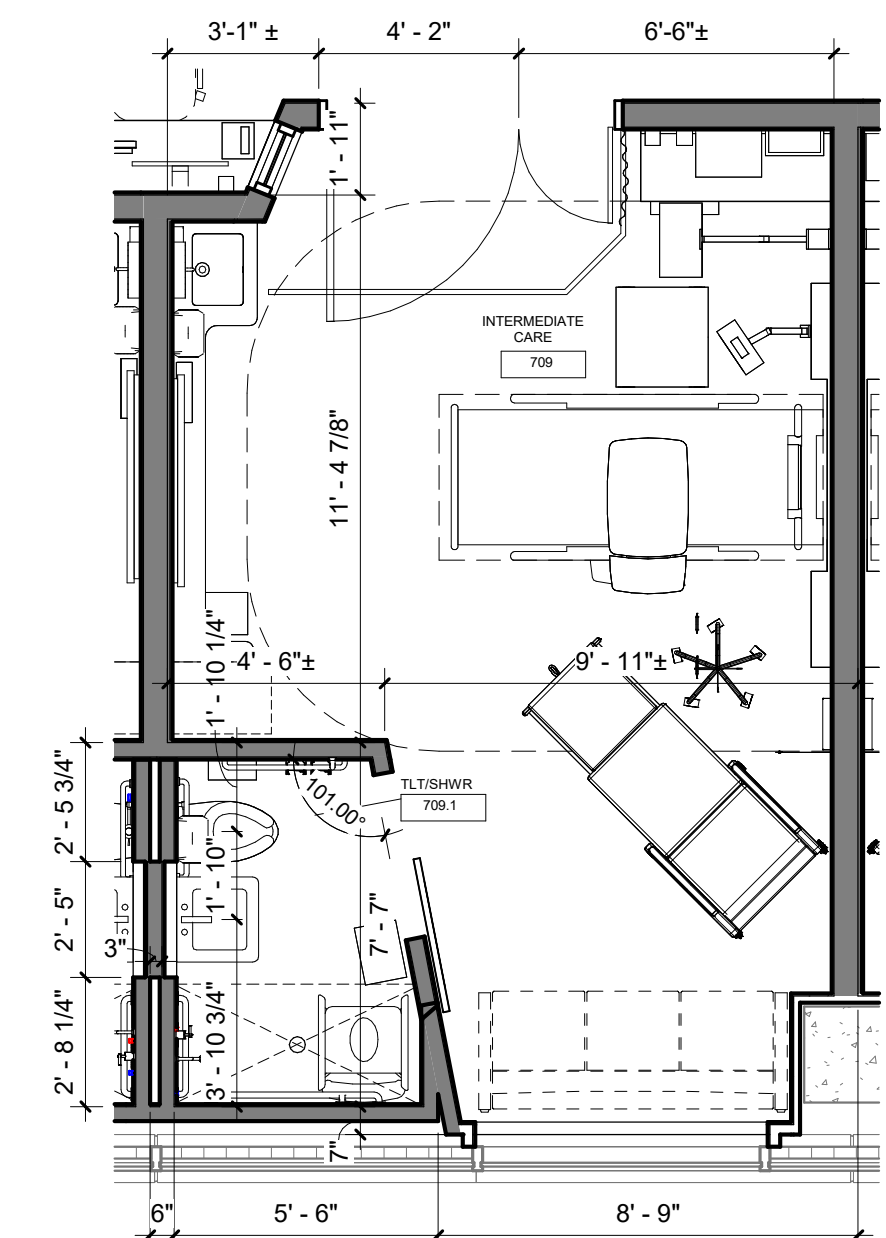

3 TYP. PCU ROOM
1/4" = 1'-0"

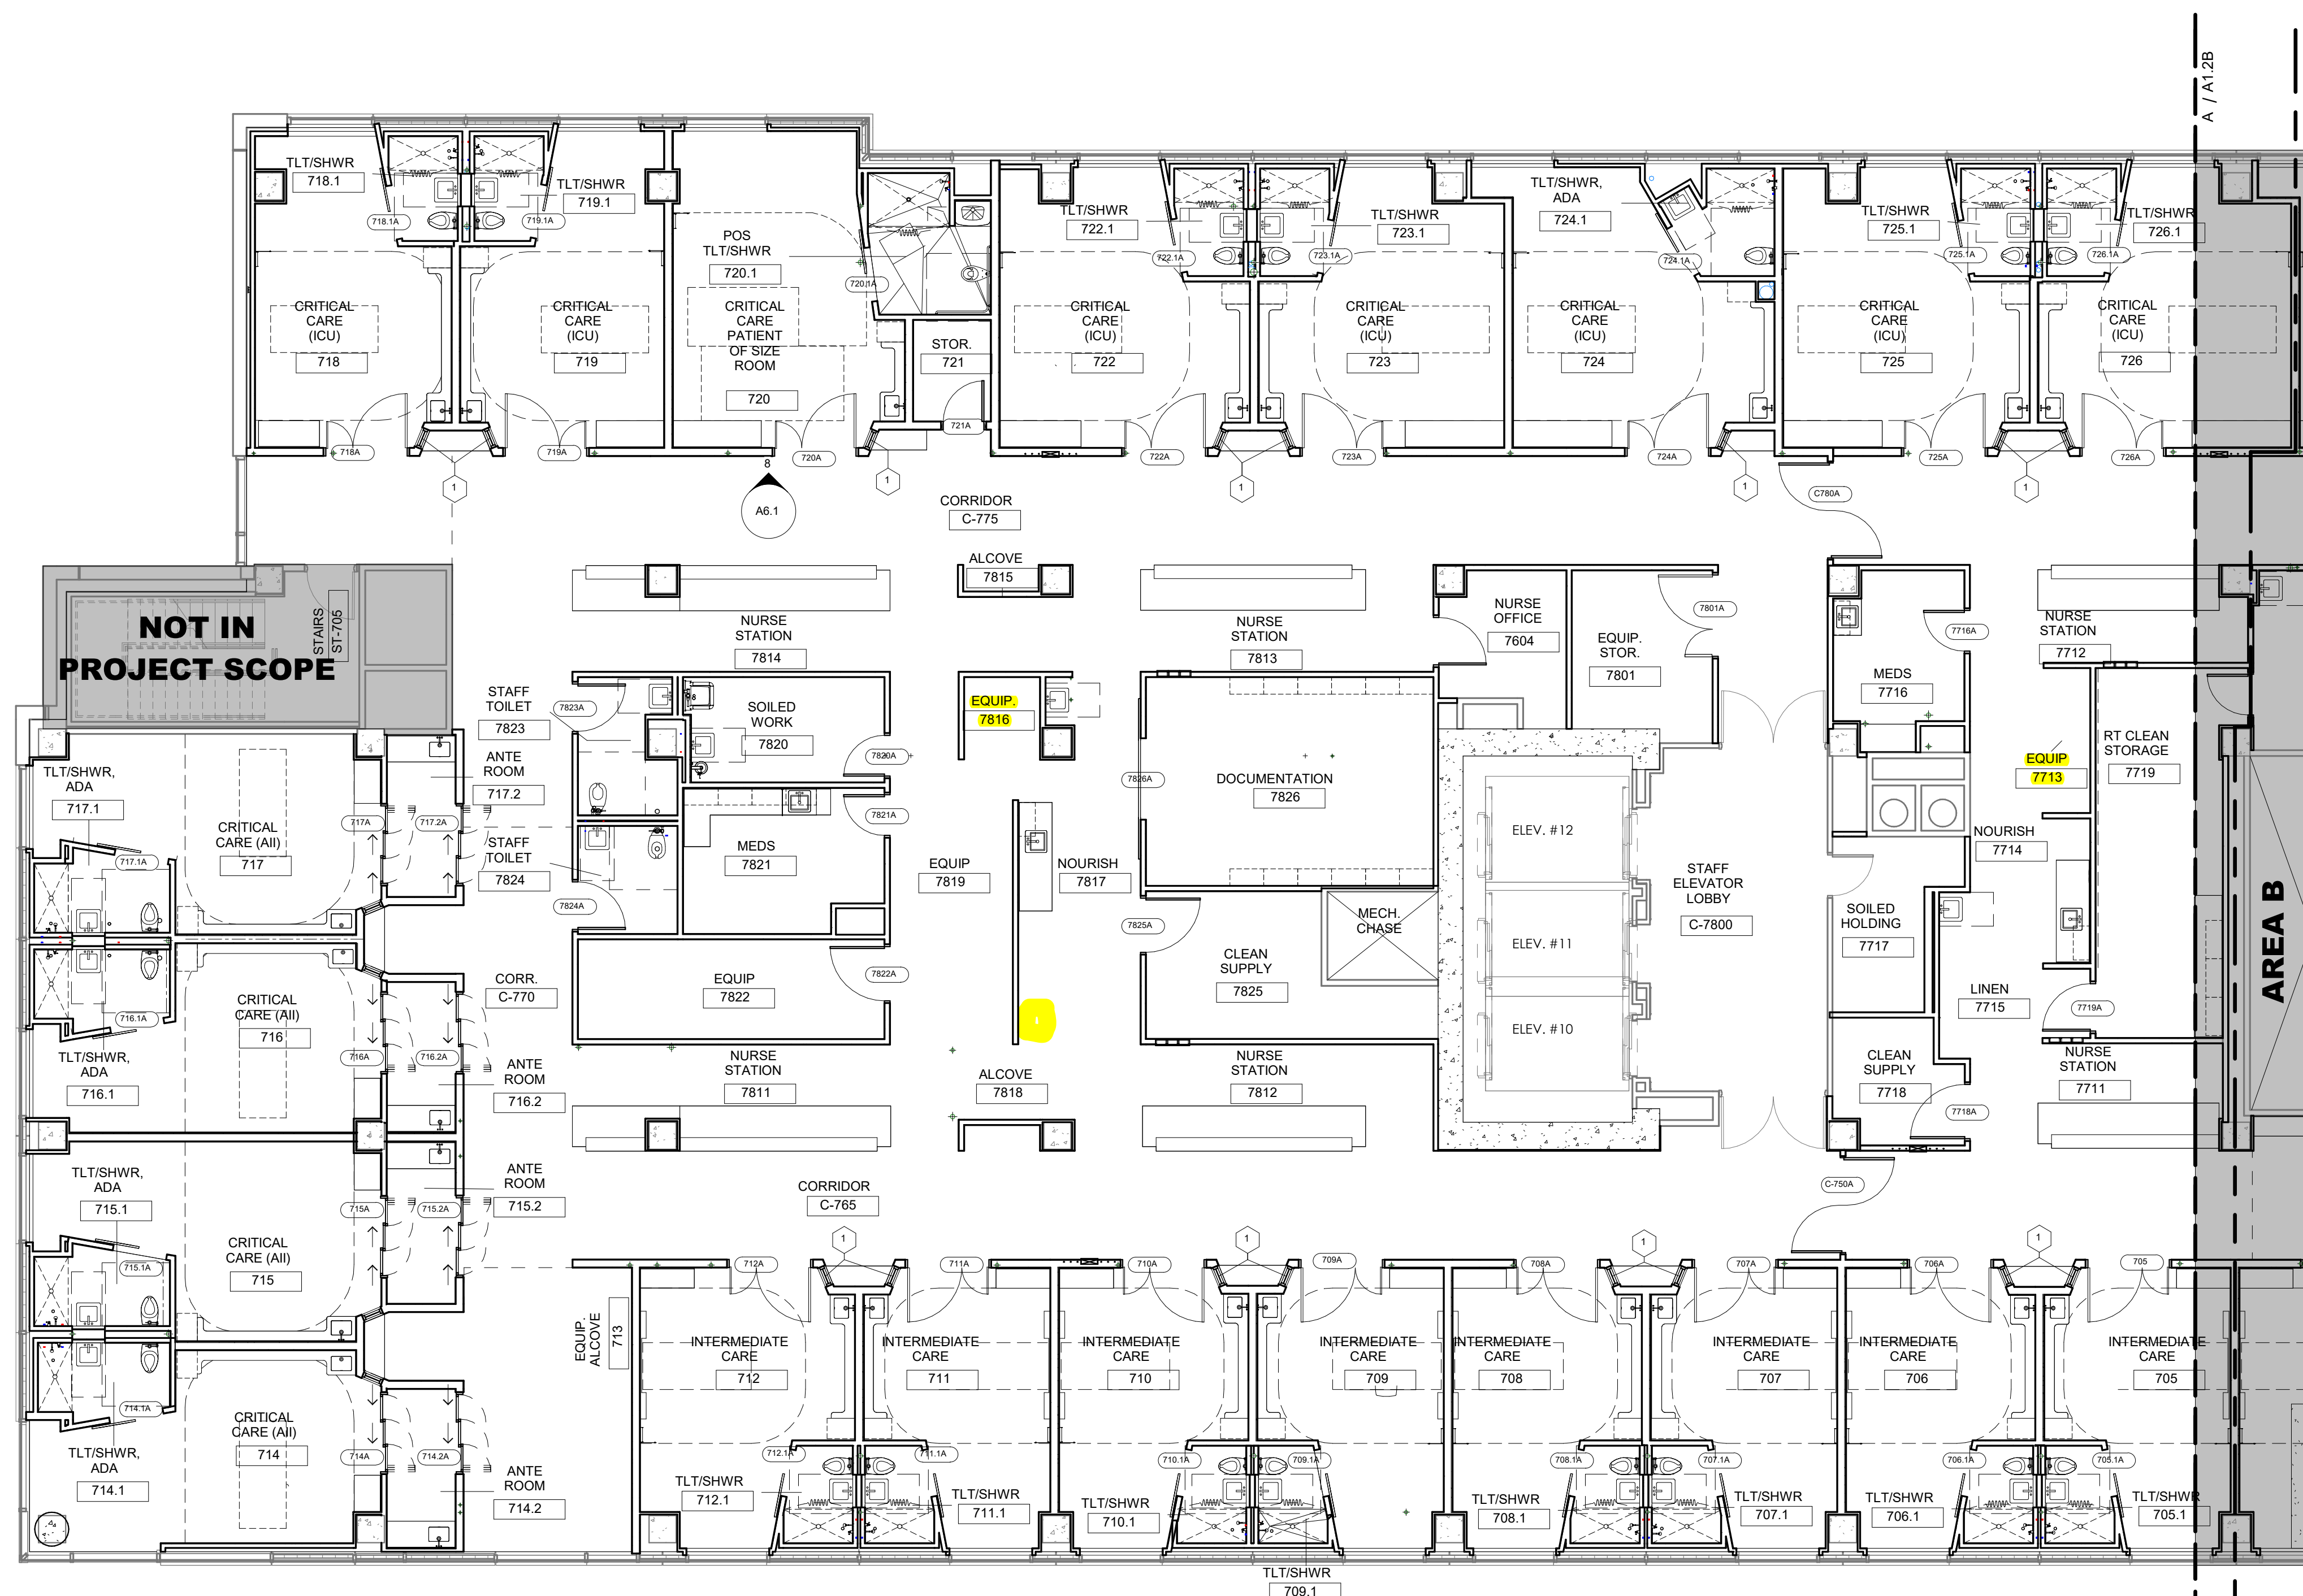

7TH FLOOR PLAN - AREA A
1/8" = 1'-0"

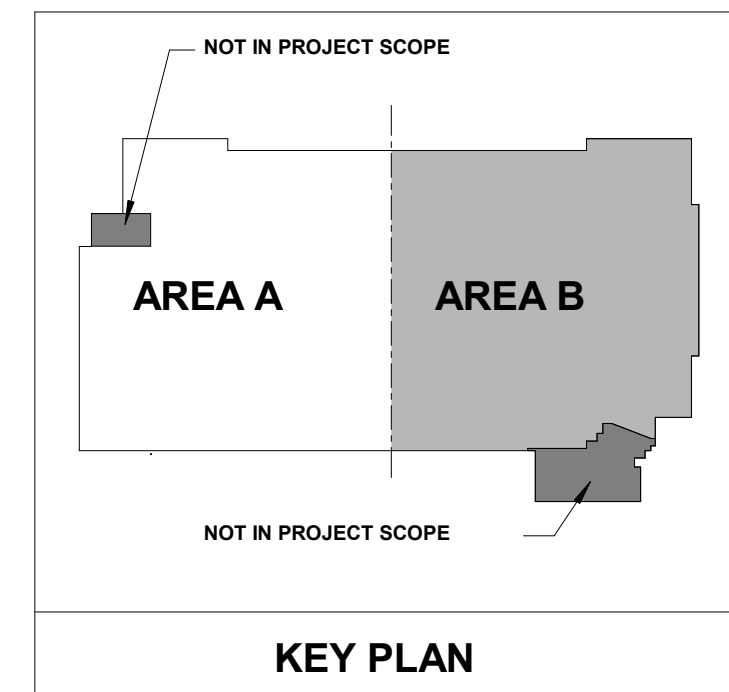

Architect's Log

No.	Date	Description

PROGRESS DRAWING
11/15/2024 10:55:21
PM
NOT FOR CONSTRUCTION

Project No.: 2040-821203
Date: 11/15/2024
Scale: As Indicated

MERCY NWA HOSPITAL
Building No.: 1388
ROGERS 7TH FLOOR ICU
2710 RIFE MEDICAL LANE, ROGERS, AR 72758



Floor No.: 7TH FLOOR
Sheet No.: **A1.2A**

