

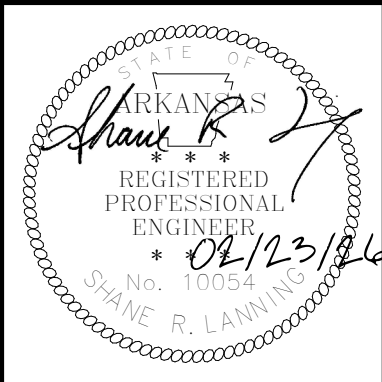


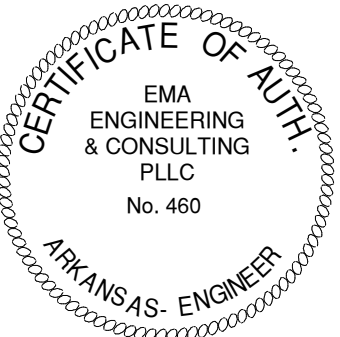

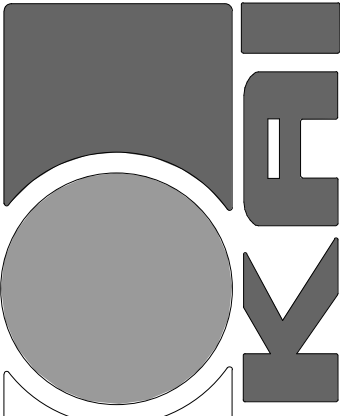

KEY ARCHITECTURE INC.

P.O. BOX 748 FAYETTEVILLE, ARKANSAS 72702
PH: 479.444.6066 FAX: 479.444.1445

PRELIMINARY
NOT FOR
CONSTRUCTION

Revision Schedule	
Rev. #	Description

NWA PEDIATRICS ADDITION
3730 S PINNACLE HILLS PKWY #3
ROGERS, AR 72758

MANA
3383 N MANA CT, SUITE 201
FAYETTEVILLE, AR 72703



DATE	DRAWN BY
Issue Date	Designer
PROJECT #	CHECKED BY
2438	Checker

SHEET


P1.2

PLUMBING DRAIN ROOF PLAN

These Drawings and Specifications are the exclusive property of Key Architecture Inc. and are protected by Copyright. Use or reproduction is prohibited without written consent.

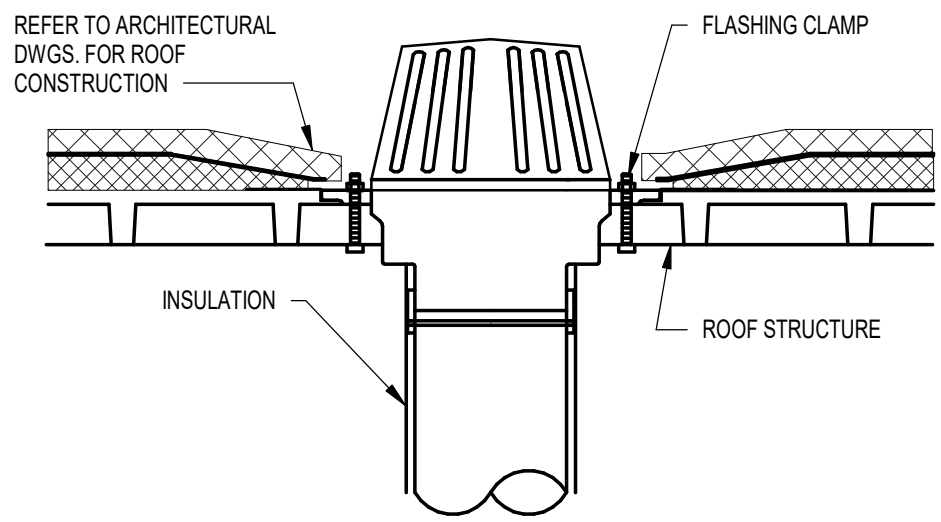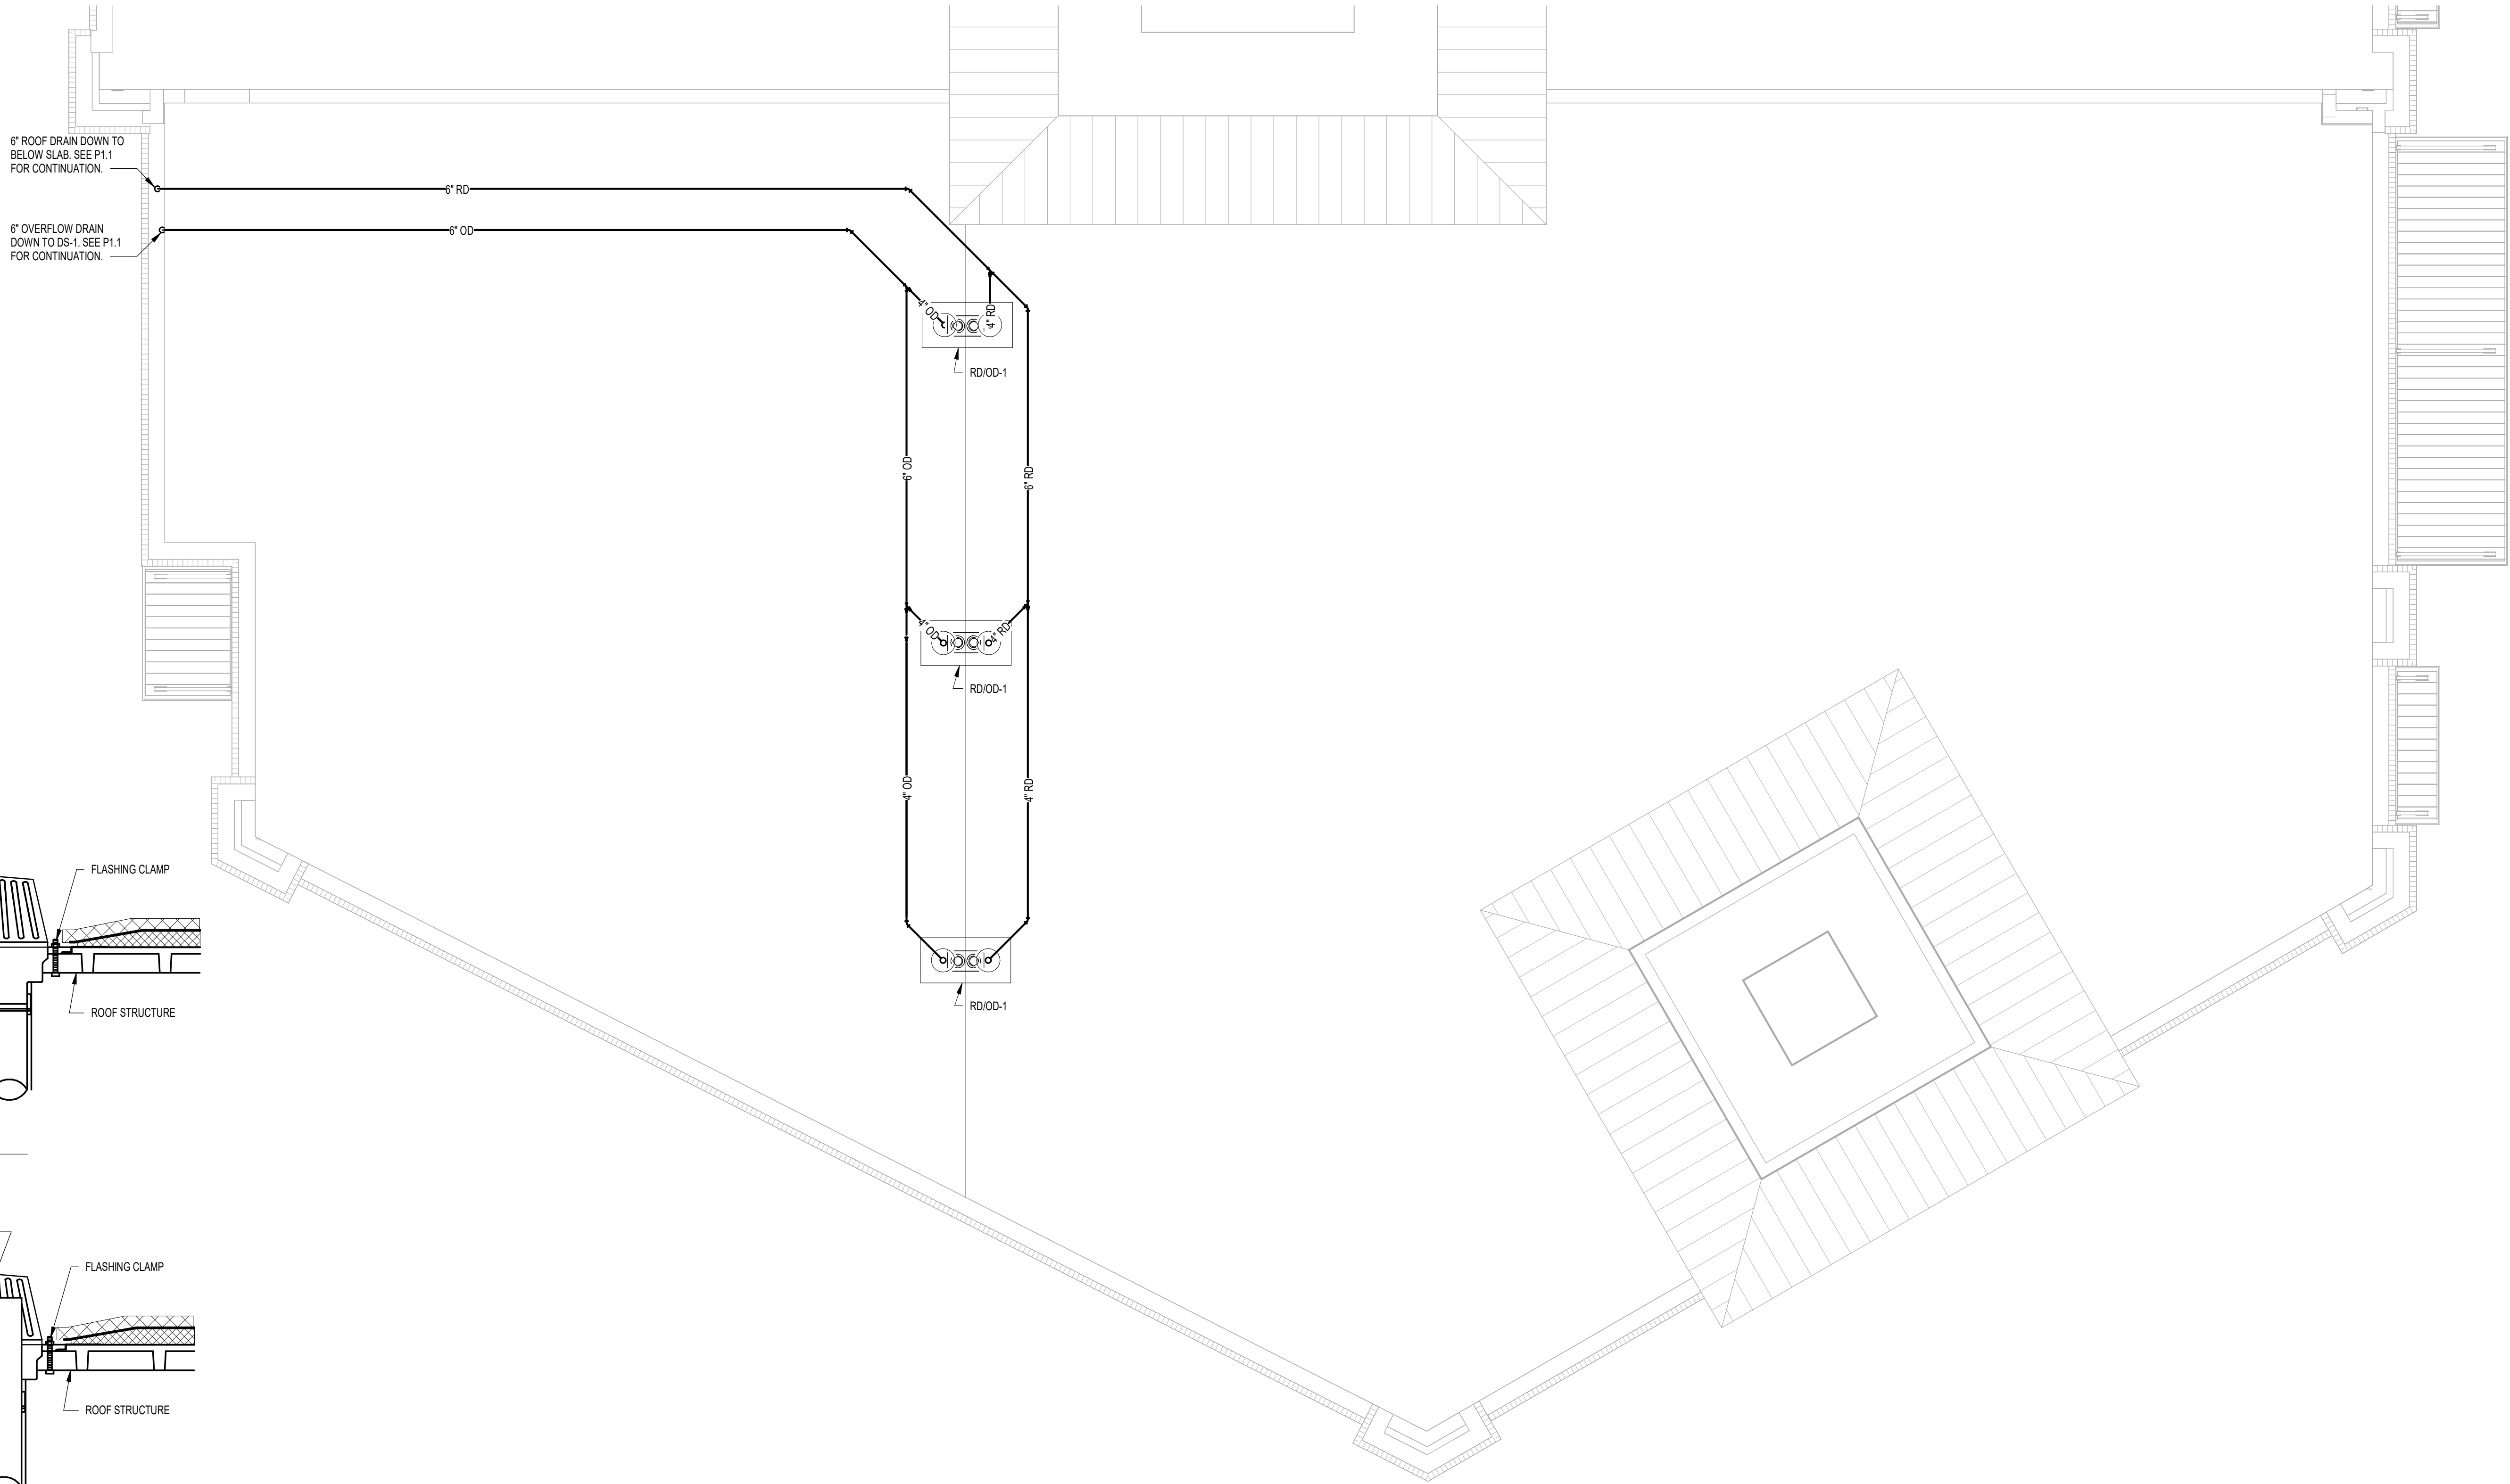

3 ROOF DRAIN
SCALE: N.T.S.

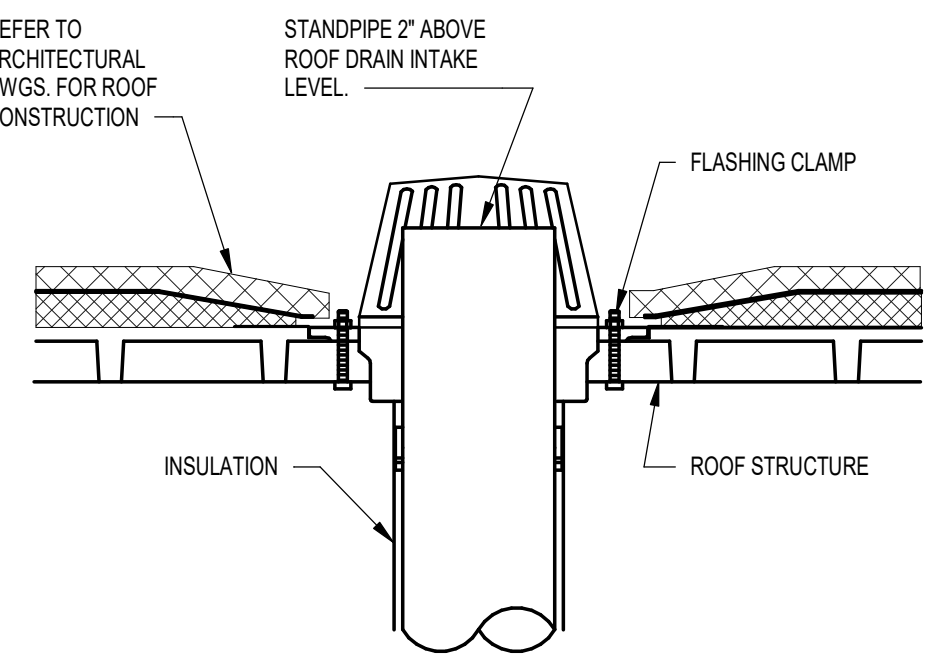

2 OVERFLOW DRAIN
SCALE: N.T.S.

1 PLUMBING DRAIN ROOF PLAN
SCALE: 1/4" = 1'-0"