



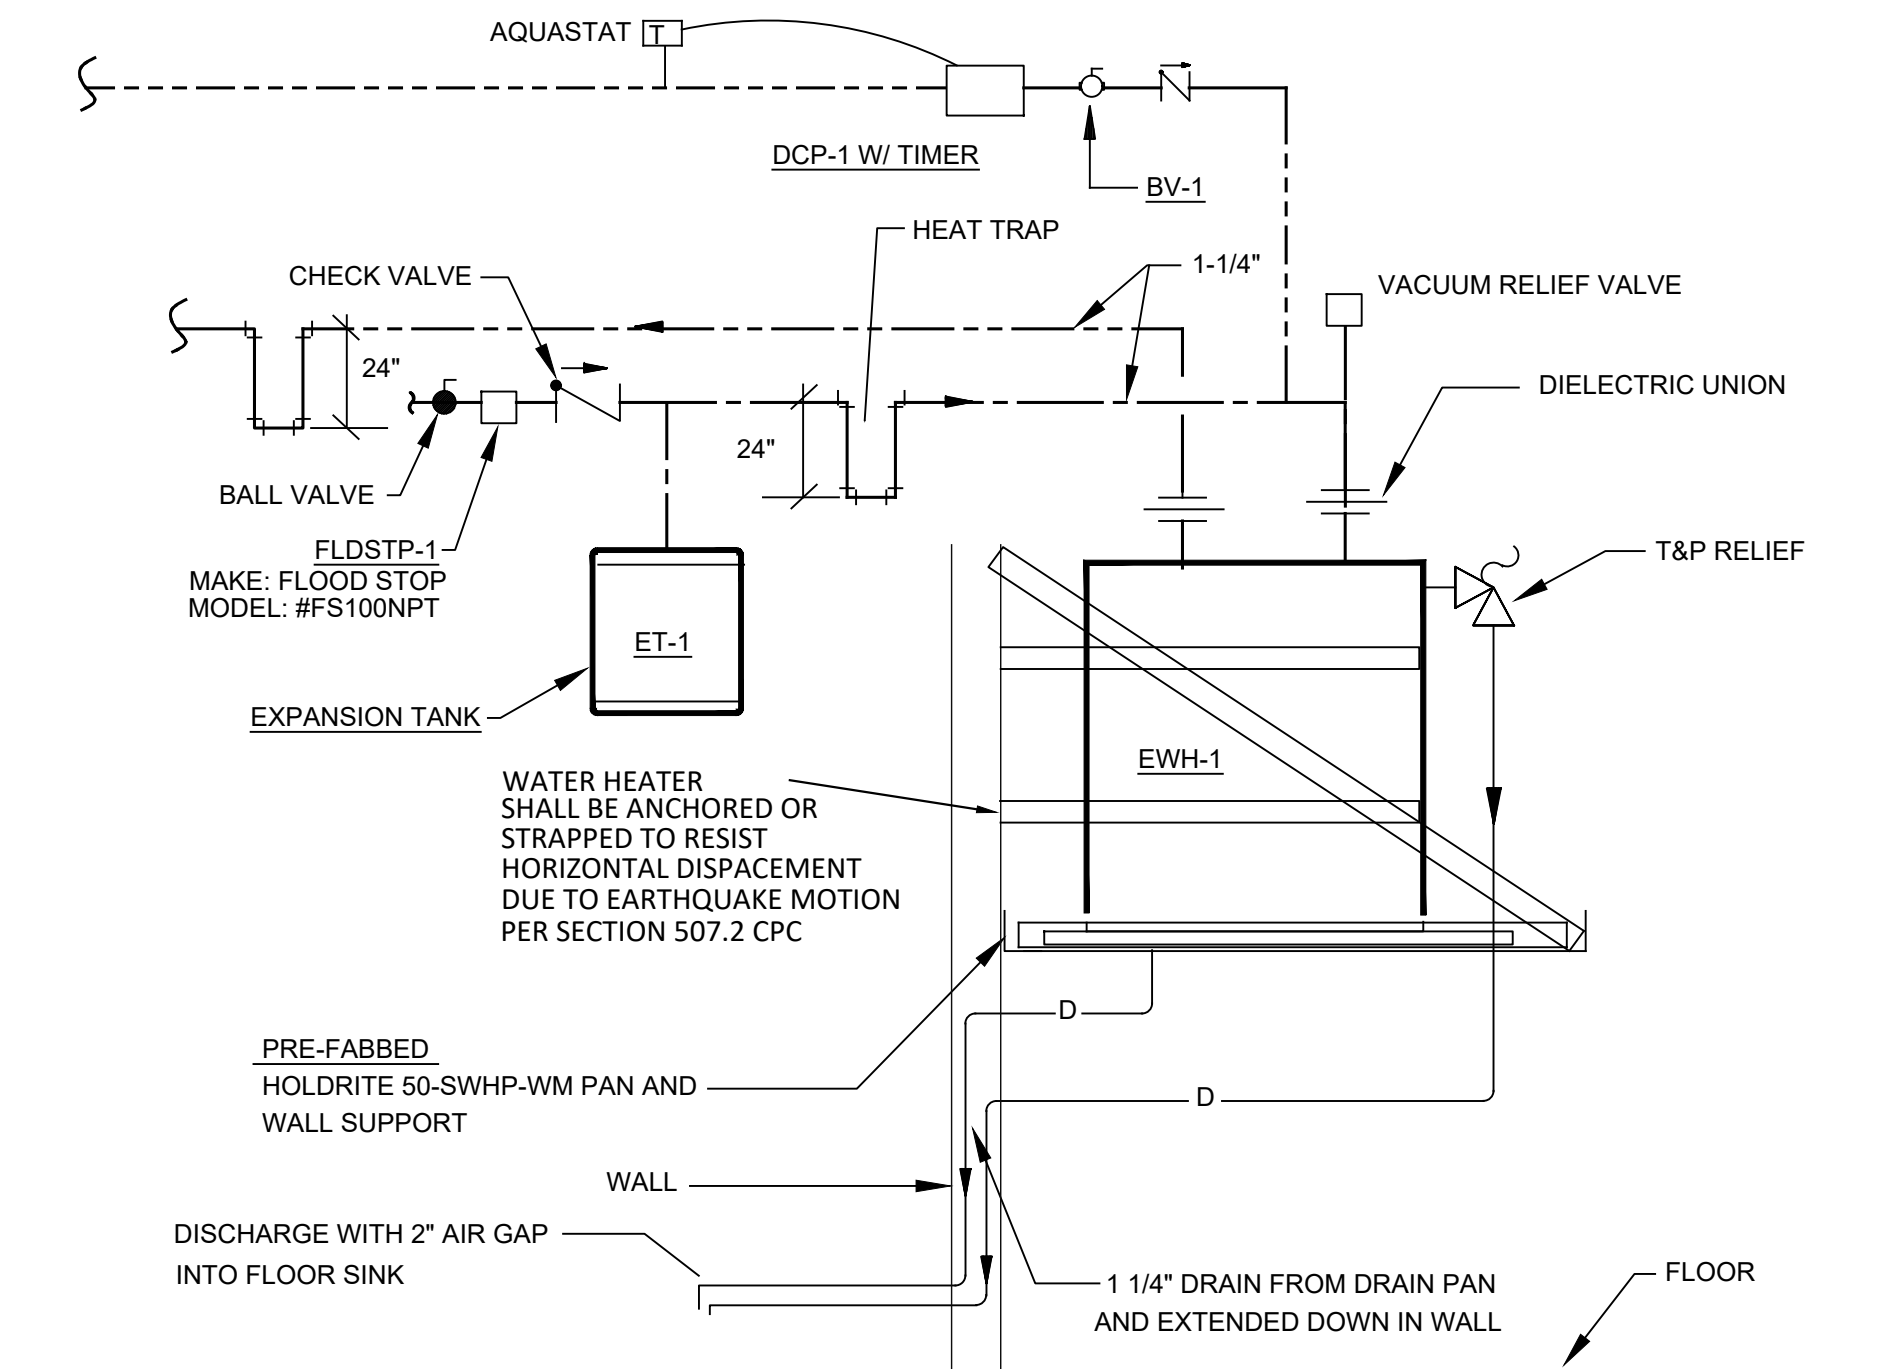


RECIRCULATION SYSTEM SEQUENCE OF OPERATION TO COMPLY WITH IECC C404.6.1
1. AQUASTAT SHALL TURN PUMP OFF AT 120 DEG F.
2. TIMECLOCK TURNS THE PUMP OFF DURING UNOCCUPIED HOURS.


5 **ELECTRIC WATER HEATER DETAIL**
NO SCALE

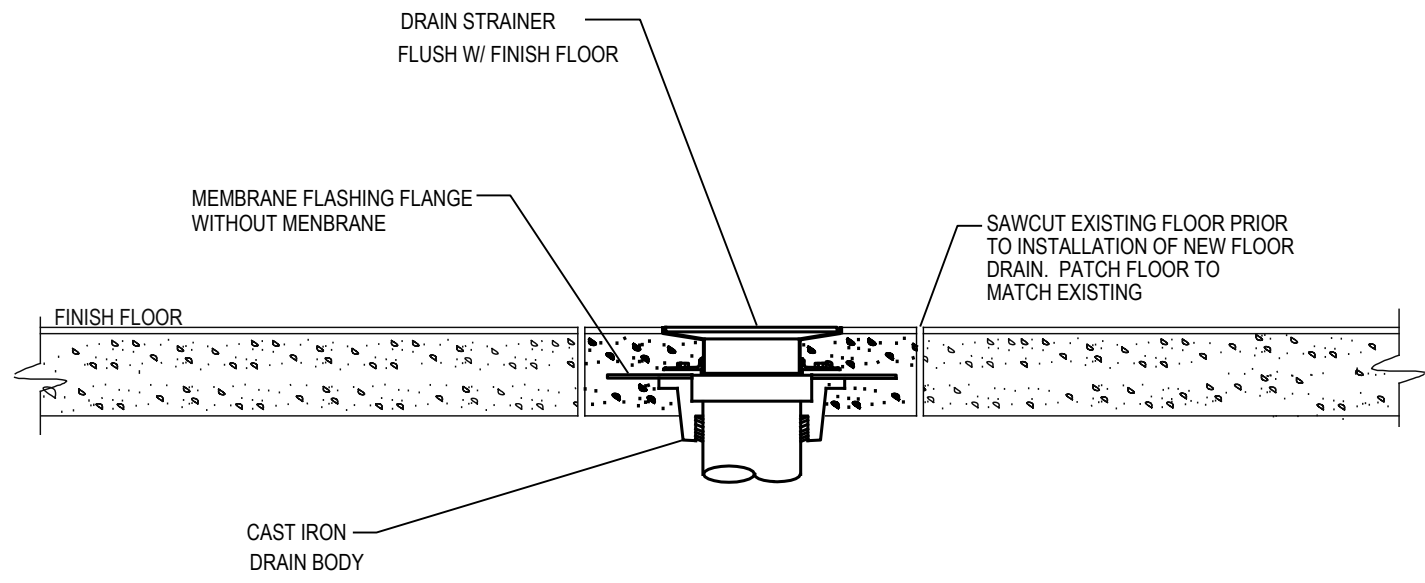

2 **FLOOR SINK FLASHING DETAIL**
NO SCALE

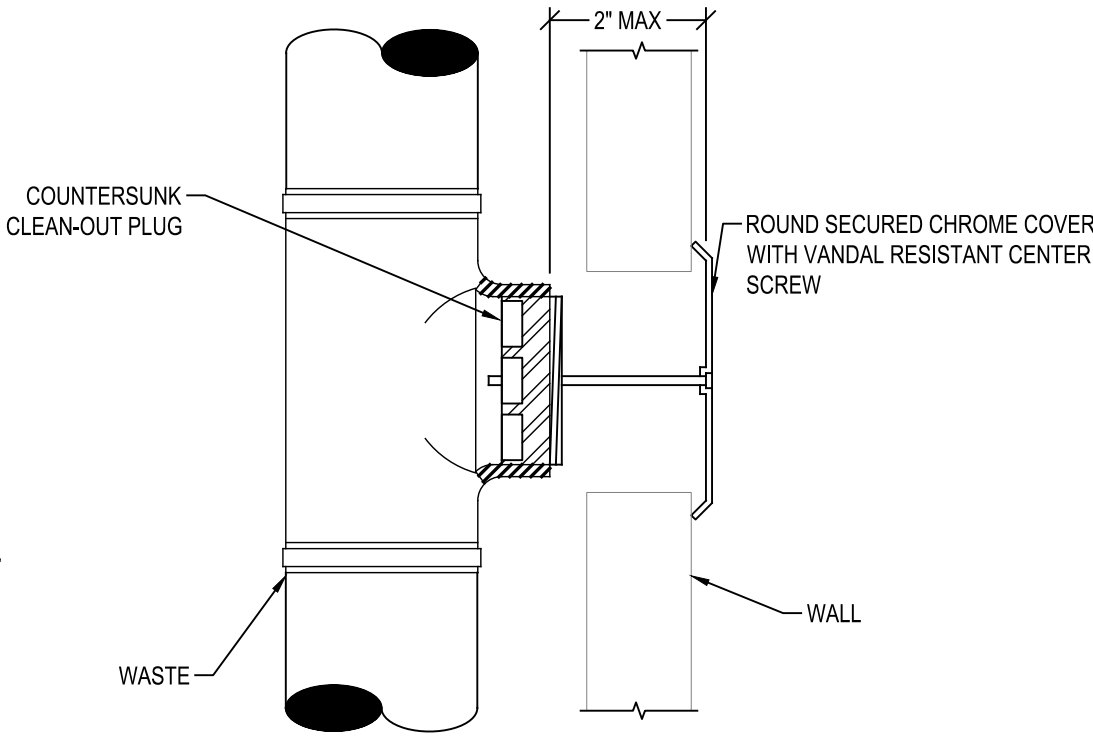


1 **WALL CEANOUT DETAIL**
NO SCALE

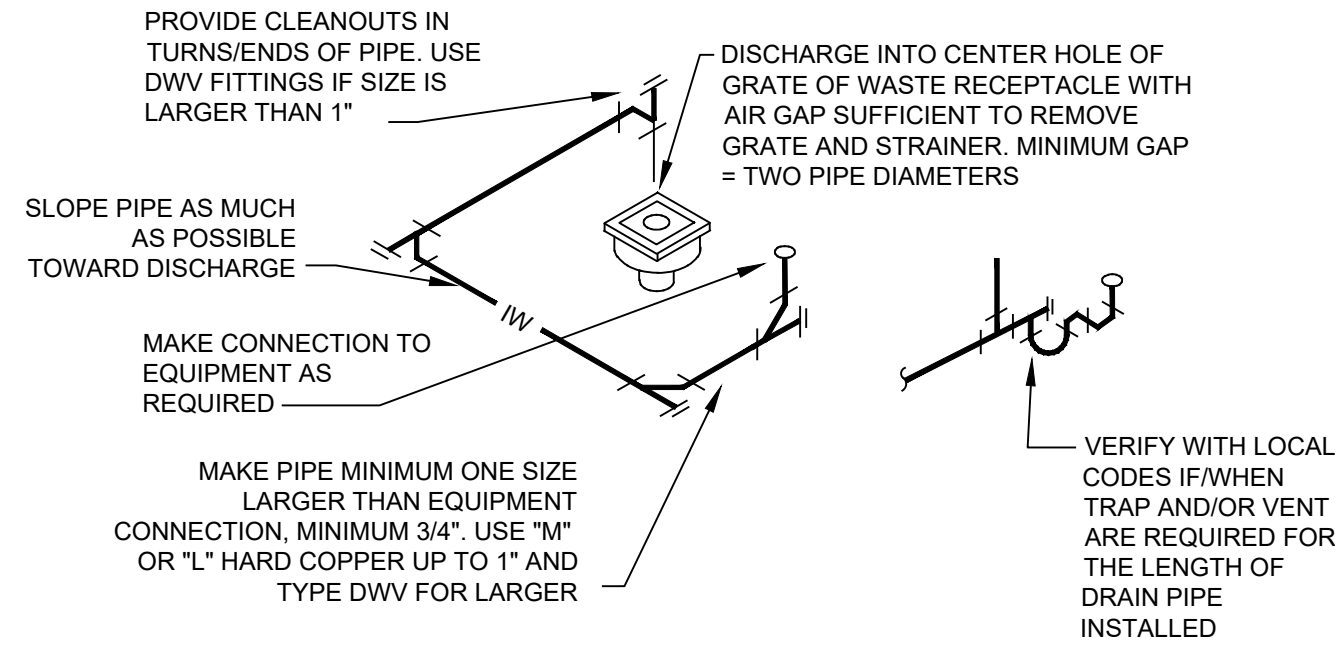

ROUTE PIPE INCONSPICUOUSLY AND UNOBTUSIVELY. HANG PIPE AS REQUIRED. DO NOT INSULATE INDIRECT DRAIN PIPE WHEN INSTALLED EXPOSED IN FOOD SERVICE FACILITY. REFER TO LOCAL CODES FOR FURTHER INFORMATION.

3 **INDIRECT DRAIN DETAIL**
NO SCALE

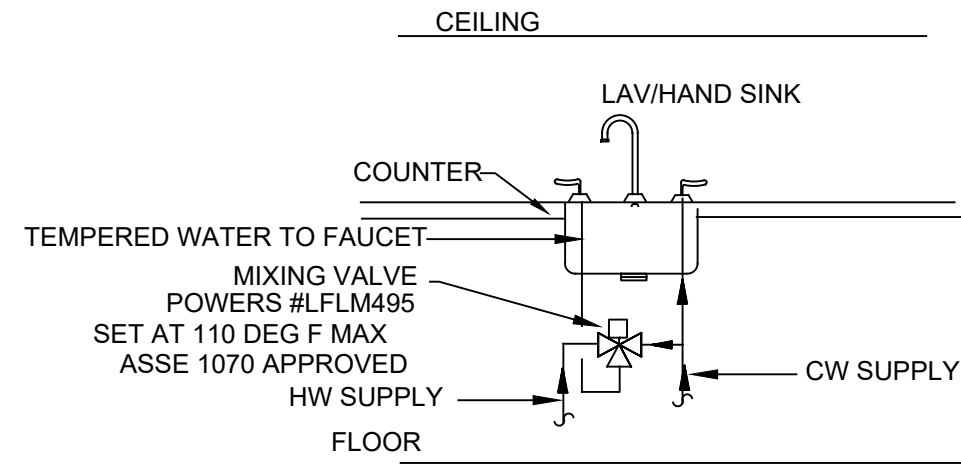

4 **MIXING VALVE DETAIL**
NO SCALE

JOE
ARCHITECT

DYNAMIC MEP
CONSULTING ENGINEERS
303.421.3208 | info@dmce.com

Oz Orthodontics
3334 N Main Ct, 3rd Floor, Fayetteville, AR 72703

STATE OF
ARKANSAS
JOSHUA L. COOK
LICENSED
PROFESSIONAL
ENGINEER
No. 24910
09/18/26

REVISIONS		
#	Date	Description

DATE: 18 Aug 2026
PROJECT NO: 26085
DRAWN BY: SJP/JC
ISSUED FOR: Permit Set

Plumbing Details

P1.1