




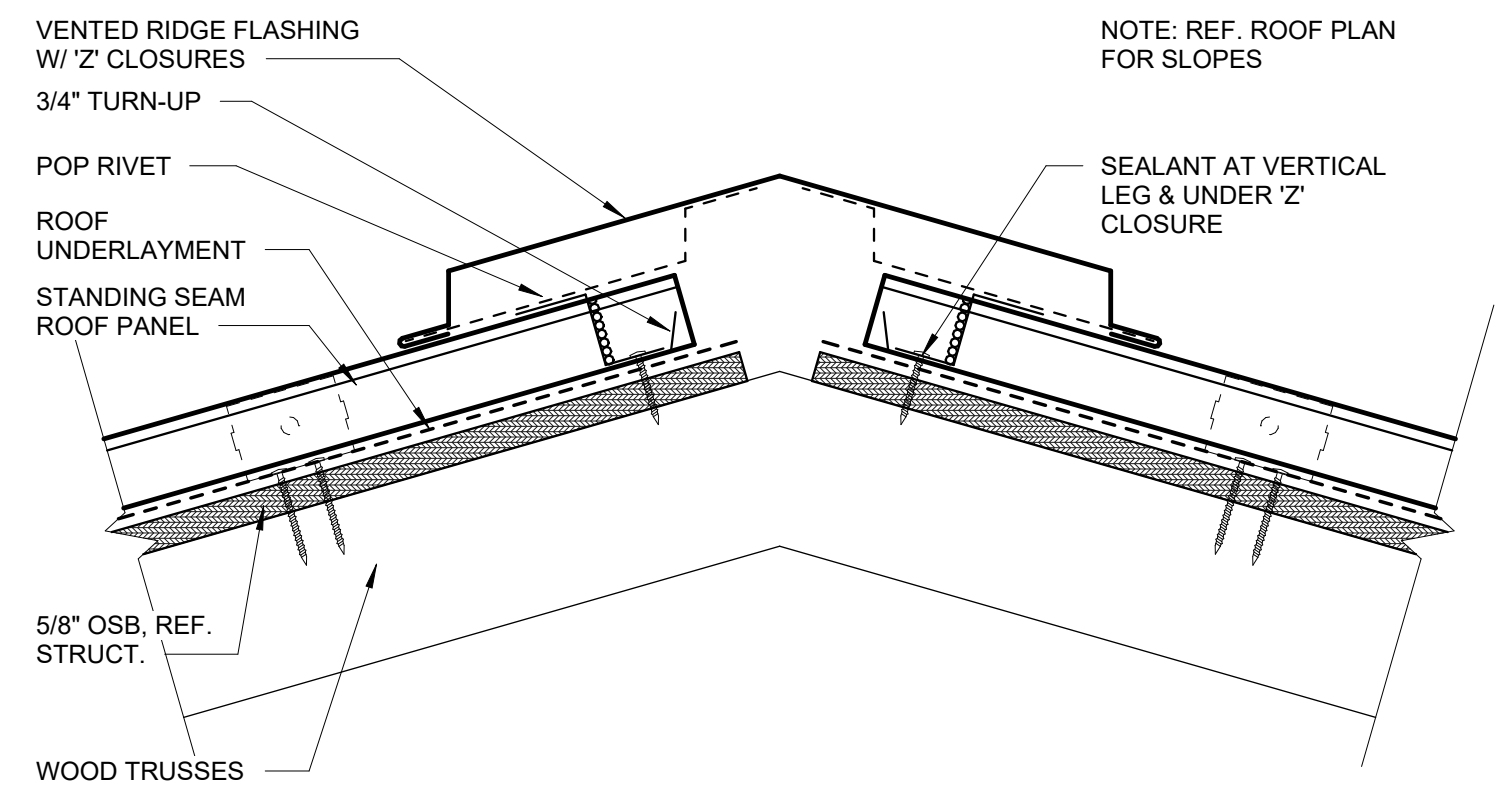


6 ROOF DETAIL - RIDGE VENT
3" = 1'-0"

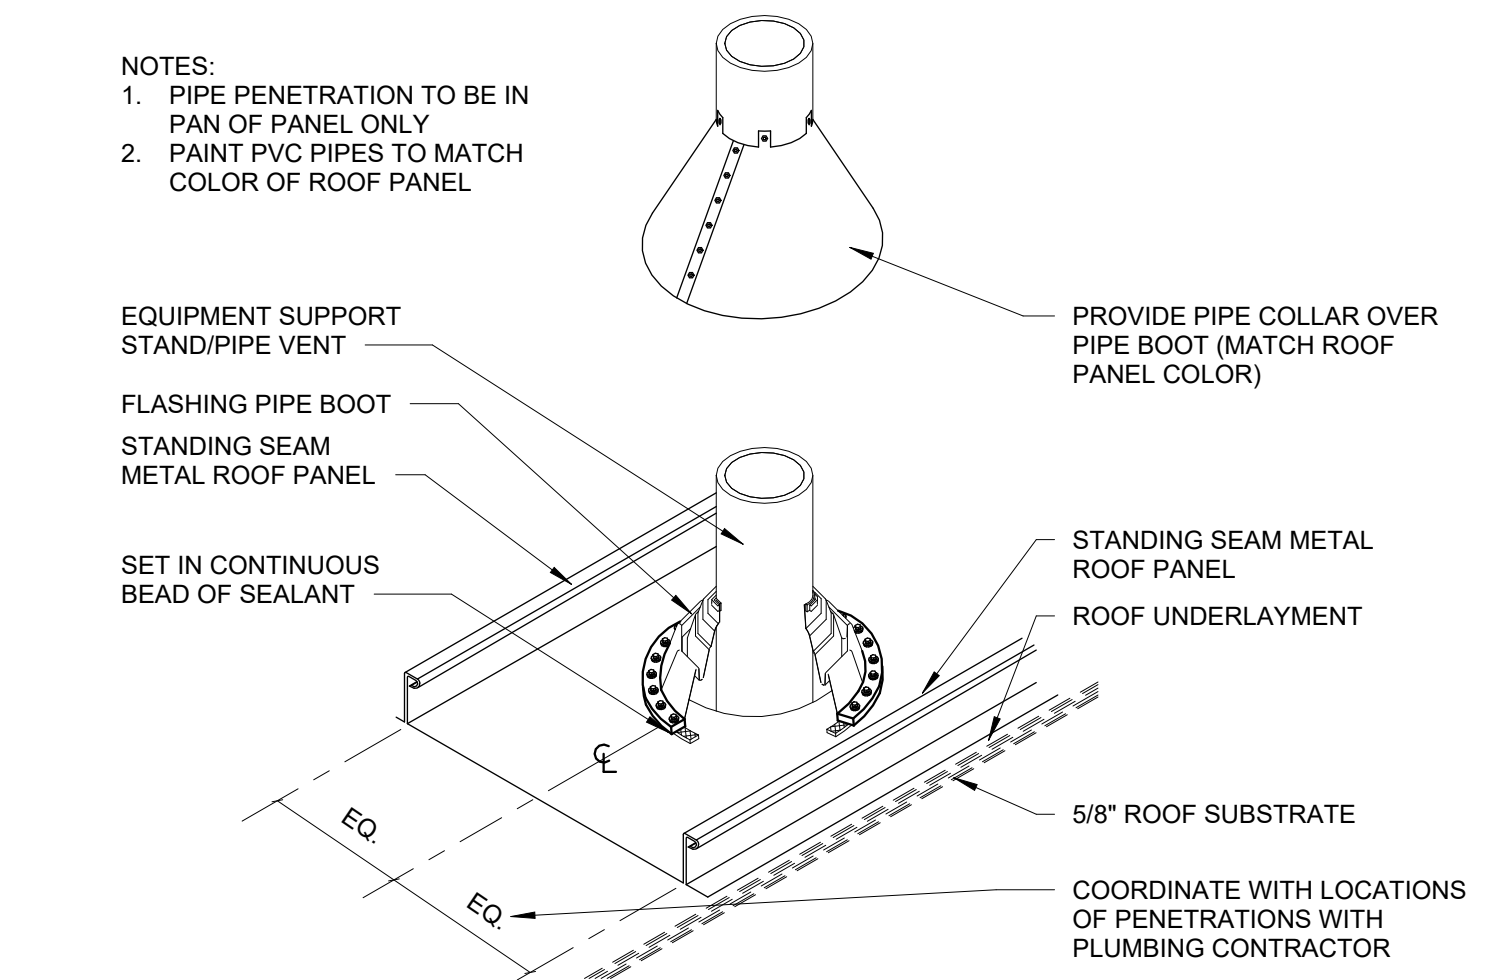

5 ROOF DETAIL - PIPE PENETRATION
1 1/2" = 1'-0"

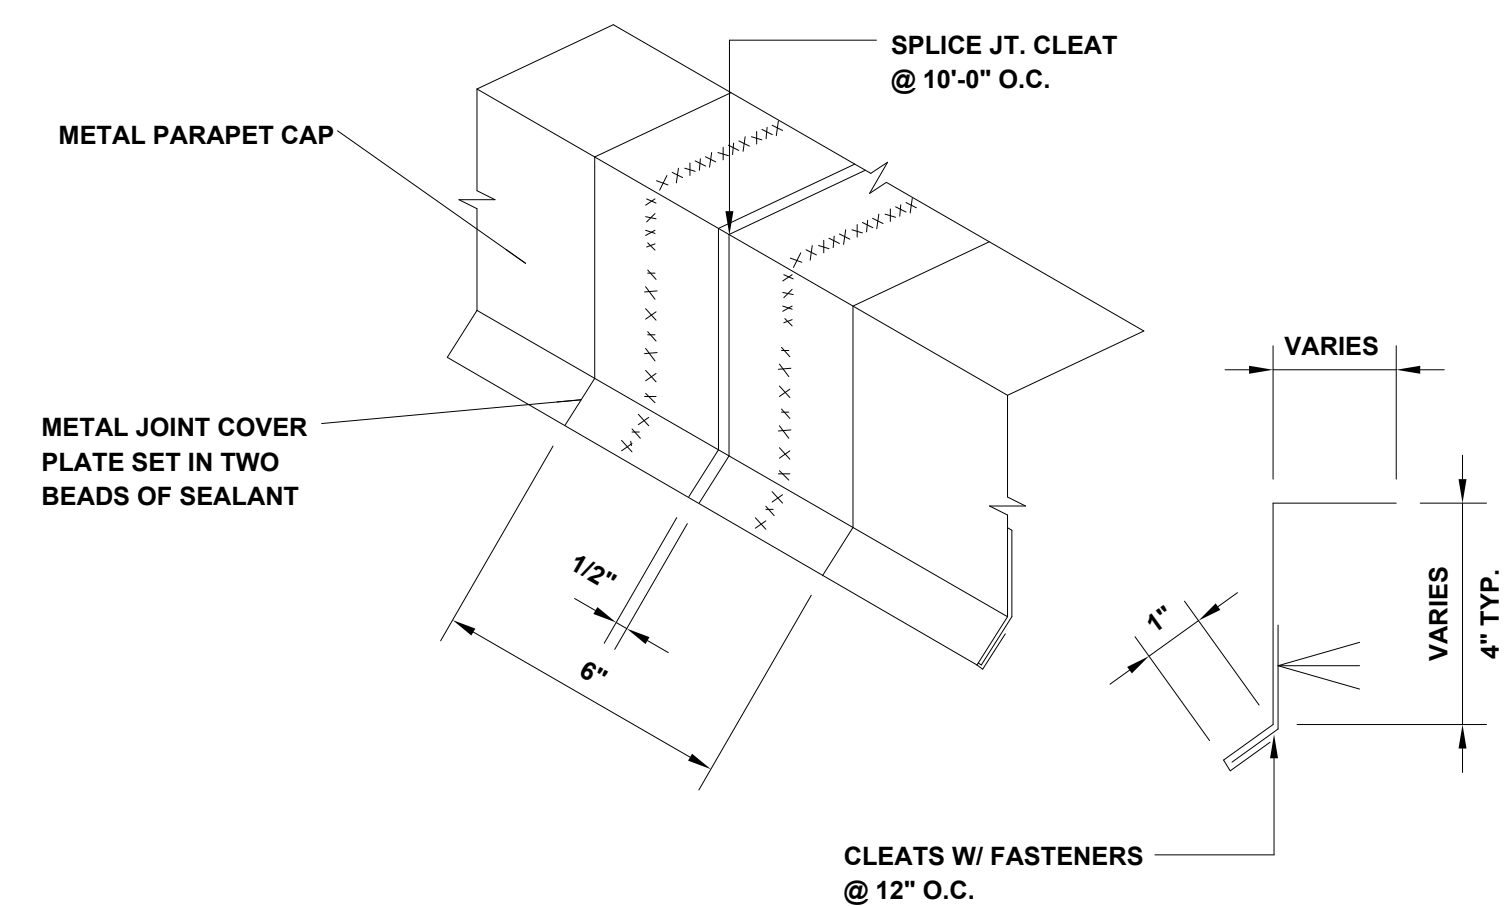


4 ROOF - TYPICAL CAP / COUNTER FLASHING
N.T.S.

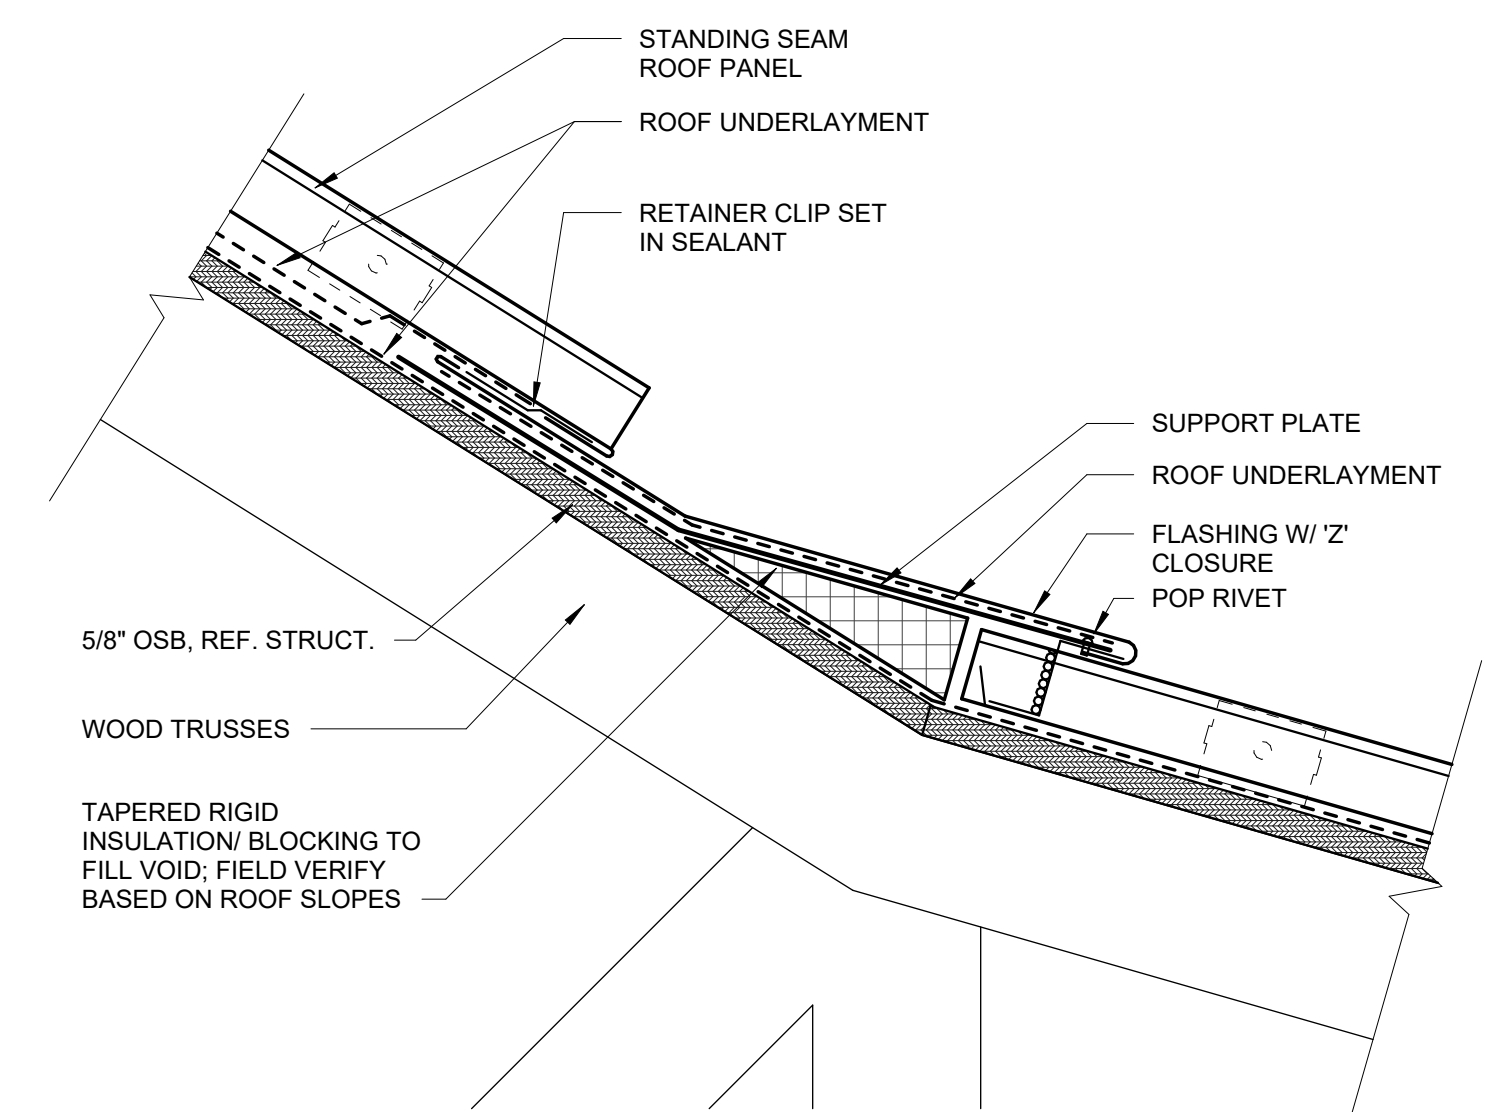

3 ROOF DETAIL - SLOPE TRANSITION
3" = 1'-0"

2 ROOF PLAN
1/8" = 1'-0"

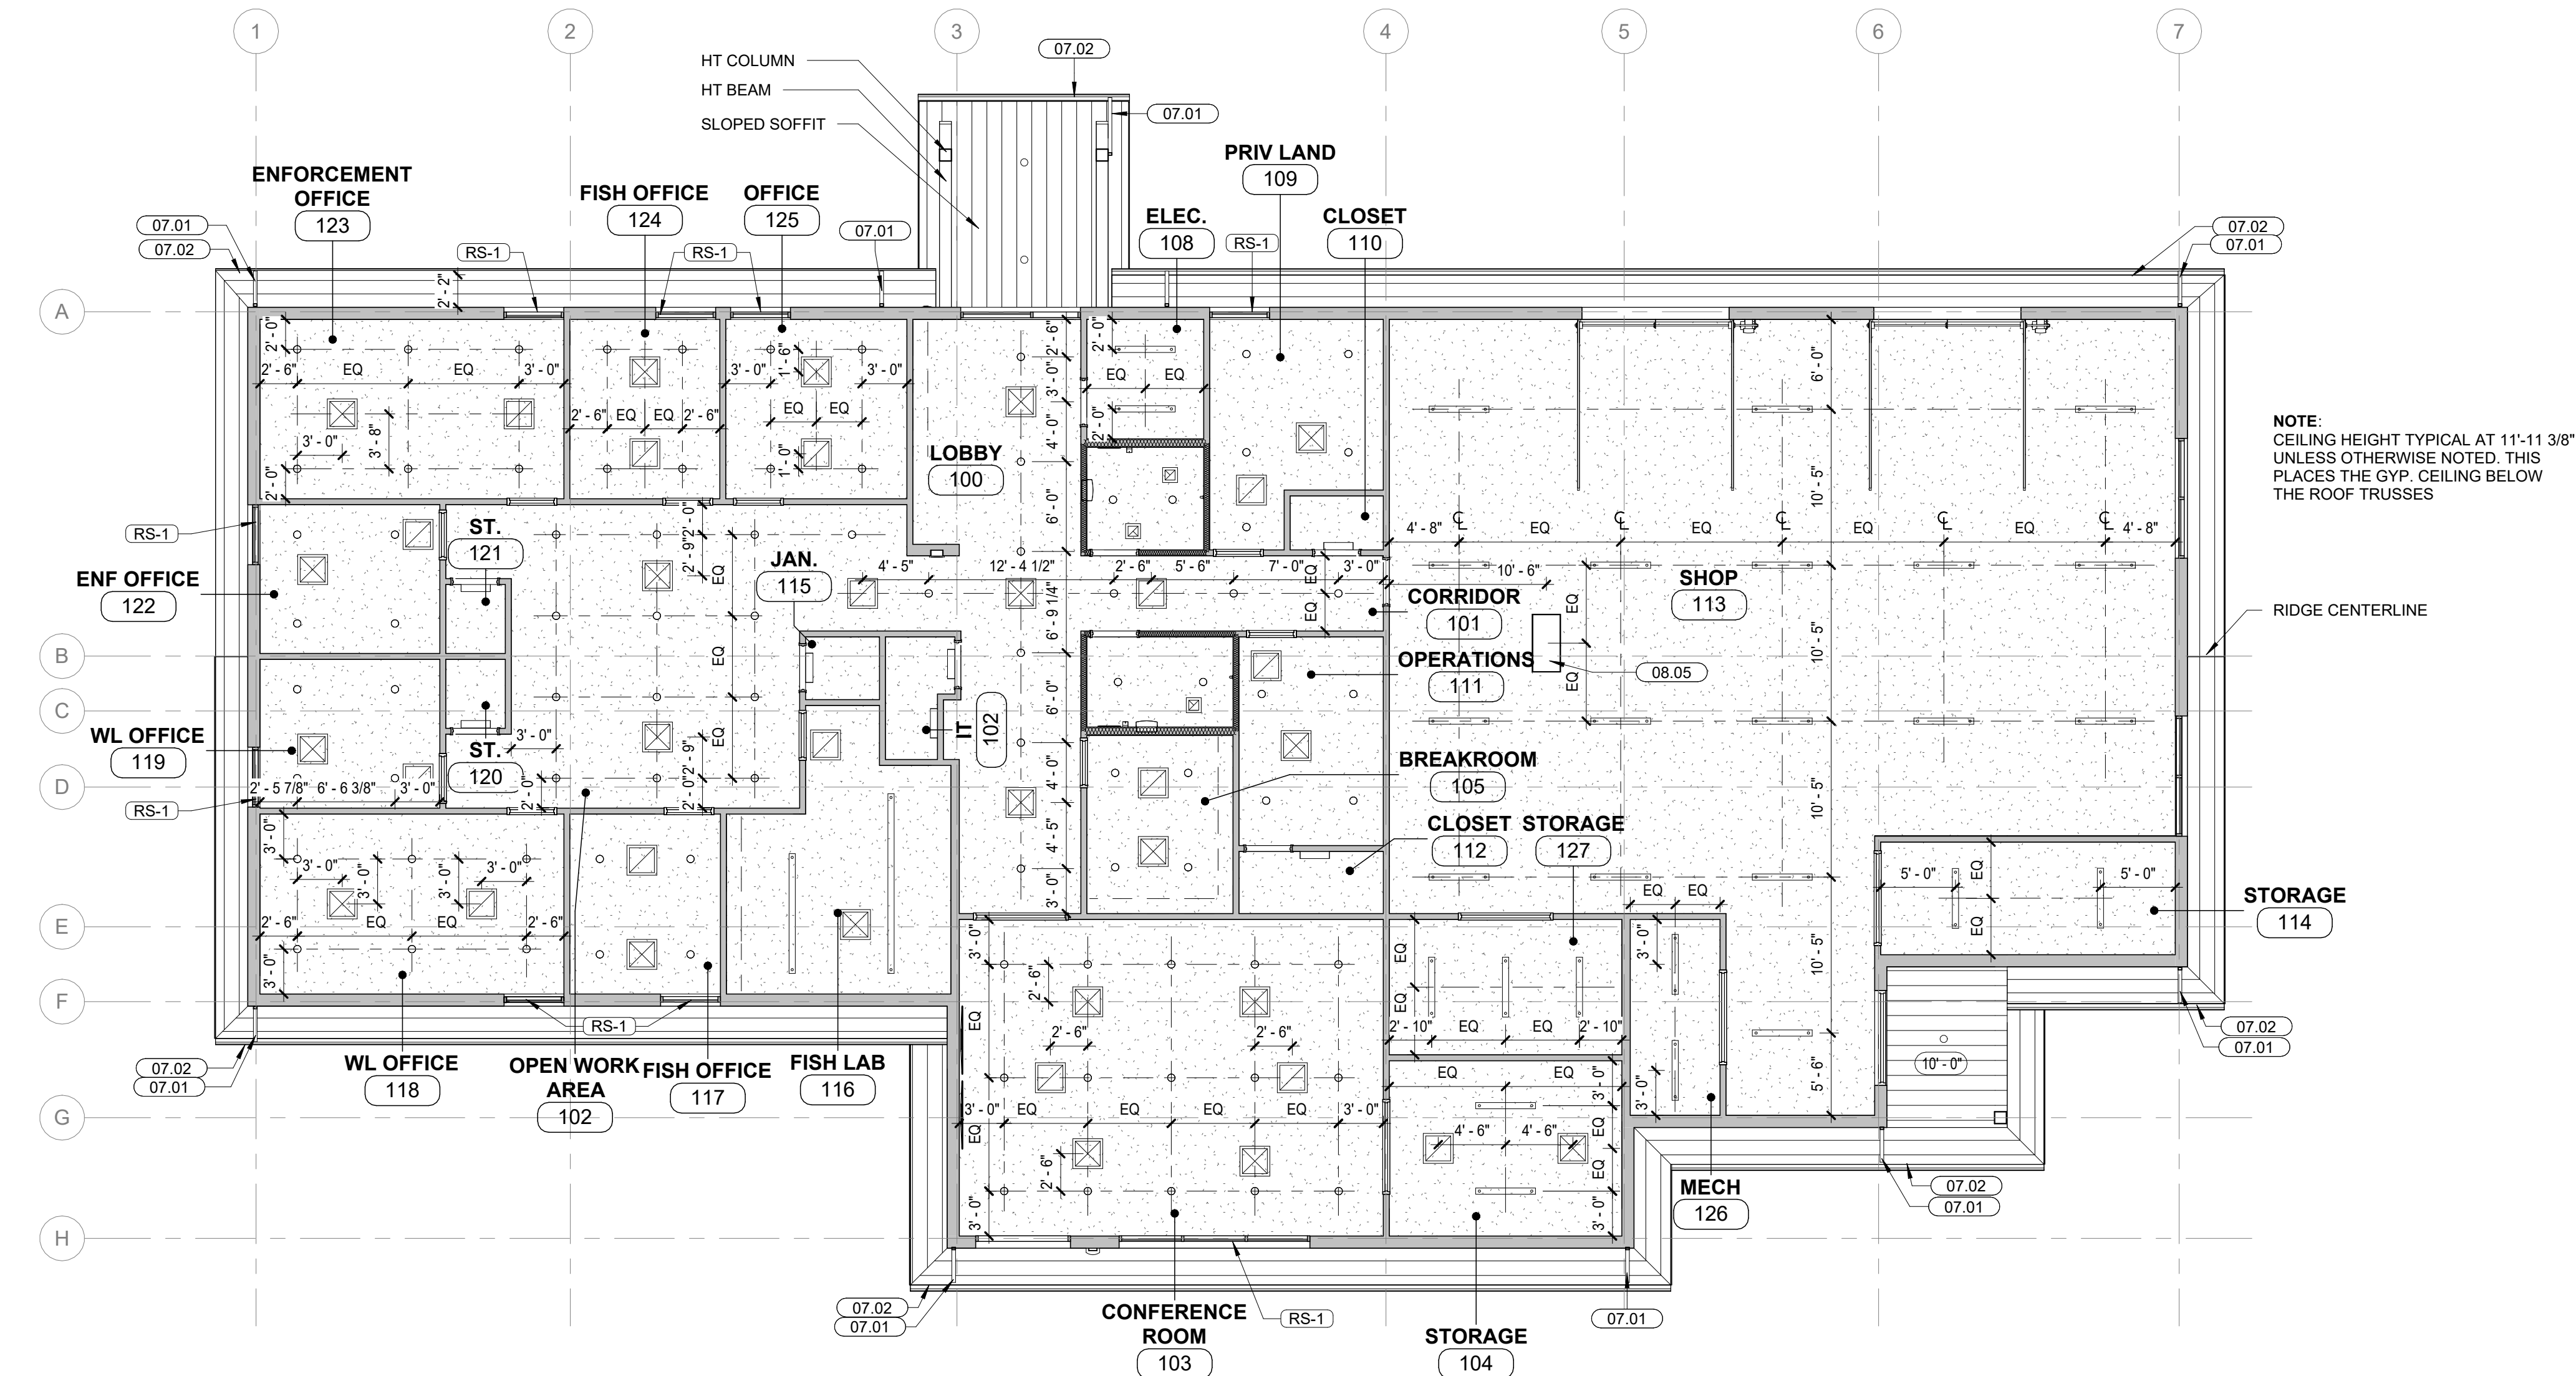

1 REFLECTED CEILING PLAN
1/8" = 1'-0"

KEYNOTE LEGEND	
07.01	PREFINISHED DOWNSPOUT, MIN 2"x3"
07.02	PREFINISHED GUTTER - MIN 6"
07.03	STANDING SEAM MTL ROOF SYSTEM INSTRUCTIONS
07.08	SNOW GUARD, INSTALL PER MFR INSTRUCTIONS
07.09	PREFINISHED RIDGE CAP
08.05	ATTIC ACCESS

REFLECTED CEILING LEGEND	
	GYPSUM BOARD CEILING
	2' X 2' ACT CEILING
	EXPOSED TO STRUCTURE
	4' X 4' LIGHT FIXTURE
	RECESSED CAN LIGHT
	HVAC RETURN REGISTER
	HVAC SUPPLY REGISTER
	HVAC EXHAUST REGISTER
	EXIT SIGN

NOTE: REF ELECTRICAL DRAWINGS FOR ADDITIONAL POWER AND LIGHTING DEVICES.

- RCP SHEET NOTES
- REFERENCE MECHANICAL AND ELECTRICAL DRAWINGS FOR MOUNTING LOCATIONS OF ITEMS WHERE NO CEILING IS REQUIRED OR INDICATED.
 - CEILING GRID SHALL BE SUPPORTED FROM STRUCTURAL MEMBERS ONLY. GRID SHALL NOT BE SUPPORTED FROM OTHER TRADES WORK.
 - ALL FINISH CALLOUTS AT GYP CEILINGS ARE FOR UNDERSIDES OF CEILINGS, SOFFITS, AND HEADERS UNLESS NOTED OTHERWISE ON REFLECTED CEILING PLAN REF FINISH FLOOR PLAN FOR ALL WALL/VERTICAL SURFACE FINISHES.
 - REF ELEC FOR EMERGENCY LIGHTING LOCATIONS.
 - LIGHTS, DIFFUSERS, EXIT SIGNS, SMOKE DETECTORS, SPEAKERS, STROBES AND MISCELLANEOUS DEVICES SHALL BE CENTERED IN THE CEILING TILE IN WHICH THEY OCCUR, UNLESS NOTED OTHERWISE.
 - SPRINKLER HEADS ARE NOT SHOWN ON ARCHITECTURAL REFLECTED CEILING PLANS. CONTRACTOR TO INSTALL SUFFICIENT HEADS IN ALL SPACES TO PROVIDE 100% COVERAGE AS REQUIRED UNDER NFPA 13 AND OWNERS' INSURANCE COMPANIES' REQUIREMENTS. CENTER ALL SPRINKLER HEADS IN CEILING TILES AND GYPSUM BOARD CEILINGS.
 - ALL CORRIDOR SPRINKLER HEADS SHALL BE ALIGNED IN THE SAME LOCATION PARALLEL TO THE WALL WITHIN EACH SPECIFIC CEILING CONSTRUCTION. ARCHITECTURALLY SIGNIFICANT SPRINKLER HEAD LOCATIONS MAY BE SHOWN ON REFLECTED CEILING PLAN FOR DESIGN INTENT ONLY.
 - VERIFY WITH MECHANICAL DRAWINGS, CEILING REGISTER SIZE, TYPE, AND DENSITY.
 - VERIFY WITH ELECTRICAL DRAWINGS, LIGHT FIXTURE SIZE, TYPE AND QUANTITY.



ARKANSAS GAME AND FISH COMMISSION
JONESBORO FIELD OFFICE RECONSTRUCTION
600 EAST LAWSON RD
JONESBORO, AR 72404

PROJECT TITLE

CONTENTS

REVISIONS

SHEET

NO. DATE DESCRIPTION

25-065

JOB. NO.

07.30.2026

DATE

CD SET

ISSUE

A110