




C:\Users\cmw\AppData\Local\Temp\20267268\cmw\AutoCAD\Plot\AutoCAD_Plot_20267268.dwg Plot Date: 07/30/2026 10:44:44 AM Plotter: HP DesignJet T1100 Plot Size: 11x17 inches Plot Scale: 1/8" = 1'-0" Plotter Driver: HP DesignJet T1100 PCL6

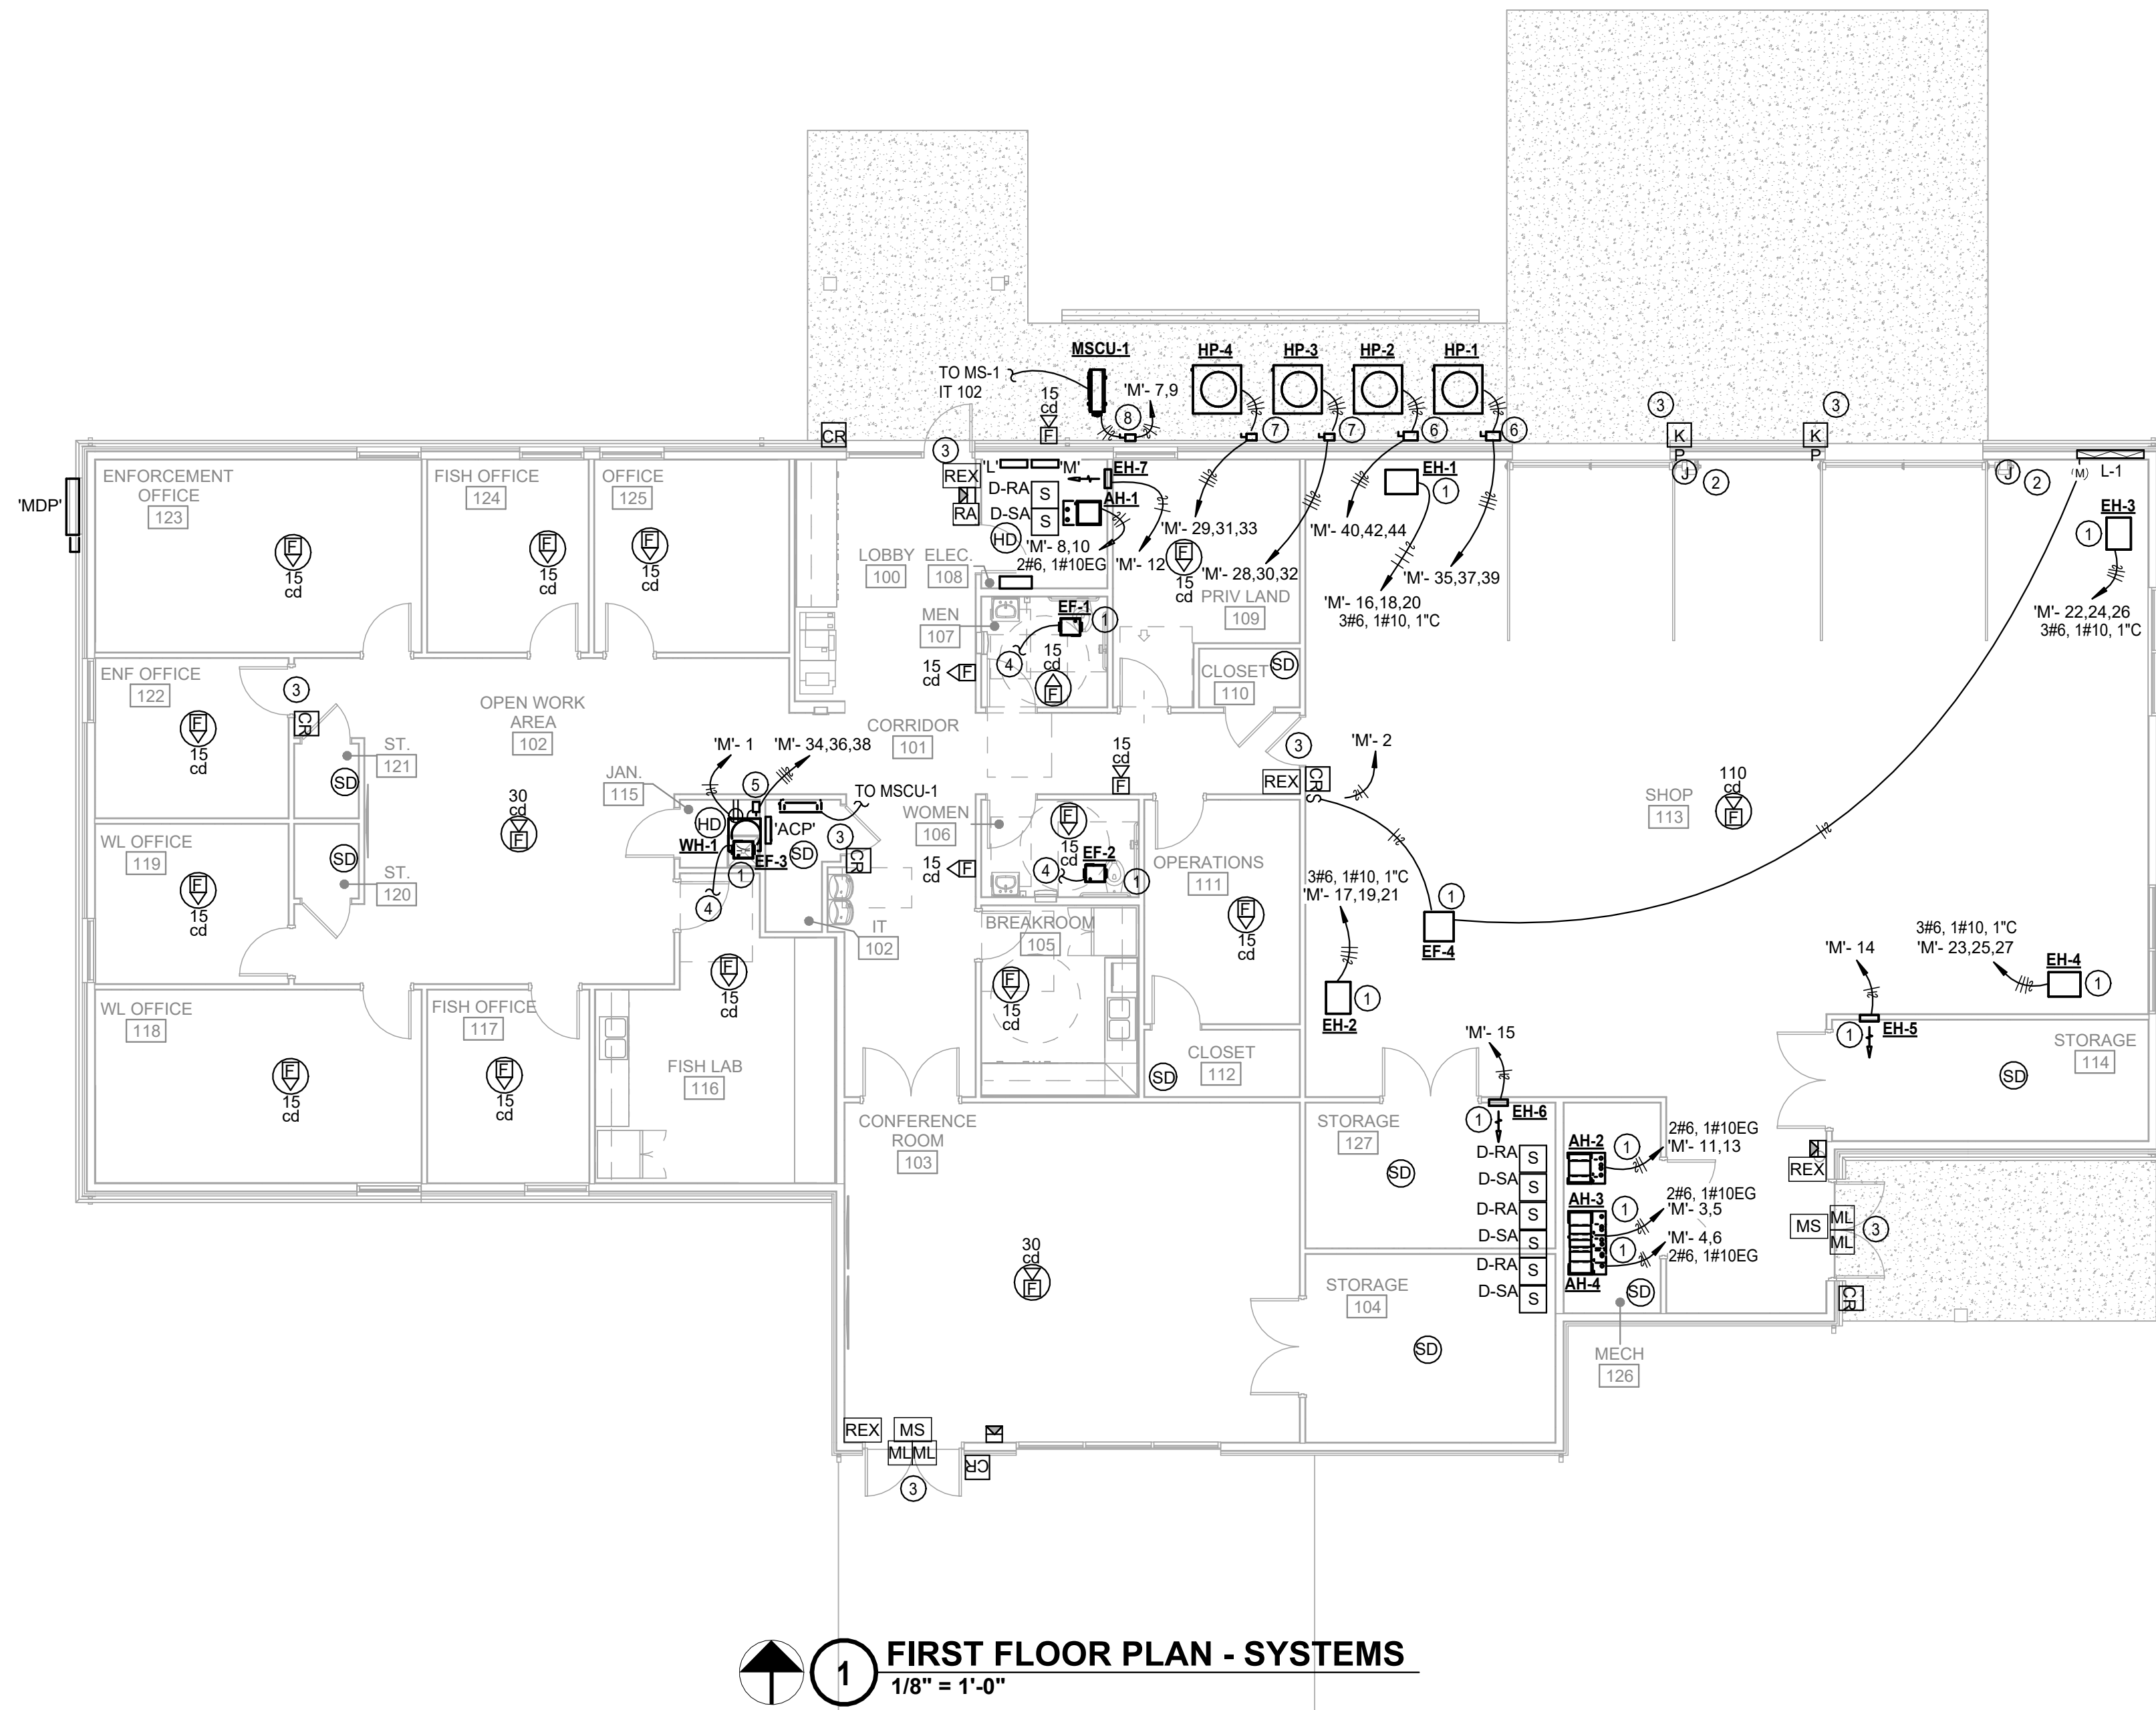

1 FIRST FLOOR PLAN - SYSTEMS
1/8" = 1'-0"

SYSTEMS KEYED NOTES

- 1 DISCONNECT PROVIDED BY DIVISION 23/HVAC.
- 2 GARAGE DOOR OPENER. COORDINATE INSTALLATION WITH GENERAL CONTRACTOR.
- 3 REFER TO ACCESS CONTROL DIAGRAM, PROVIDE ALL BOXES AND CONDUIT AS NEEDED.
- 4 EXHAUST FAN TO BE CONTROLLED WITH LIGHTING CIRCUIT.
- 5 WH-1: DISCONNECT SHALL BE: 30A/3P, NF, HD, NEMA 1. WIRE SHALL BE: 3#10, 1#10EG, 3/4" C.
- 6 HP 1 AND 2: DISCONNECT SHALL BE: 60A/3P, NF, HD, NEMA 3R. WIRE SIZE: 3#8, 1#10EG, 3/4" C.
- 7 HP 3 AND 4: DISCONNECT SHALL BE: 30A/3P, NF, HD, NEMA 3R. WIRE SIZE: 3#10, 1#10EG, 3/4" C.
- 8 MSCU-1: DISCONNECT SHALL BE: 30A/2P, NF, HD, NEMA 3R.

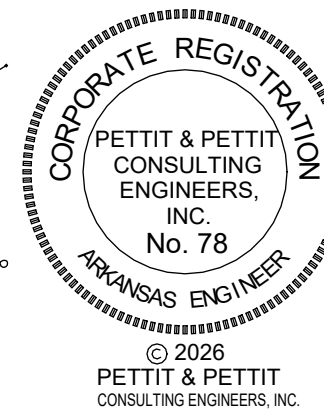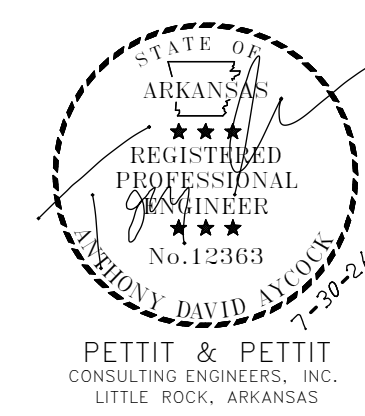

ARKANSAS GAME AND FISH COMMISSION
JONESBORO FIELD OFFICE RECONSTRUCTION
600 EAST LAWSON RD
JONESBORO, AR 72404

FIRST FLOOR PLAN - SYSTEMS

NO. DATE DESCRIPTION

25-065

07.30.2026

ISSUE

E103