

UAPB L.A. DAVIS STUDENT UNION

1200 UNIVERSITY
DR, PINE BLUFF
AR, 71601

INSIGHT ENGINEERING, PLLC

1818 N. TAYLOR #237
LITTLE ROCK, AR 72207
501.237.3077



Providing bold and creative
solutions for the built environment.


SHEET INDEX

C101	COVER SHEET
M001	GENERAL NOTES AND LEGEND - HVAC
M101	FIRST FLOOR DEMOLITION PLAN - MECHANICAL
M201	FIRST FLOOR PLAN - MECHANICAL
M301	DETAILS - HVAC
M401	SCHEDULES - HVAC
M501	CONTROLS - HVAC
E001	GENERAL NOTES AND LEGEND - ELECTRICAL
E101	FIRST FLOOR DEMOLITION PLAN - POWER
E201	FIRST FLOOR PLAN - POWER
E301	SCHEDULES - ELECTRICAL

PROJECT LOCATION:
PINE BLUFF, ARKANSAS



PROJECT AREA:
L.A. DAVIS STUDENT UNION

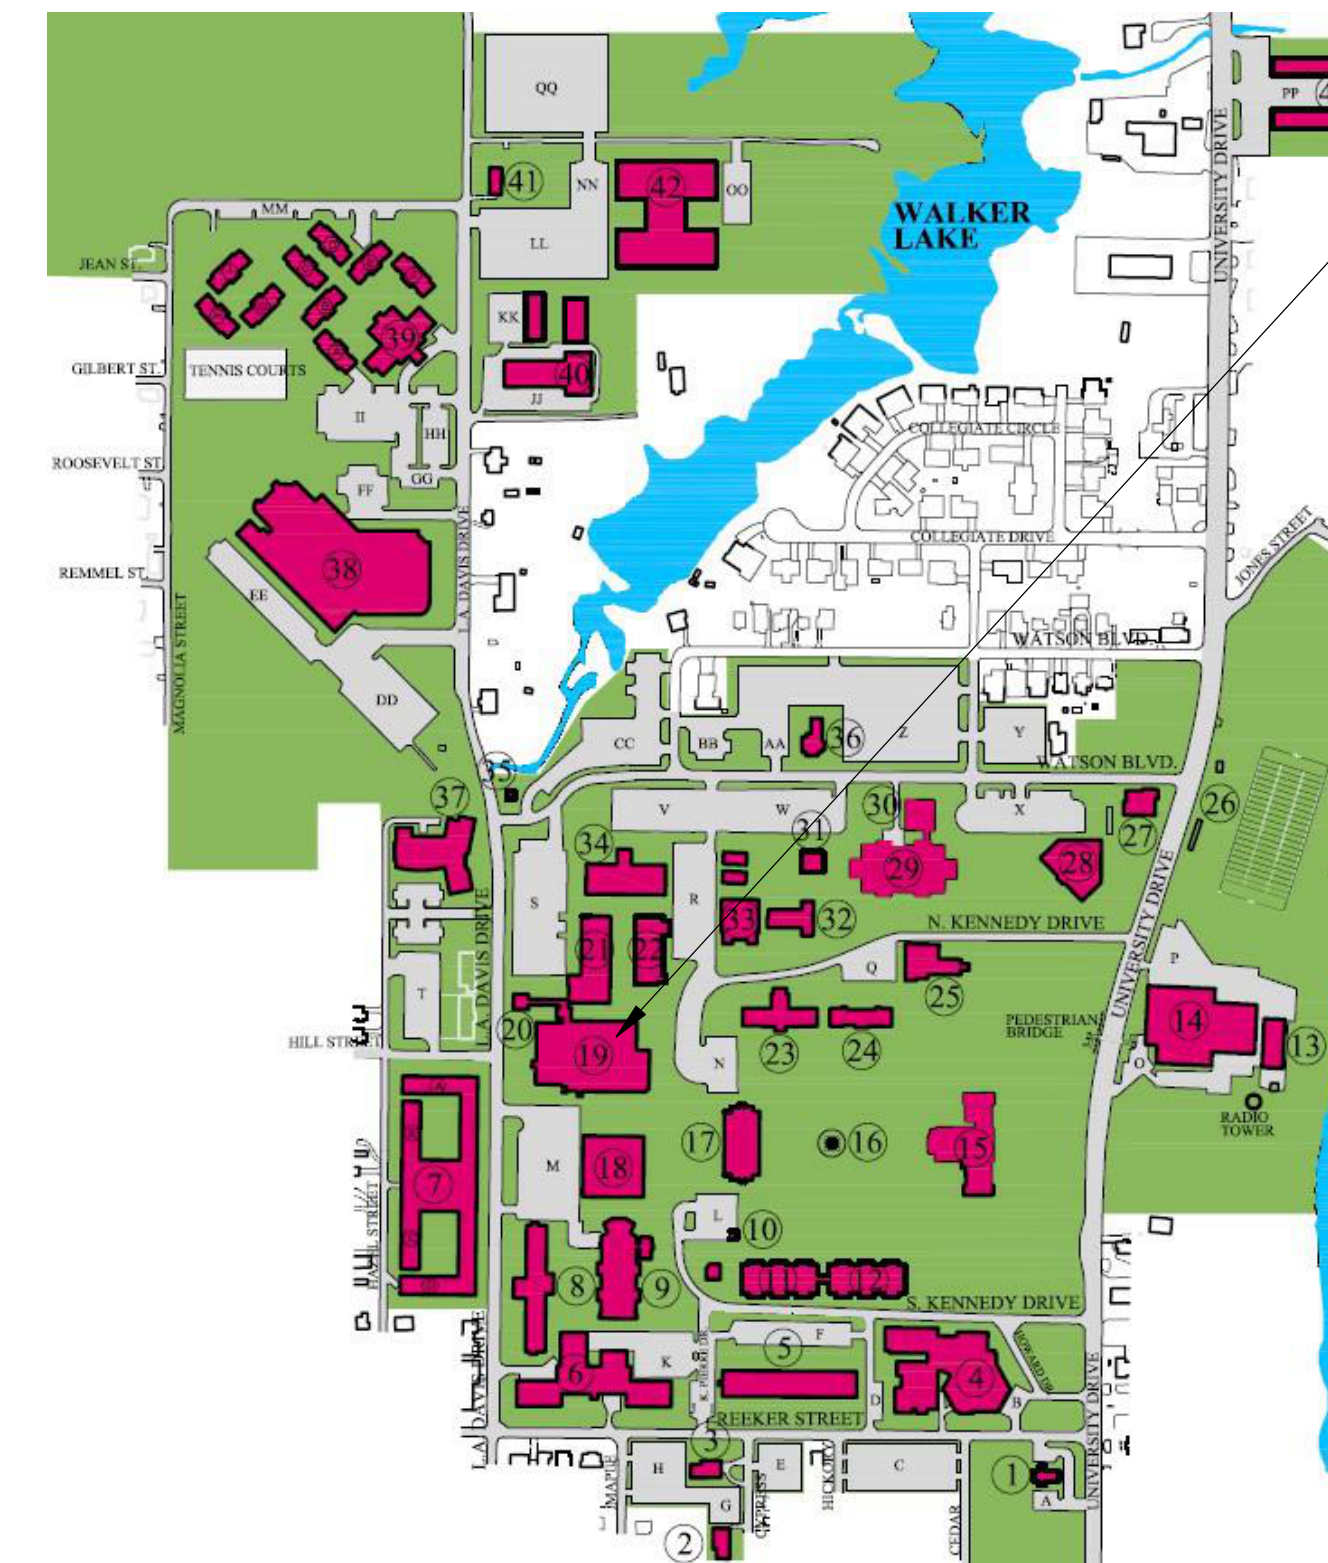

PROJECT STATUS:

**CONSTRUCTION
DOCUMENTS**

PROJECT ISSUE DATE:

03-18-25

PROJECT NUMBER:

24-113

SHEET NUMBER:

C101

