


GENERAL NOTES

SEE MP101 FOR THERMOSTAT LOCATIONS

KEYED NOTES

- 1 NEW LOCATION OF EXISTING VAV BOX. CLEAN BOX PRIOR TO RE-INSTALLATION. RECONNECT HW/SHWR PER MP101 SECOND FLOOR MECHANICAL PIPING PLAN.
- 2 NEW LOCATION OF EXISTING AIR DEVICE. ADJUST AIRFLOW TO INDICATED VALUES.
- 3 KITCHEN HOOD GREASE DUCTS SHALL BE FULLY WELDED 18 GA. STAINLESS STEEL WITH LIQUID TIGHT EXTERNAL WELDS AND MINIMUM 1/4" PER FOOT SLOPE IN THE DIRECTION OF THE HOOD, FAN, OR GREASE CLEANOUT. INSULATE GREASE DUCTS WITH A 2-HOUR, TWO-LAYER FIRE WRAP SYSTEM AS SPECIFIED.

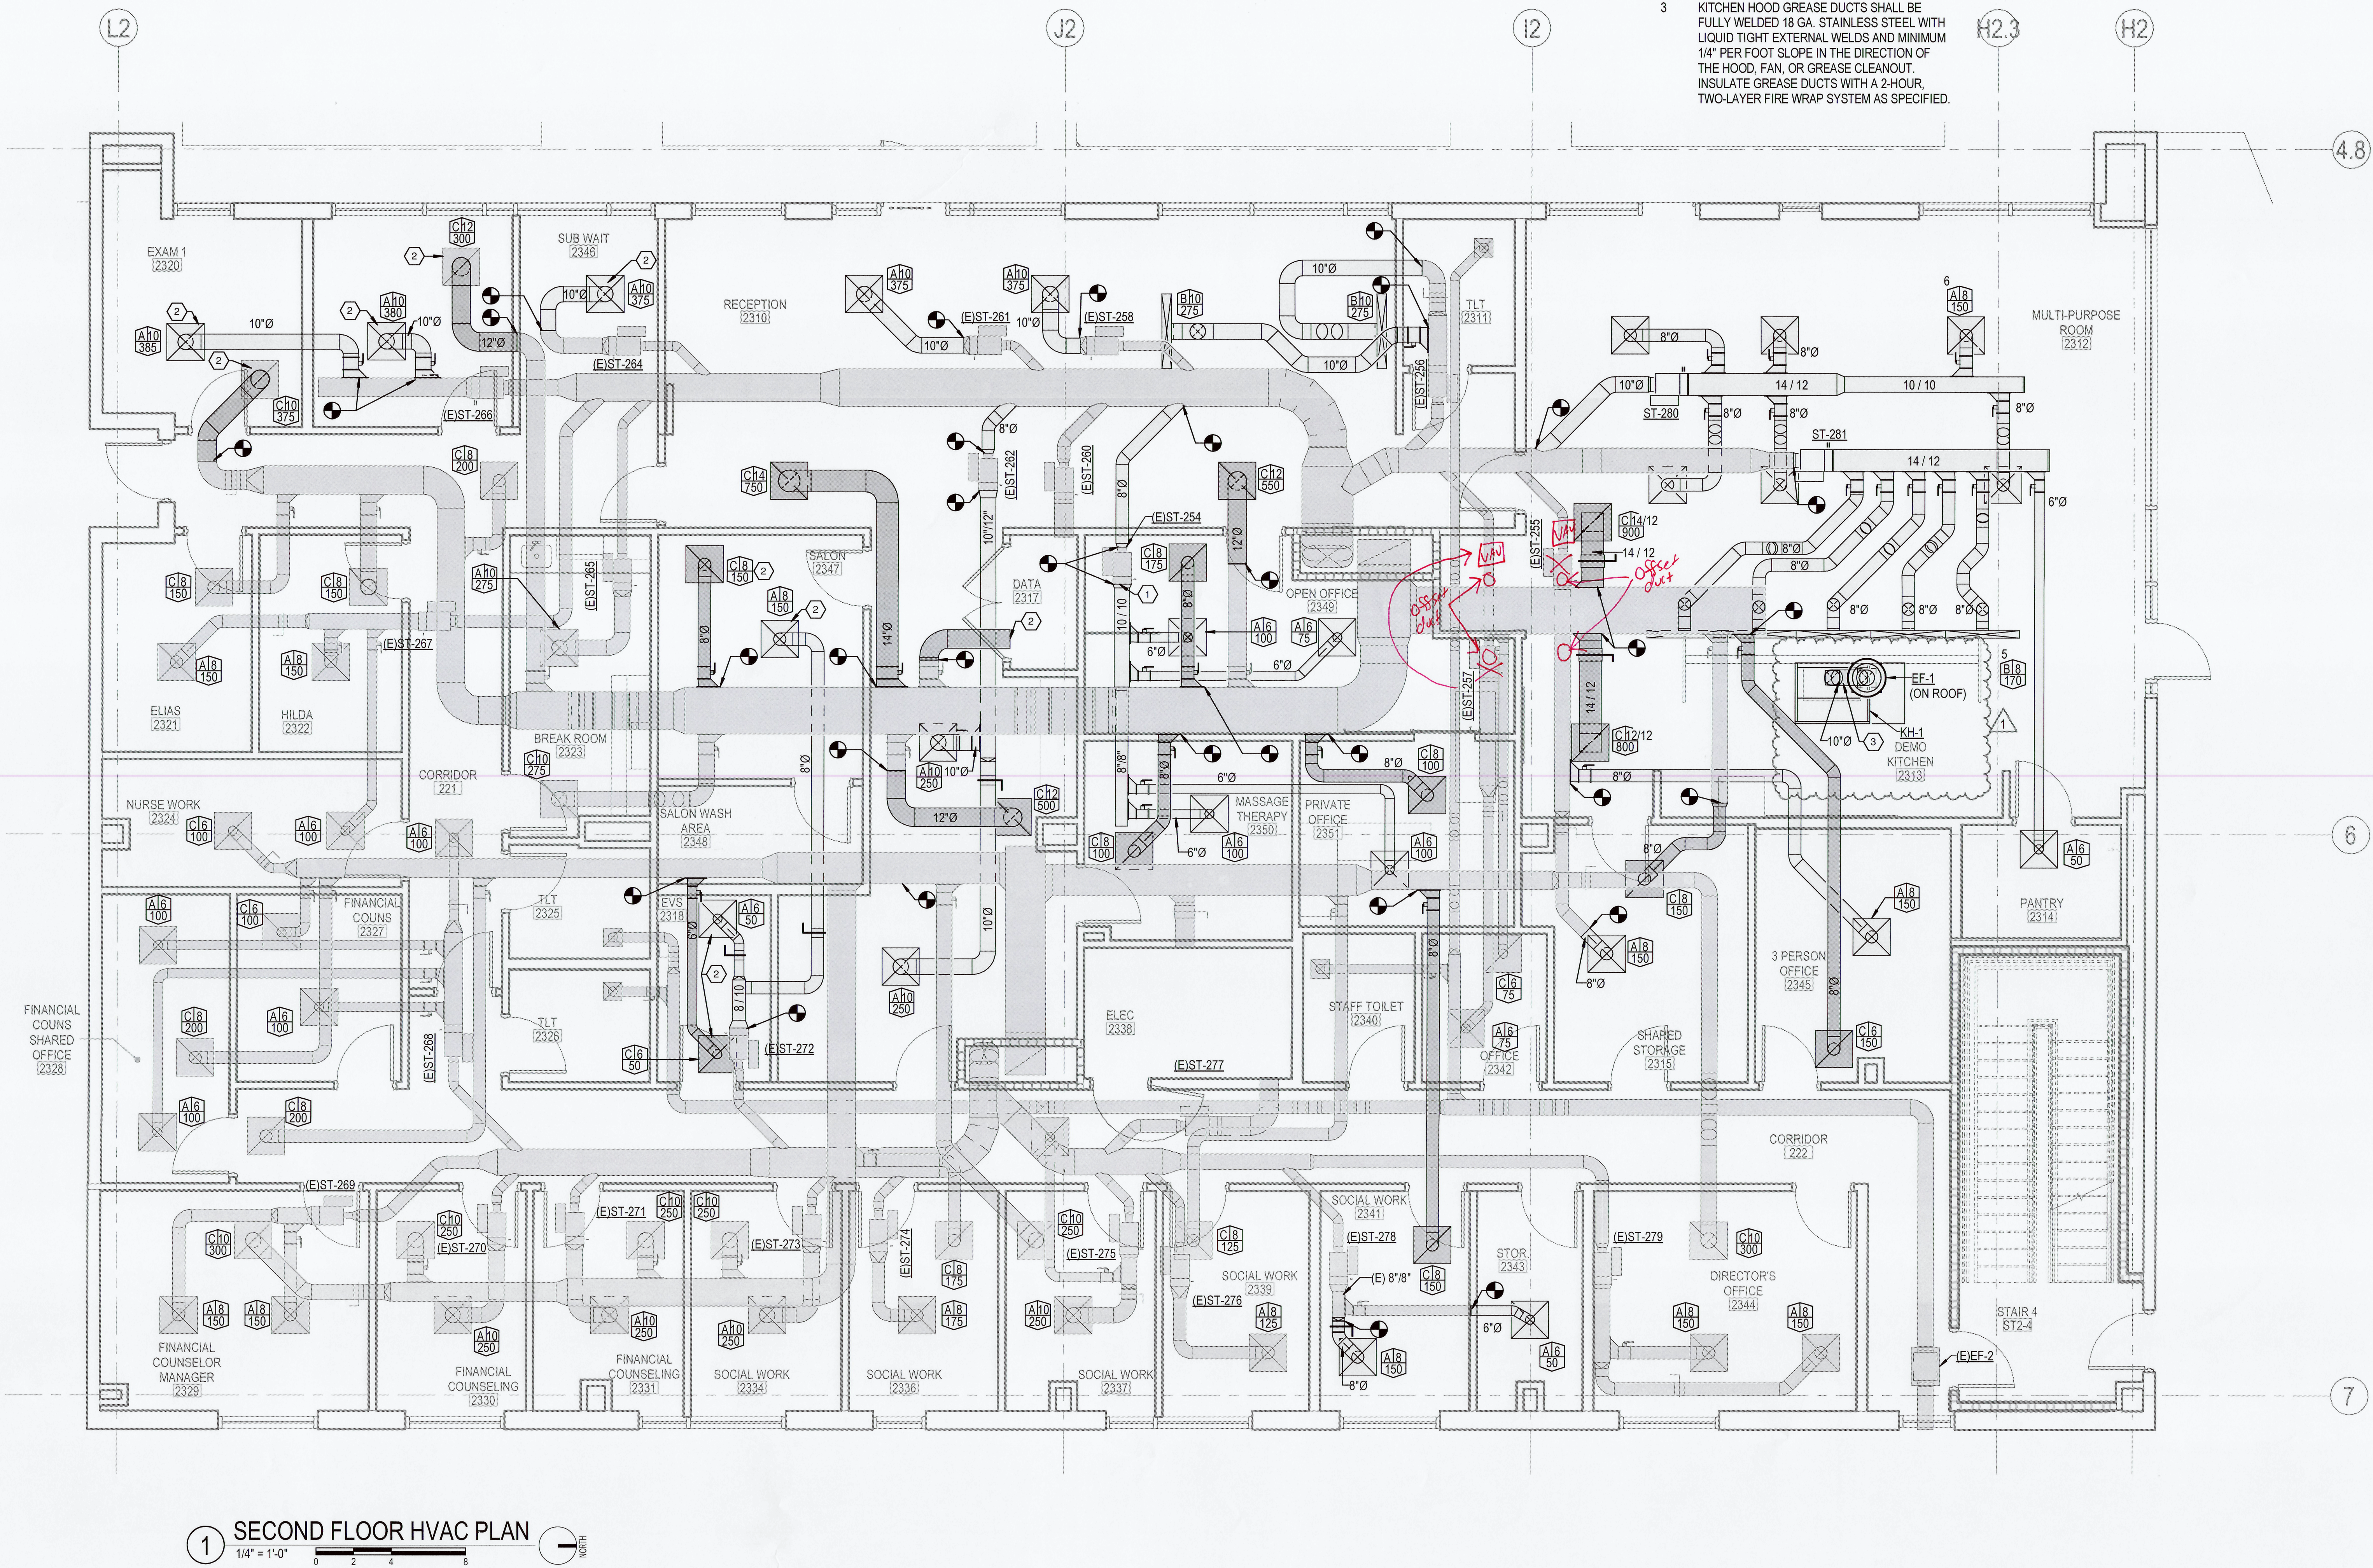

Project: CARTI CANCER CENTER-BRIDGE PATIENT RESOURCE CENTER

Design Phase: CONSTRUCTION DOCUMENTS

No.	Date	Description
1	01-05-2024	PR 004

Notes:
1. CROMWELL ARCHITECTS ENGINEERS, INC. ALL RIGHTS RESERVED
2. THIS SHEET DESIGNED FOR COLOR PRINTING. CRITICAL INFORMATION MAY BE LOST WITH BLACK AND WHITE PRINTING.

Project Number: 2020-171
Issue Date: 04-06-2023
Sheet Title: SECOND FLOOR MECHANICAL PLAN
Sheet Number: M-101